


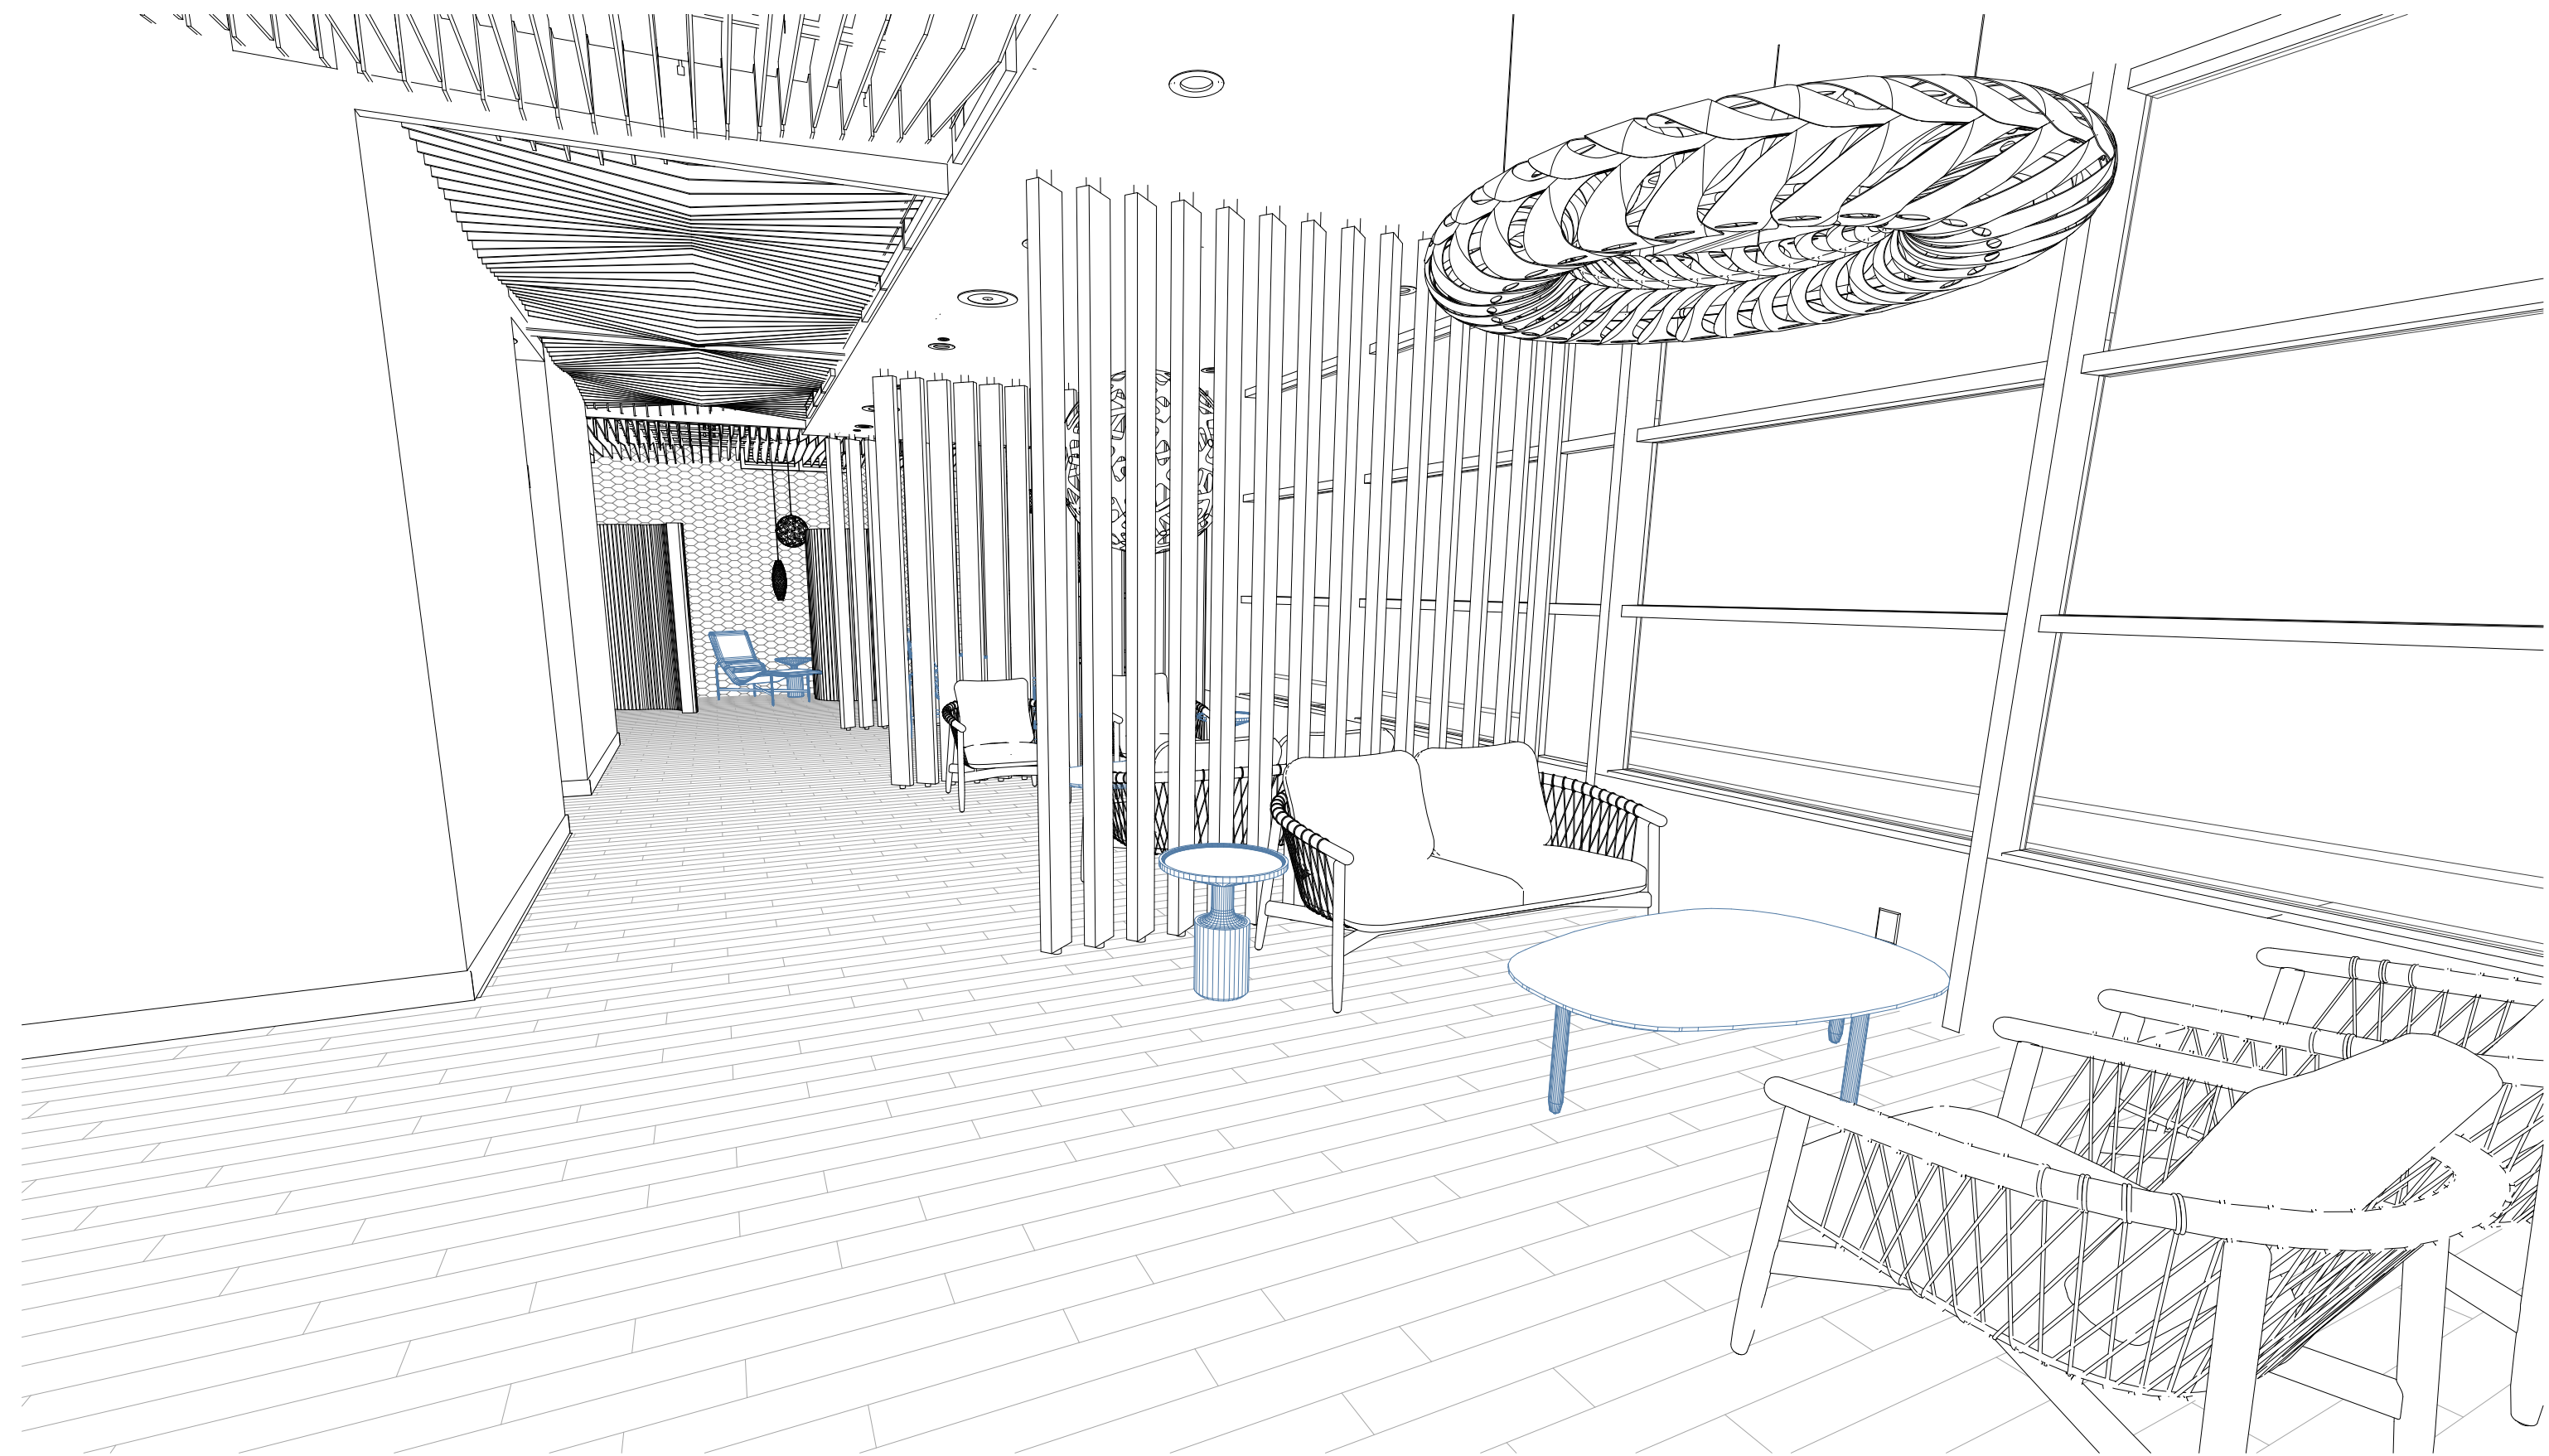

1 Relax suite south

KSU
ID

Kylie Arett

Kylie Arett
ID 645
Spring Semester
kkarett@ksu.edu

The Origins Wellness Center
4TH & PIERRE ST. MANHATTAN,
KS. 66502

Description	Date

Cover Sheet


Date	Issue Date
Drawn by	
Checked by	
G-01	
Scale	

PROJECT INFORMATION

PROJECT NAME	The Origins
PROJECT ADDRESS	4TH & PIERRE ST. MANHATTAN, KS. 66502
TOTAL BUILDING SQUARE FOOTAGE	4,000 SQFT
NUMBER OF EMPLOYEES	TO BE CONFIRMED
MAXIMUM OCCUPANCY LOAD	219
OCCUPANCY TYPE	MIXED: A2, B2
CONSTRUCTION TYPE	TYPE 4
SPRINKLERED	FULLY SPRINKLERED

Sheet List	
Sheet Number	Sheet Name
G-01	Cover Sheet
G-02	Title Sheet
ID-C1	Life Safety Plan
ID-1.1	Partition Plan
ID-2.1	Reflected Ceiling Plan
ID-3.1	Power and Comm
ID-3.2	Switching Plan
ID-4.1	Finish Plan
ID-5.1	Furniture Plan
ID-6.1	Enlarged Plan ADA Toilet
ID-6.2	Enlarged Plan Northern Locker Room
ID-6.3	Enlarged Plan Reception
ID-6.4	Enlarged Plan ADA Treatment Room
ID-7.1	Elevations Relaxation Suite
ID-7.2	Elevations Decompression Zone
ID-8.1	Details Reception Desk
ID-8.2	Details Casework
ID-8.3	Partition Types
ID-8.4	GreenWall Details
ID-8.7	Hardware and Door Schedule
ID-8.5	Rotating Partition Details
ID-8.6	Material Details
ID-D1	Demolition Plan
ID-4.2	Finish Schedule
ID-1.2	Partition Measurements


Room Schedule				
Name	Number	Area	Occupancy	Occupant
Storage/Janitor	401	74 SF	Business	1
Shaft	402	45 SF	N/A	0
Lobby	403	1258 SF	Assembly	83
Relaxation Suite S	404	1138 SF	Assembly	75
Sauna	405	86 SF	Business	1
Steam Room	406	78 SF	Business	1
Pod Room	407	71 SF	Business	1
Pod Room	408	68 SF	Business	1
Treatment	409	108 SF	Business	1
Treatment	410	101 SF	Business	1
Treatment	411	113 SF	Business	1
Treatment	412	108 SF	Business	1
South Stair	413	230 SF		
Decompression	414	371 SF	Assembly	24
Locker Room	415	356 SF	Assembly	26
Shower	416	48 SF	N/A	1
Shower	417	48 SF	N/A	1
Shower	418	48 SF	N/A	1
ADA Shower	419	56 SF	N/A	1
Toilet	420	32 SF	N/A	1
Linen	421	18 SF	N/A	1
Back Room	422	678 SF	Business	6
Laundry	423	74 SF	Business	1
Reception	424	300 SF	Business	3
Womens Room	425	75 SF	Assembly	1
ADA Toilet	426	75 SF	N/A	1
Decompression	427	376 SF	Assembly	25
Treatment	428	121 SF	Business	1
Treatment	429	135 SF	Business	1
Treatment	430	101 SF	Business	1
Treatment	431	113 SF	Business	1
Pod Room	432	66 SF	Business	1
Pod Room	433	67 SF	Business	1
Relaxation Suite N	434	1038 SF	Assembly	69
Sauna	435	82 SF	Business	1
Steam Room	436	79 SF	Business	1
Main Stair	437	278 SF		
Locker Room	438	355 SF	Assembly	26
ADA shower	439	53 SF	N/A	1
ADA Shower	440	56 SF	N/A	1
Shower	441	47 SF	N/A	1
Shower	442	48 SF	N/A	1
Shower	443	47 SF	N/A	1
Balcony	444	Not Enclosed	Assembly	13

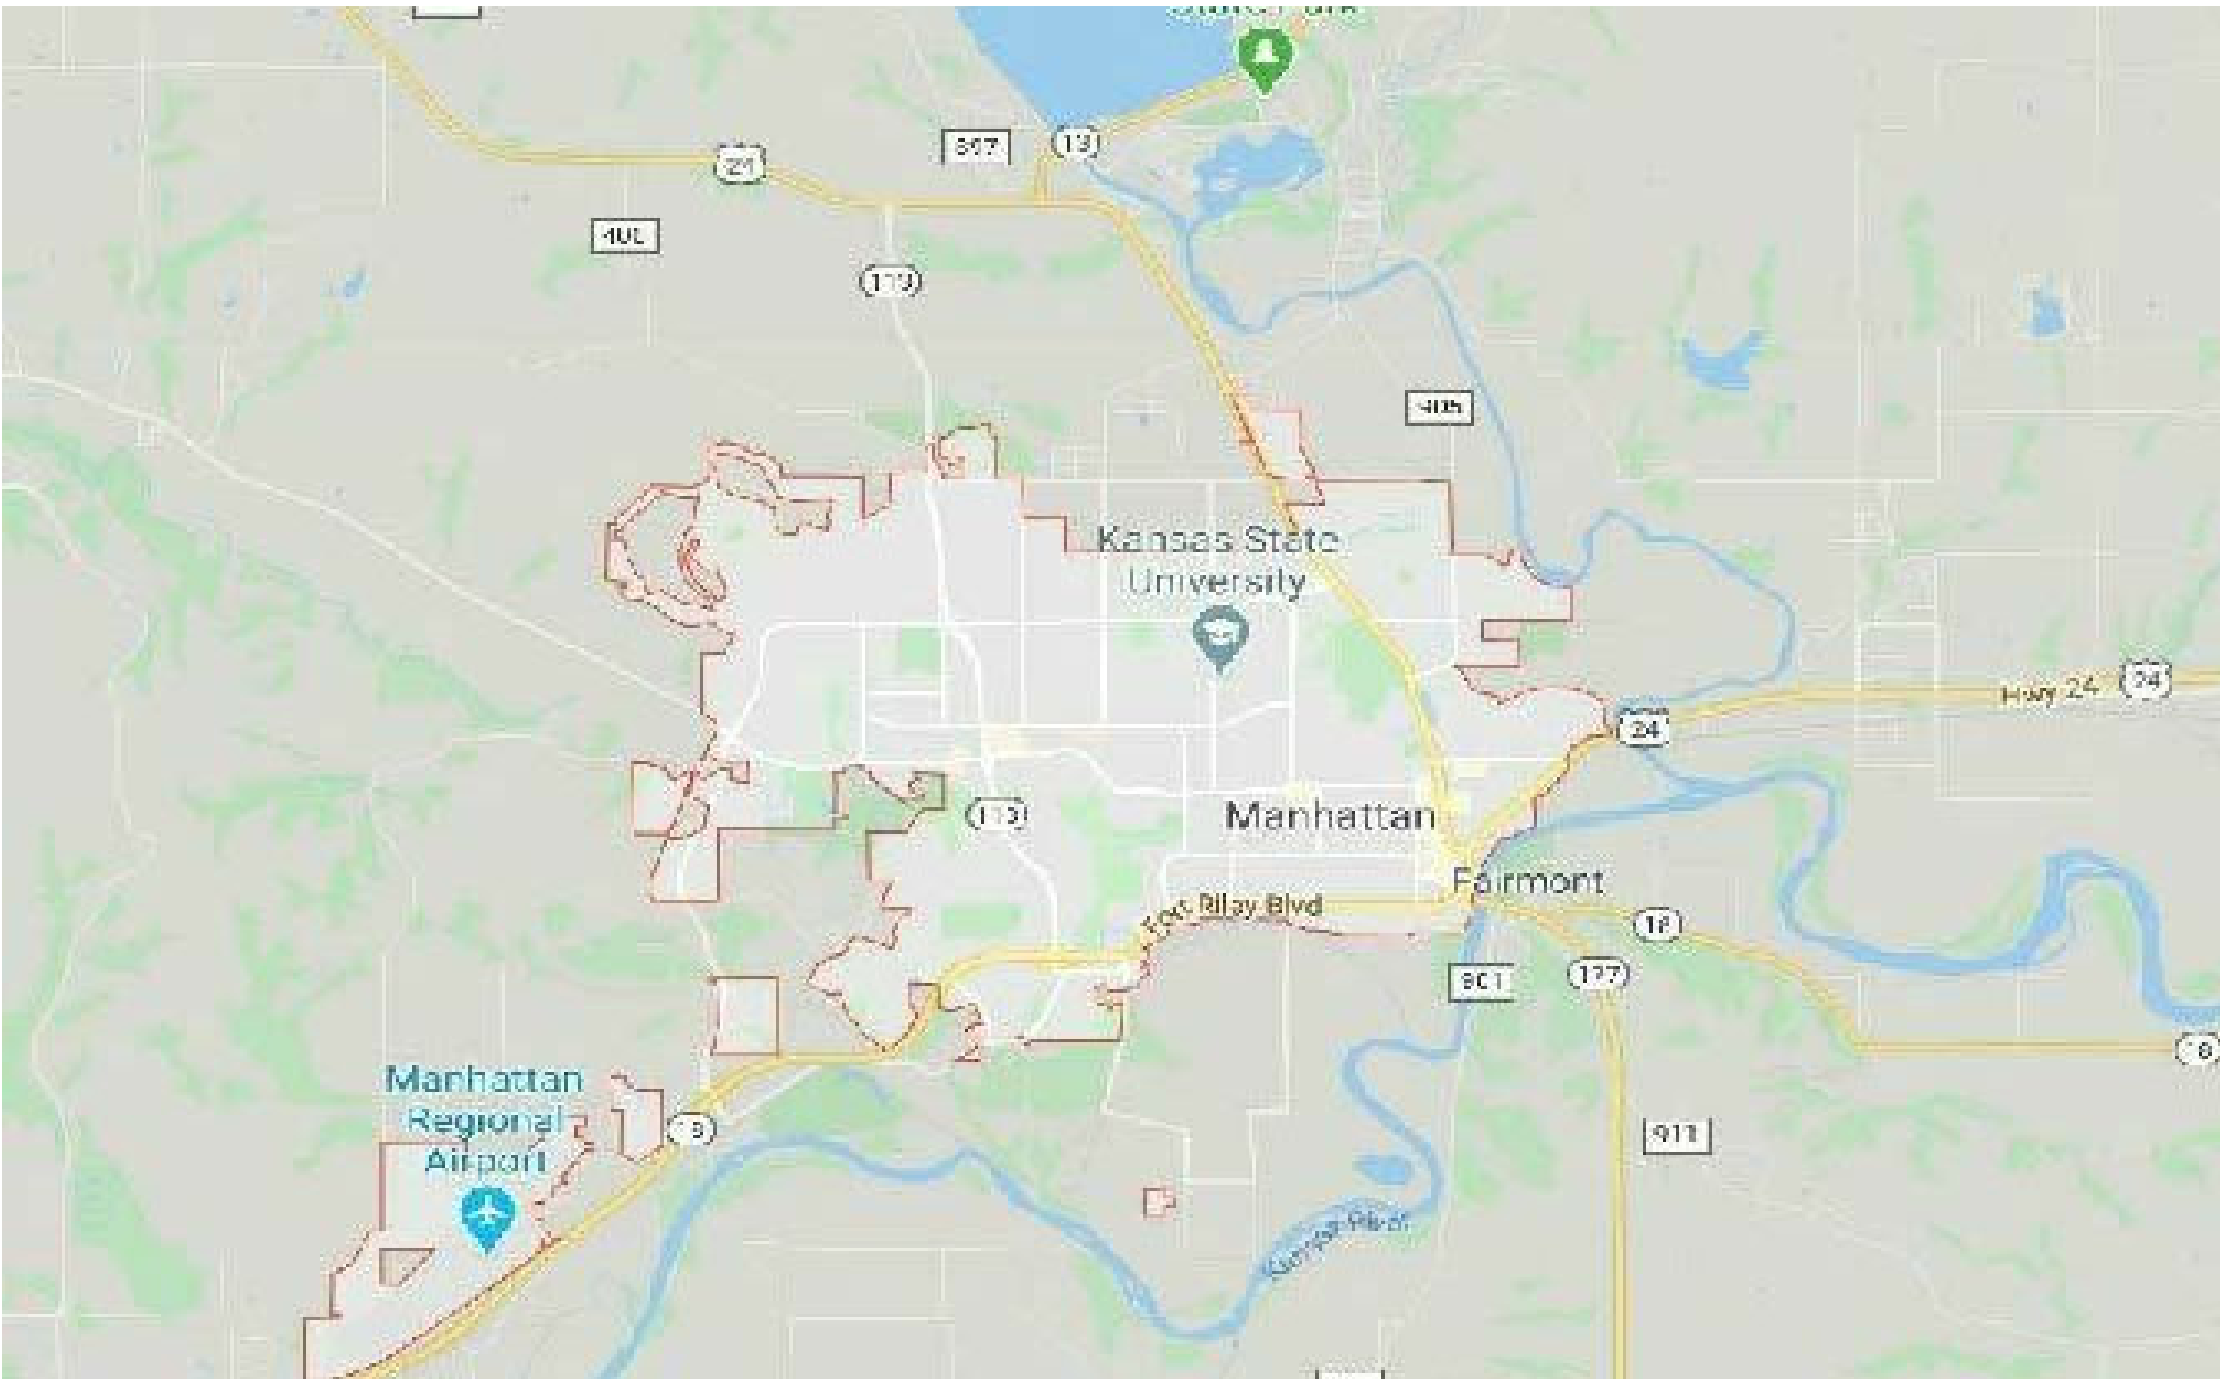

Satellite view of Manhattan, Kansas



Satellite view of 4th and Pierre St.

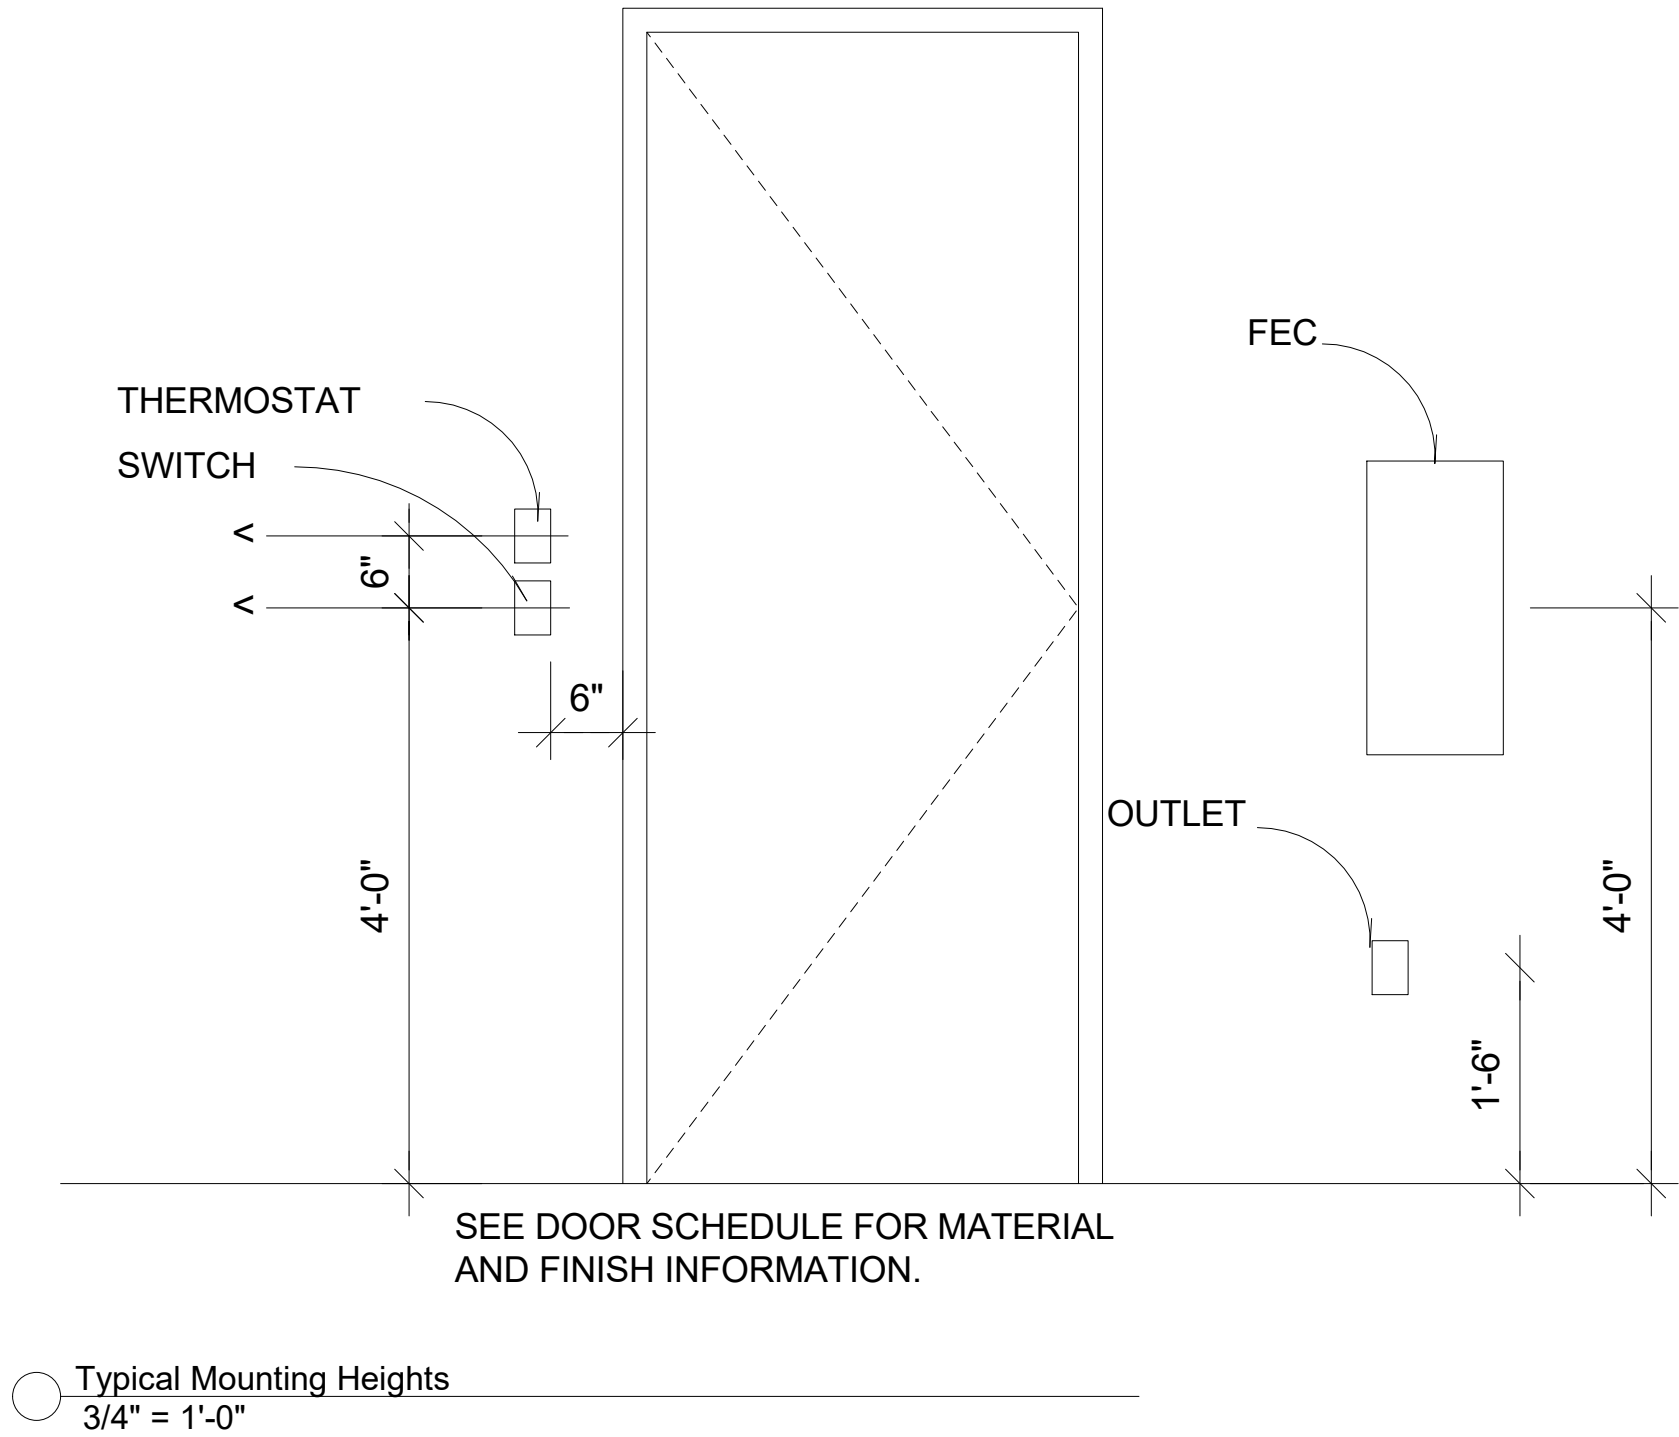

ANNOTATION SYMBOLS			
	DETAIL CALLOUT		
	DOOR TAG		
	WALL TAG		
	WINDOW TAG		
ABBREVIATIONS		CODE INFORMATION	
AFF	ABOVE FINISHED FLOOR	2015 INTERNATIONAL MECHANICAL CODE 2015 INTERNATIONAL PLUMBING CODE 2015 INTERNATIONAL FUEL GAS CODE 2015 INTERNATIONAL BUILDING CODE 2015 INTERNATIONAL EXISTING BUILDING CODE 2015 INTERNATIONAL FIRE CODE 2014 NATIONAL ELECTRICAL CODE - ACCESSIBILITY CODE ADAAG	
DIM	DIMENSION		
FEC	FIRE EXTINGUISHER CABINET		
FFE	FINISH FLOOR ELEVATION		
FRP	FIRE RATED PROTECTED		
GC	GENERAL CONTRACTOR		
GWB	GYPSUM WALL BOARD		
HORIZ	HORIZONTAL		
NTS	NOT TO SCALE		
OC	ON CENTER		
ICU	IRRIGATION CONTROL UNIT		
MATERIAL INDICATIONS			
	TYPE: HARDWOOD MANUFACTURER: ASM STILE STYLE: PLANK COLOR: ROVERE SMOKED DARK		
	TYPE: CASALGRANDE PORCELAIN MANUFACTURER: ASM CasalGrande STYLE: 24" X 12" COLOR: BIANCO CASSERO		
	TYPE: CORK TILE MANUFACTURER: VERSACORK STYLE: PRE-FINISHED COLOR: NATURAL WITH BLACK GROUT		

KSU
ID

Kylie Arett

Kylie Arett
ID 645
Spring Semester
kkarett@ksu.edu

The Origins Wellness Center
4TH & PIERRE ST. MANHATTAN,
KS. 66502

Description	Date

Title Sheet

Date	Issue Date
Drawn by	
Checked by	
G-02	
Scale	As indicated



SYMBOLS

- TRAVEL DISTANCE: 36'-6" + 26'-6"
=63'-0"
- TRAVEL DISTANCE: 6'-6" + 23'-2 1/2" + 42'-0"
=71'-8 1/2"
- FARTHEST POINT FROM EXIT: 9'-2 3/4" + 6'-6" + 17'-0"
=32'-8 3/4"
- EXISTING CONSTRUCTION
- 2 HOUR RATED WALL
- 1 HOUR RATED DOOR
- 2 HOUR RATED DOOR

GENERAL NOTES

1. BUILDING CONSTRUCTION TYPE: TYPE 2, REFERENCE IBC TABLE 503
2. BUSINESS AND ASSEMBLY MIXED OCCUPANCY, REFERENCE IBC CHAPTER 3 FOR OCCUPANCY TYPES, REFERENCE IBC SECTION 508 FOR MIXED OCCUPANCY; TOTAL OCCUPANCY LOAD
3. 6 WATER CLOSETS AND 6 LAVATORIES REQUIRED, REFERENCE IBC TABLE 2902.1
4. 2 EXITS REQUIRED, REFERENCE IBC SECTION 1015
5. SEE ADA CLEARANCES, SPECIFICALLY FOR RESTROOMS, DOOR CLEARANCES, AND TURNING RADIUS
6. ALL DOORS ARE RATED FOR ONE HOUR

SHEET NOTES

1. THE COMMON PATH OF TRAVEL IS DETERMINED BY THE ADOPTED BUILDING CODE
2. THE LENGTH OF EXIT SEPARATION IS DETERMINED BY THE ADOPTED BUILDING CODE.

KSU
ID

Kylie Arett


Kylie Arett
ID 645
Spring Semester
kkarett@ksu.edu


The Origins Wellness Center
4TH & PIERRE ST. MANHATTAN,
KS. 66502

Description	Date

Life Safety
Plan

Date	Issue Date
Drawn by	
Checked by	
	ID-C1
Scale	As indicated

 

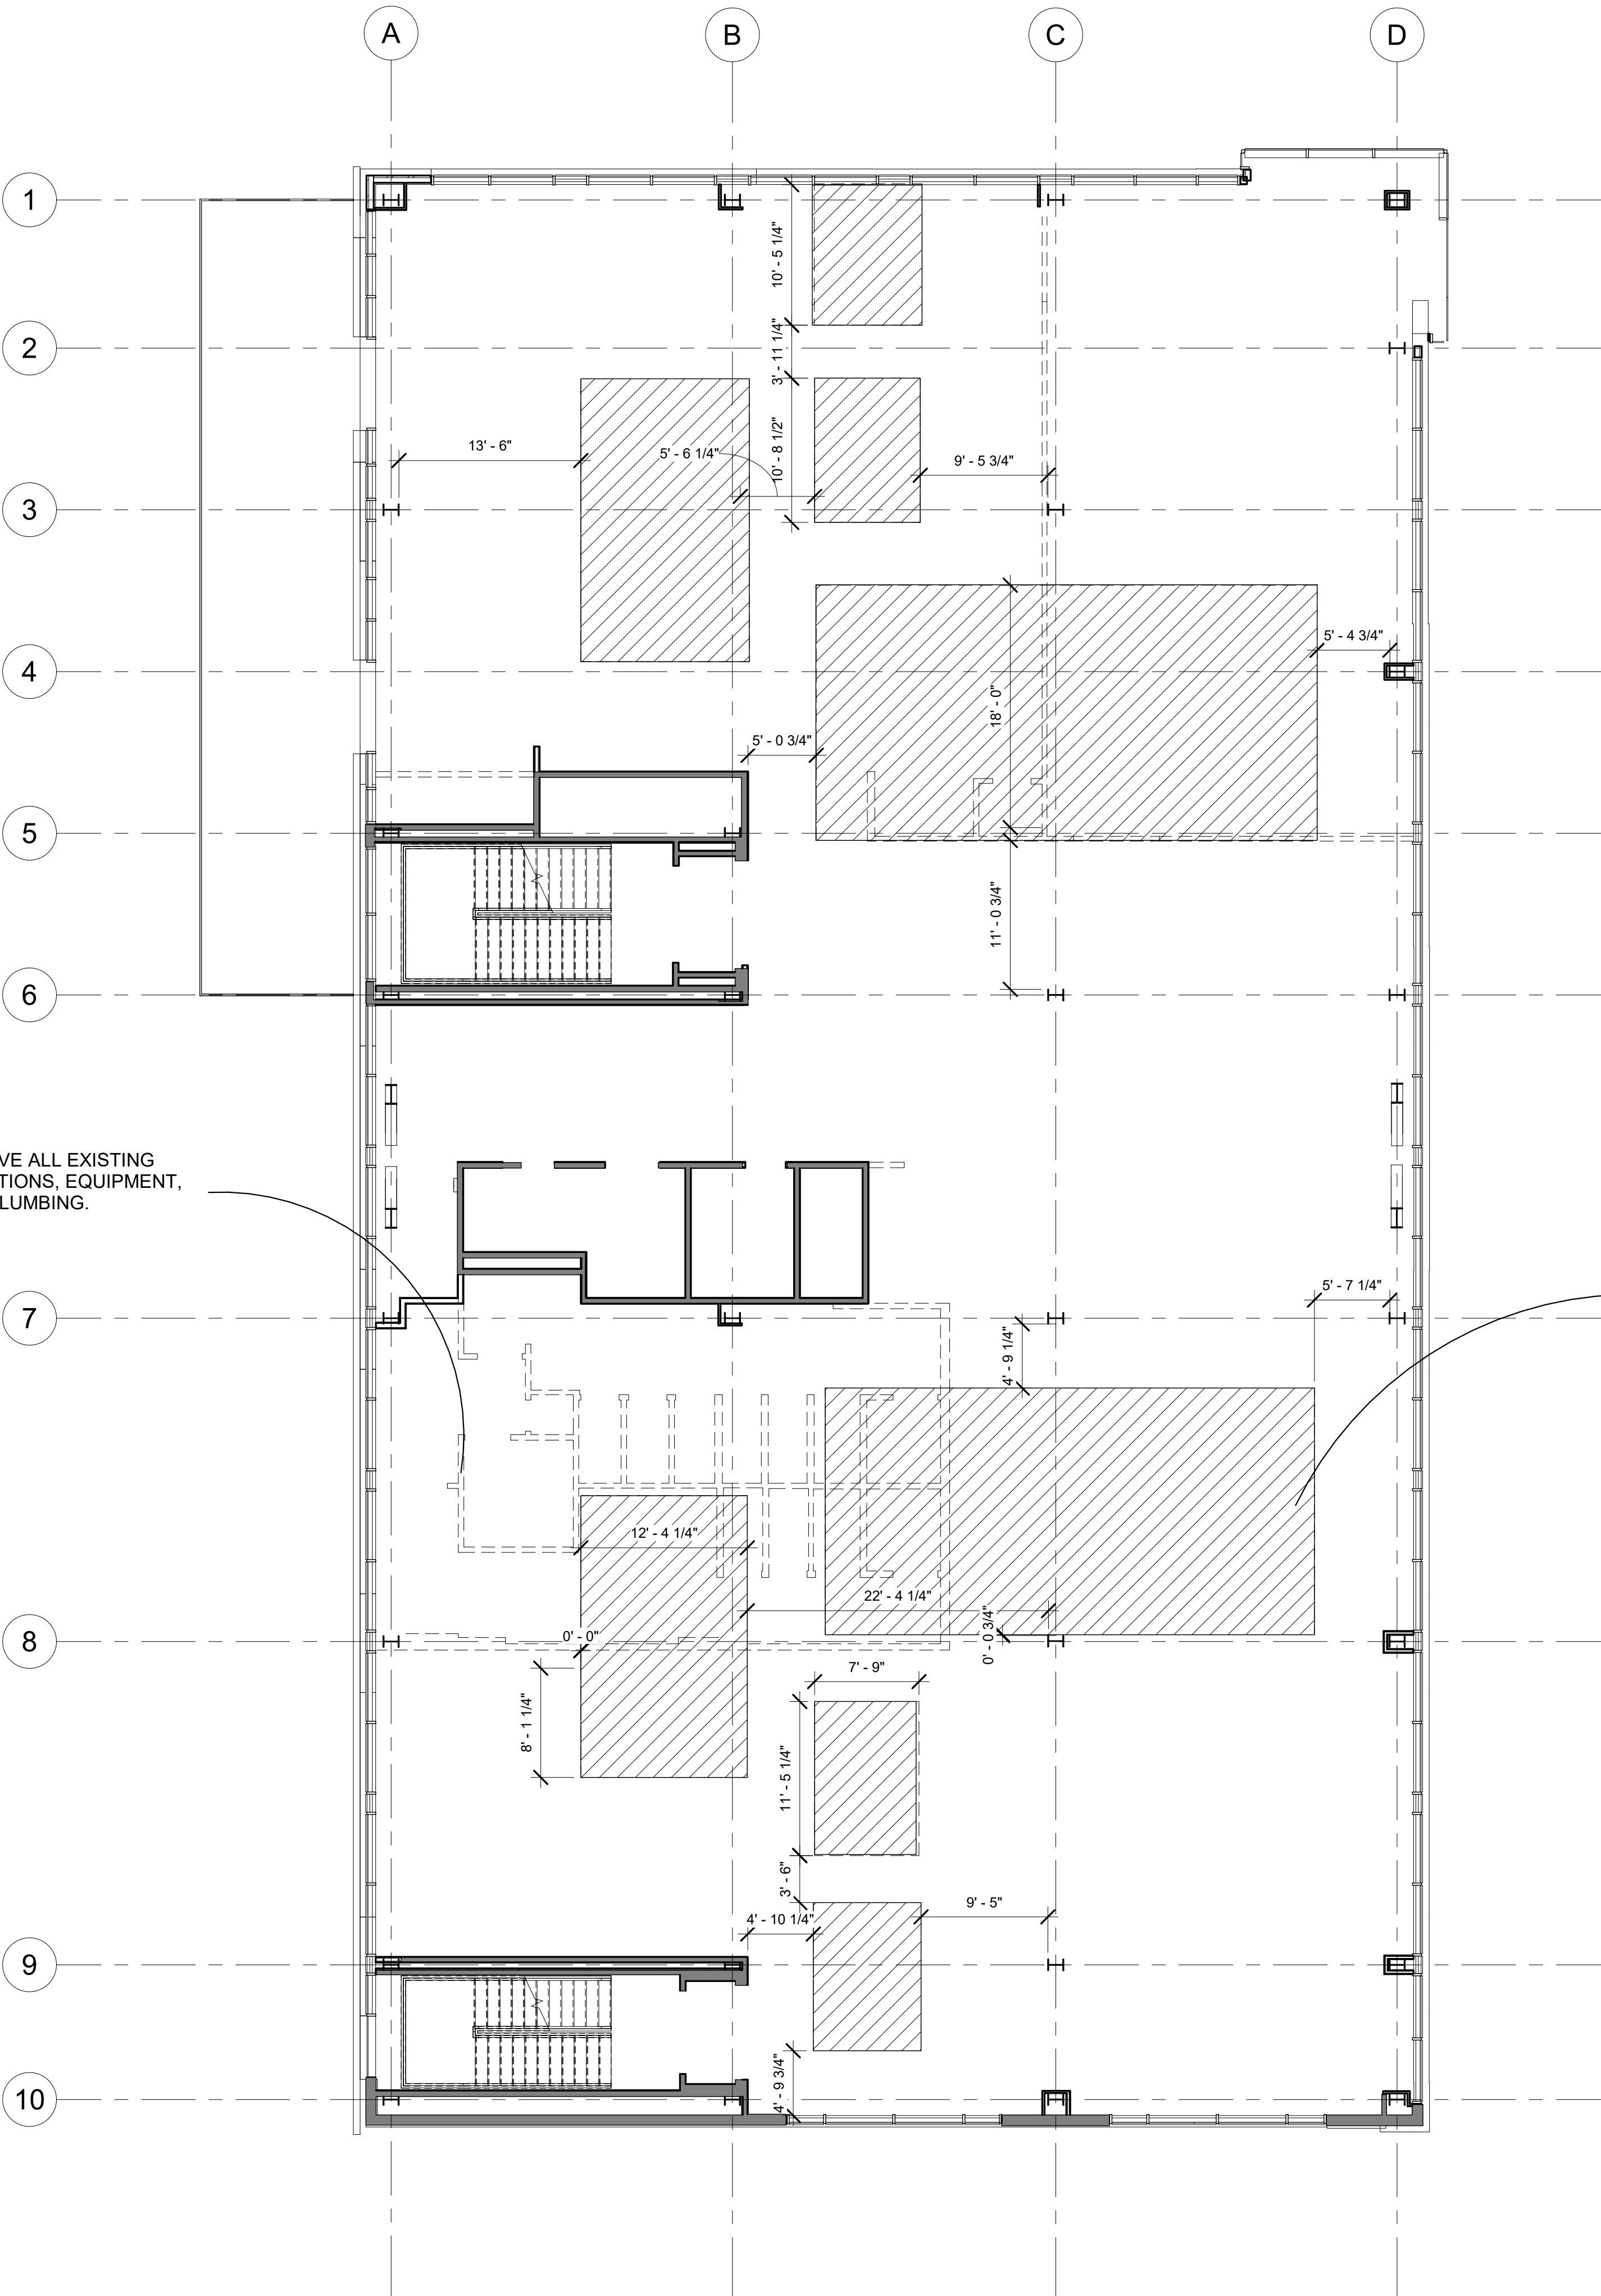


SYMBOLS

- EXISTING CONSTRUCTION
- DEMOLITION
- DEMOLITION FOR FLOOR OUTLETS
- DEMOLITION OF EXISTING RAISED FLOOR SYSTEM

GENERAL NOTES

- 1. SEE ROOM 118 ON PARTITION PLAN TO UNDERSTAND WHERE THE ELECTRICAL IS LOCATED
- 2. SEE POWER AND COMMUNICATION PLAN FOR MORE INFORMATION ON FLOOR OUTLETS.

 1 Demolition New
1/8" = 1'-0"



KSU
ID

Kylie Arett

Kylie Arett
ID 645
Spring Semester
kkarett@ksu.edu

The Origins Wellness Center
4TH & PIERRE ST. MANHATTAN,
KS. 66502

Description	Date

Demolition
Plan

Date

Issue Date

Drawn by


Checked by

ID-D1


Scale

As indicated

4/28/2021 2:39:43 PM

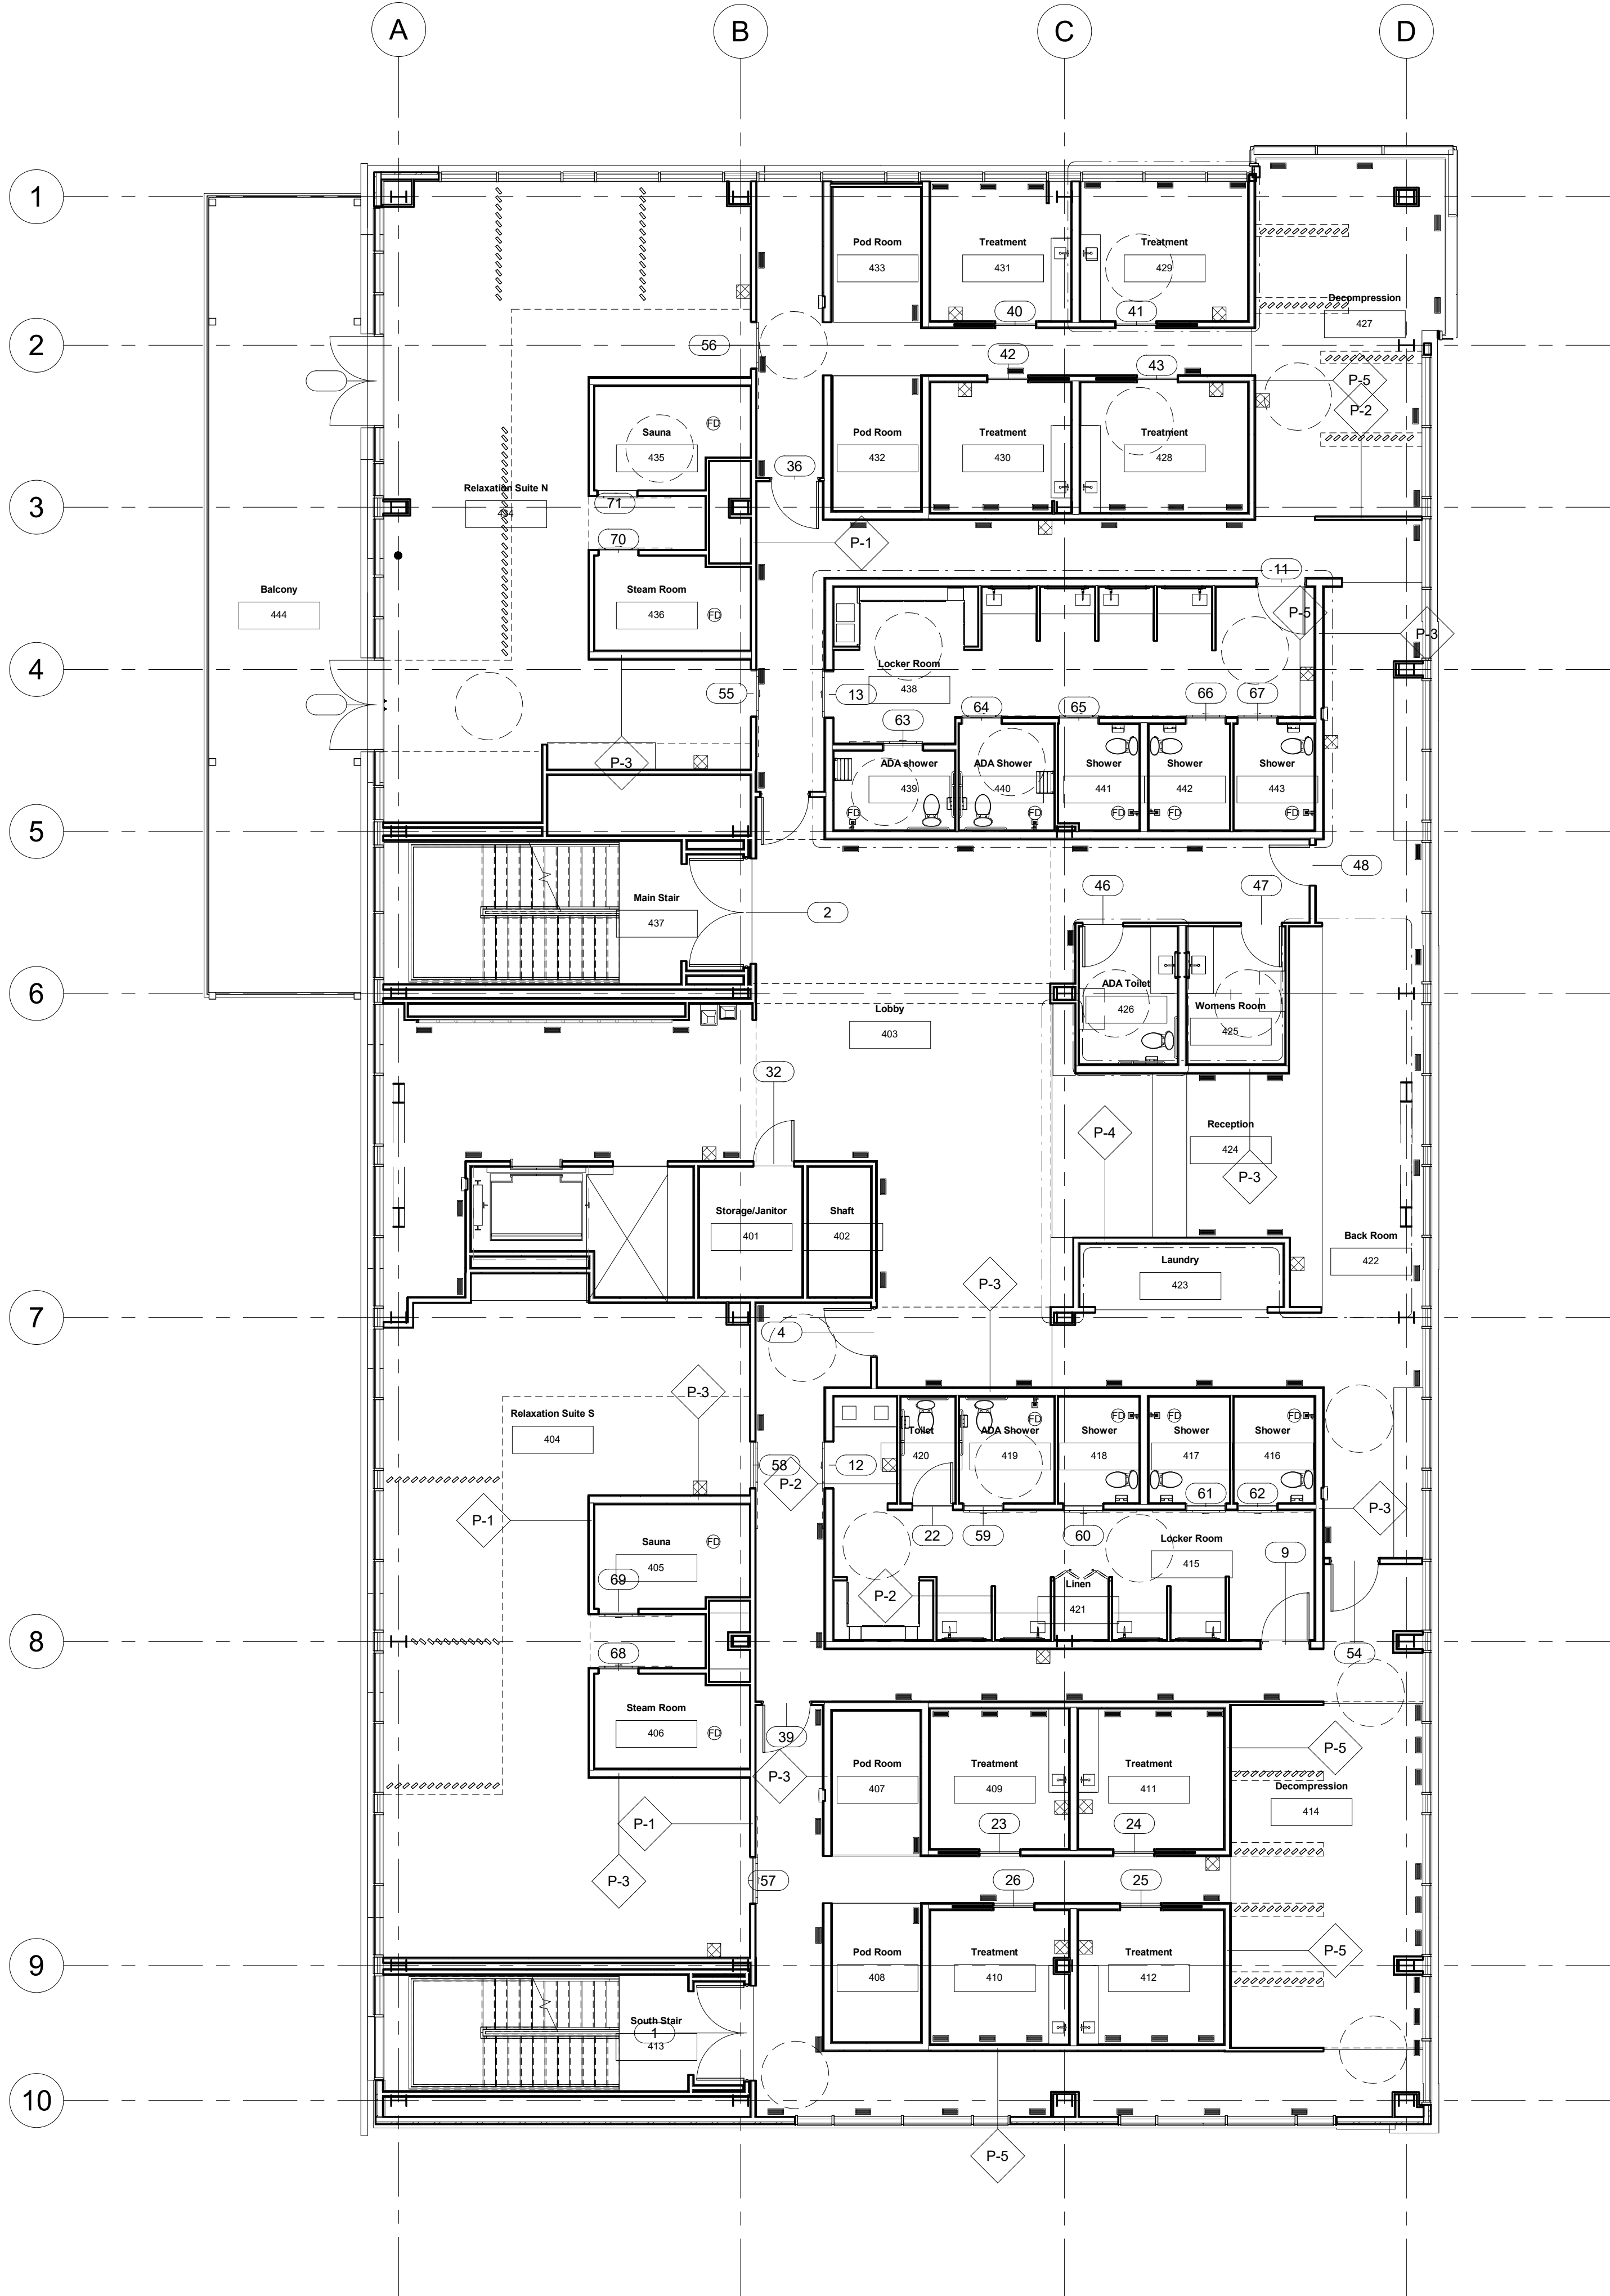

SYMBOLS

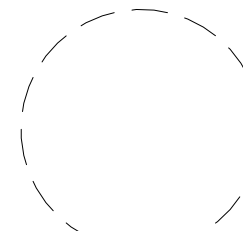

ADA TURNING RADIUS



 
DOOR TAG




WALL TAG




WINDOW TAG



DETAIL CALLOUT

 

OVERHEAD PLANE CHANGE

 

SECTION HEAD SYMBOL



ELEVATION SYMBOL

GENERAL NOTES

1. PROVIDE ONE FIRE EXTINGUISHER PER 3000 SQUARE FEET OF TENANT SPACE.
2. LIGHT GRAY THIN LINES INDICATE OVERHEAD PLANES.
3. ALL RESTROOMS MUST MEET ADA CODE.
4. ALL RESTROOM FIXTURES SHOULD BE MOUNTED ACCORDING TO MOUNTING HEIGHT STANDARDS LISTED ON SHEET G-02. IF FIXTURE DOES NOT HAVE A MENTIONED MOUNTING HEIGHT, IT SHOULD BE MOUNTED ACCORDING TO ADA REQUIREMENTS.
5. ALL PARTITION TYPE DETAILS CAN BE FOUND ON DETAIL SHEET ID-8.3.
6. DOOR HARDWARD AND DOOR SCHEDULE LOCATED ON SHEET ID-8.7.
7. ALL EXIT DOORS MUST OPEN OUT IN WAY OF EXITING THE BUILDING.
8. VERIFY ALL STRUCTURAL, MECHANICAL, AND ELECTRICAL REQUIREMENTS AND COORDINATE REQUIRED CHANGES WITH ARCHITECT PRIOR TO CONSTRUCTION.


Description	Date

Date	Issue Date
Drawn by	
Checked by	
ID-1.1	
Scale	As indicated



1 Measurements Plan
1/8" = 1'-0"

SYMBOLS

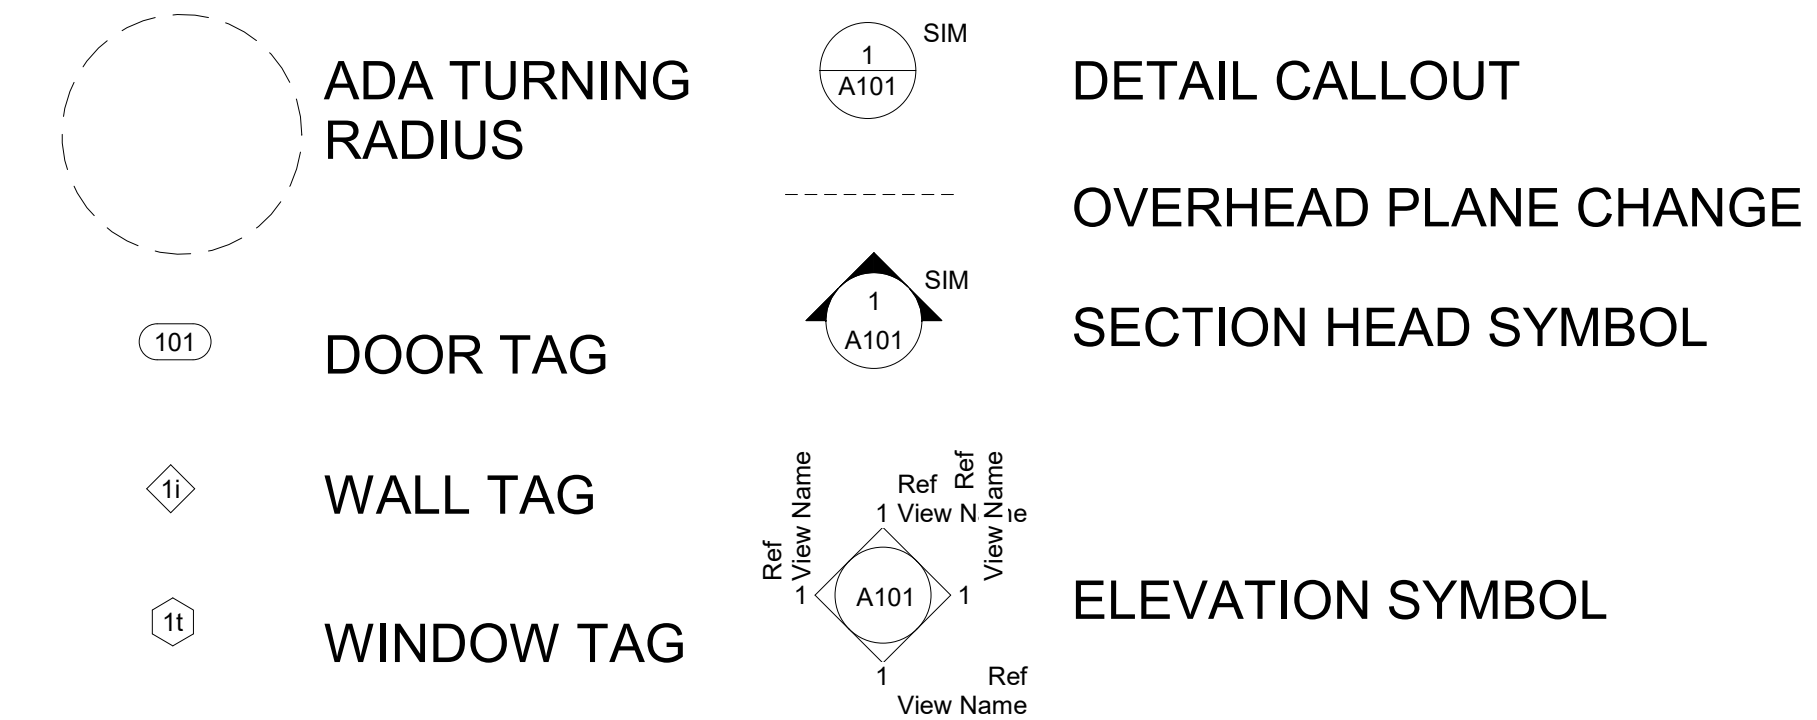

GENERAL NOTES

1. PROVIDE ONE FIRE EXTINGUISHER PER 3000 SQUARE FEET OF TENANT SPACE.
2. LIGHT GRAY THIN LINES INDICATE OVERHEAD PLANES.
3. ALL RESTROOMS MUST MEET ADA CODE.
4. ALL RESTROOM FIXTURES SHOULD BE MOUNTED ACCORDING TO MOUNTING HEIGHT STANDARDS LISTED ON SHEET G-02. IF FIXTURE DOES NOT HAVE A MENTIONED MOUNTING HEIGHT, IT SHOULD BE MOUNTED ACCORDING TO ADA REQUIREMENTS.
5. ALL PARTITION TYPE DETAILS CAN BE FOUND ON DETAIL SHEET ID-8.3.
6. DOOR HARDWARD AND DOOR SCHEDULE LOCATED ON SHEET ID-8.7.
7. ALL EXIT DOORS MUST OPEN OUT IN WAY OF EXITING THE BUILDING.
8. VERIFY ALL STRUCTUAL, MECHANICAL, AND ELECTRICAL REQUIREMENTS AND COORDINATE REQUIRED CHANGES WITH ARCHITECT PRIOR TO CONSTRUCTION.

KSU
ID

Kylie Arett

Kylie Arett
ID 645
Spring Semester
kkarett@ksu.edu

The Origins Wellness Center
4TH & PIERRE ST. MANHATTAN,
KS. 66502

Description	Date


Partition
Measurements

Date Issue Date
Drawn by
Checked by

ID-1.2

Scale As indicated

4/28/2021 2:35:23 PM

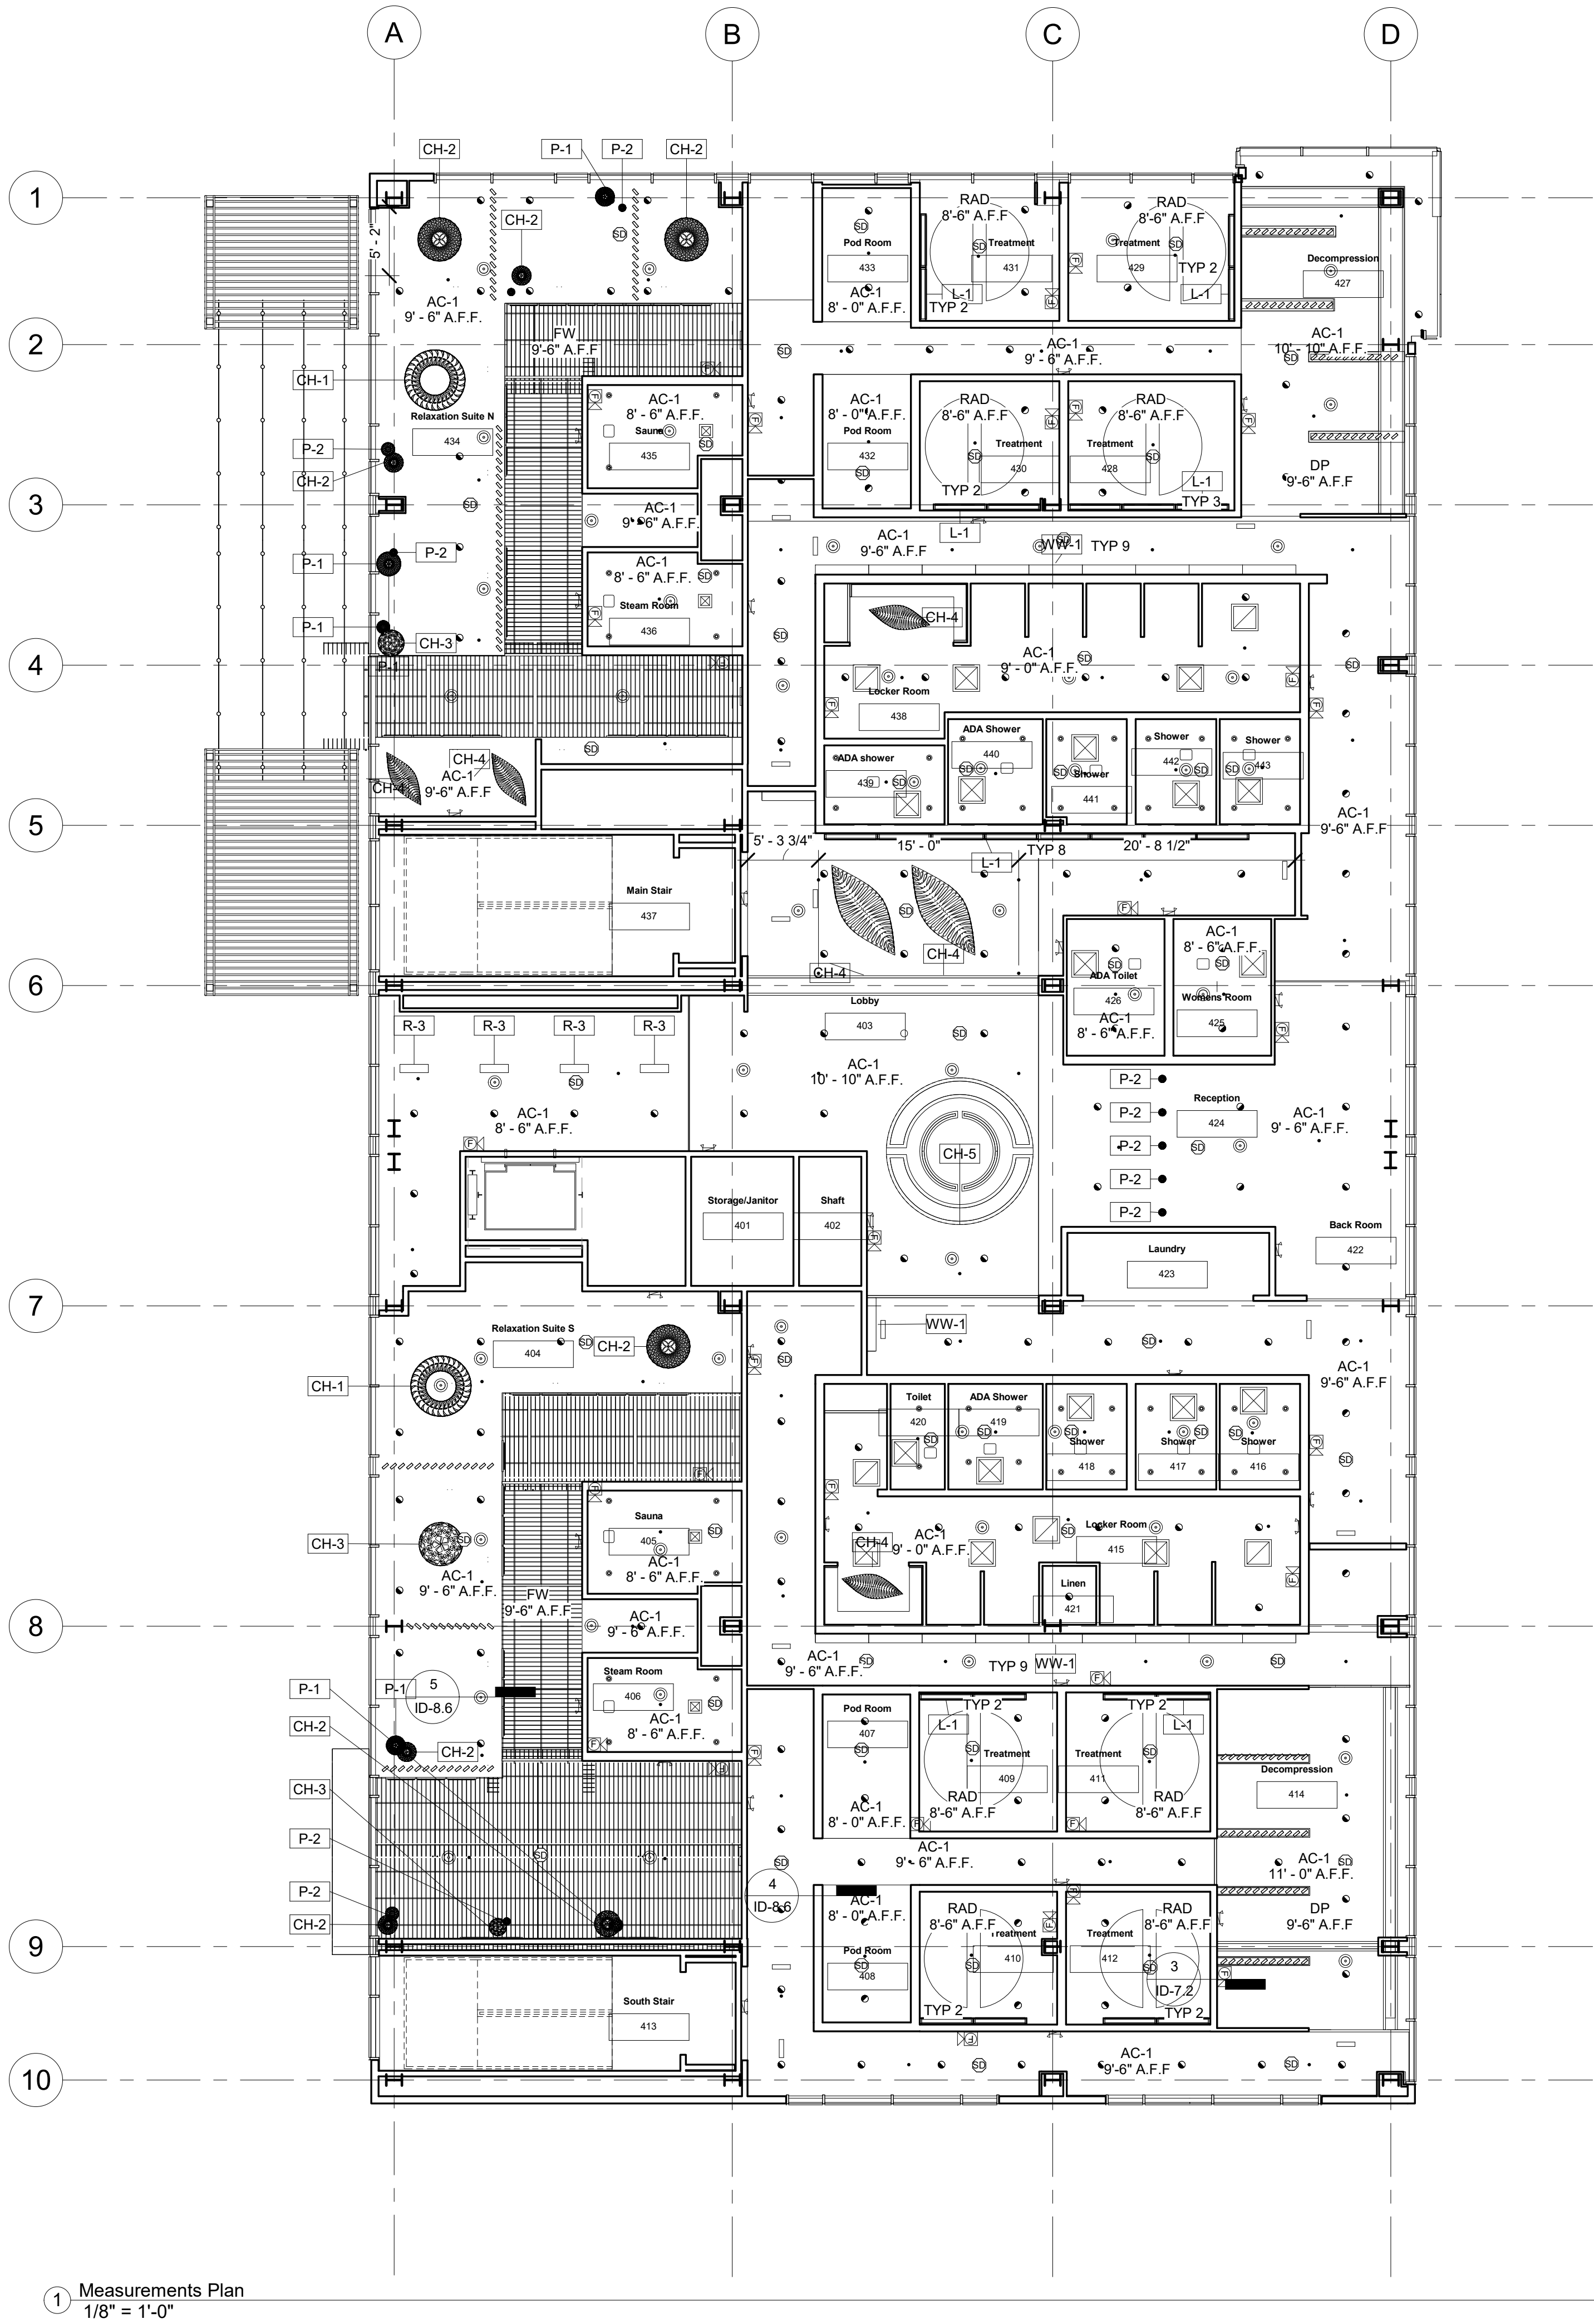

1 Measurements Plan
1/8" = 1'-0"

SYMBOLS

SM-1		SMOKE DETECTOR	P-1		KOURA PENDANT
SP-1		SPRINKLER	P-2		HINAKI PENDANT
E-1		EMERGENCY STROBE LIGHT	P-3		SY305 PENDANT
E-2		EMERGENCY EXIT LIGHT	CH-1		MARU CHANDELIER
E-3		EMERGENCY ENUNCIATOR	CH-2		KINA CHANDELIER
SV-1		SUPPLY VENT	CH-3		CORAL CHANDELIER
RV-1		RETURN VENT	CH-4		NAVICULA CHANDELIER
DV-1		DIFFUSER VENT W/ BLUETOOTH SPEAKER	R-1		FINIRE PRIME 3"
S-1		SPEAKER	R-2		STREAM DOT 4"
WW-1		WALL WASH LIGHT	R-3		LIGHTOLIER ALCYON LED

Lighting Fixture Schedule				
Count	Type Mark	Manufacturer	Description	Dimming
2	CH-1	David Trubridge	Pendant in bamboo plywood. Can be made in a large range of colours	Yes
8	CH-2	David Trubridge	Pendant in bamboo plywood. Can be made in a large range of colours. Lamp is not supplied	Yes
3	CH-3	David Trubridge	Pendant in bamboo plywood. Can be made in a large range of colours. Lamp is not supplied	Yes
6	CH-4	David Trubridge	Pendant in bamboo plywood with LED light source. Can be made in a large range of colours	Yes
1	CH-5	Bocci Lighting	Custom Chandelier	
25	L-1	Tech Lighting	MERGE™ 3.0 Recessed Linear System	Yes
5	P-1	David Trubridge	Pendant in bamboo plywood. Can be made in a large range of colours. Lamp is not supplied	Yes
11	P-2	David Trubridge	Pendant in bamboo plywood. Can be made in a large range of colours. Lamp is not supplied	Yes
38	R-1	Lutron Electronics Co., Inc	Finire Prime LED Round Recessed Downlight	
160	R-2	Prudential Lighting	Round Dot Recessed Lighting	
4	R-3	Lightolier	Please Load Accompanying Type Catalog (.txt)	
20	WW-1	FocalPoint	Wall Wash	

GENERAL NOTES

- CEILING IS ACOUSTIBUILT PANEL UNLESS OTHERWISE NOTED.
- UNLESS OTHERWISE STATED, CEILING MOUNTED FIXTURE LOCATIONS ARE EVENLY SPACED ACCORDING TO TYPICAL DIMENSIONS SPECIFIED.
- PROVIDE EMERGENCY LIGHTING, STROBES, ALARMS, FIRE PULLS AND SMOKE DETECTORS AS REQUIRED BY CODE.
- ALL LIGHTS IN HALLS AND OTHER AREAS ARE R-2 UNLESS OTHERWISE NOTED.
- ALL LIGHTS IN WET AREAS ARE FINIRE PRIME, R-1, UNLESS OTHERWISE NOTED
- CUSTOM CHANDELIER TO BE MANUFACTURED IN PARTNER WITH BOCCI LIGHTING CO.
- P-3 IS ONLY LOCATED IN THE RELAXATION SUITES BETWEEN THE FELTWORKS BLADES.
- ALL CEILINGS IN SHOWER ROOMS ARE AC-1 9'-0" A.F.F

KSU
ID

Kylie Arett

Kylie Arett
ID 645
Spring Semester
kkarett@ksu.edu

The Origins Wellness Center
4TH & PIERRE ST. MANHATTAN,
KS. 66502


Description	Date

Reflected
Ceiling Plan

Date Issue Date
Drawn by
Checked by

ID-2.1

Scale As indicated

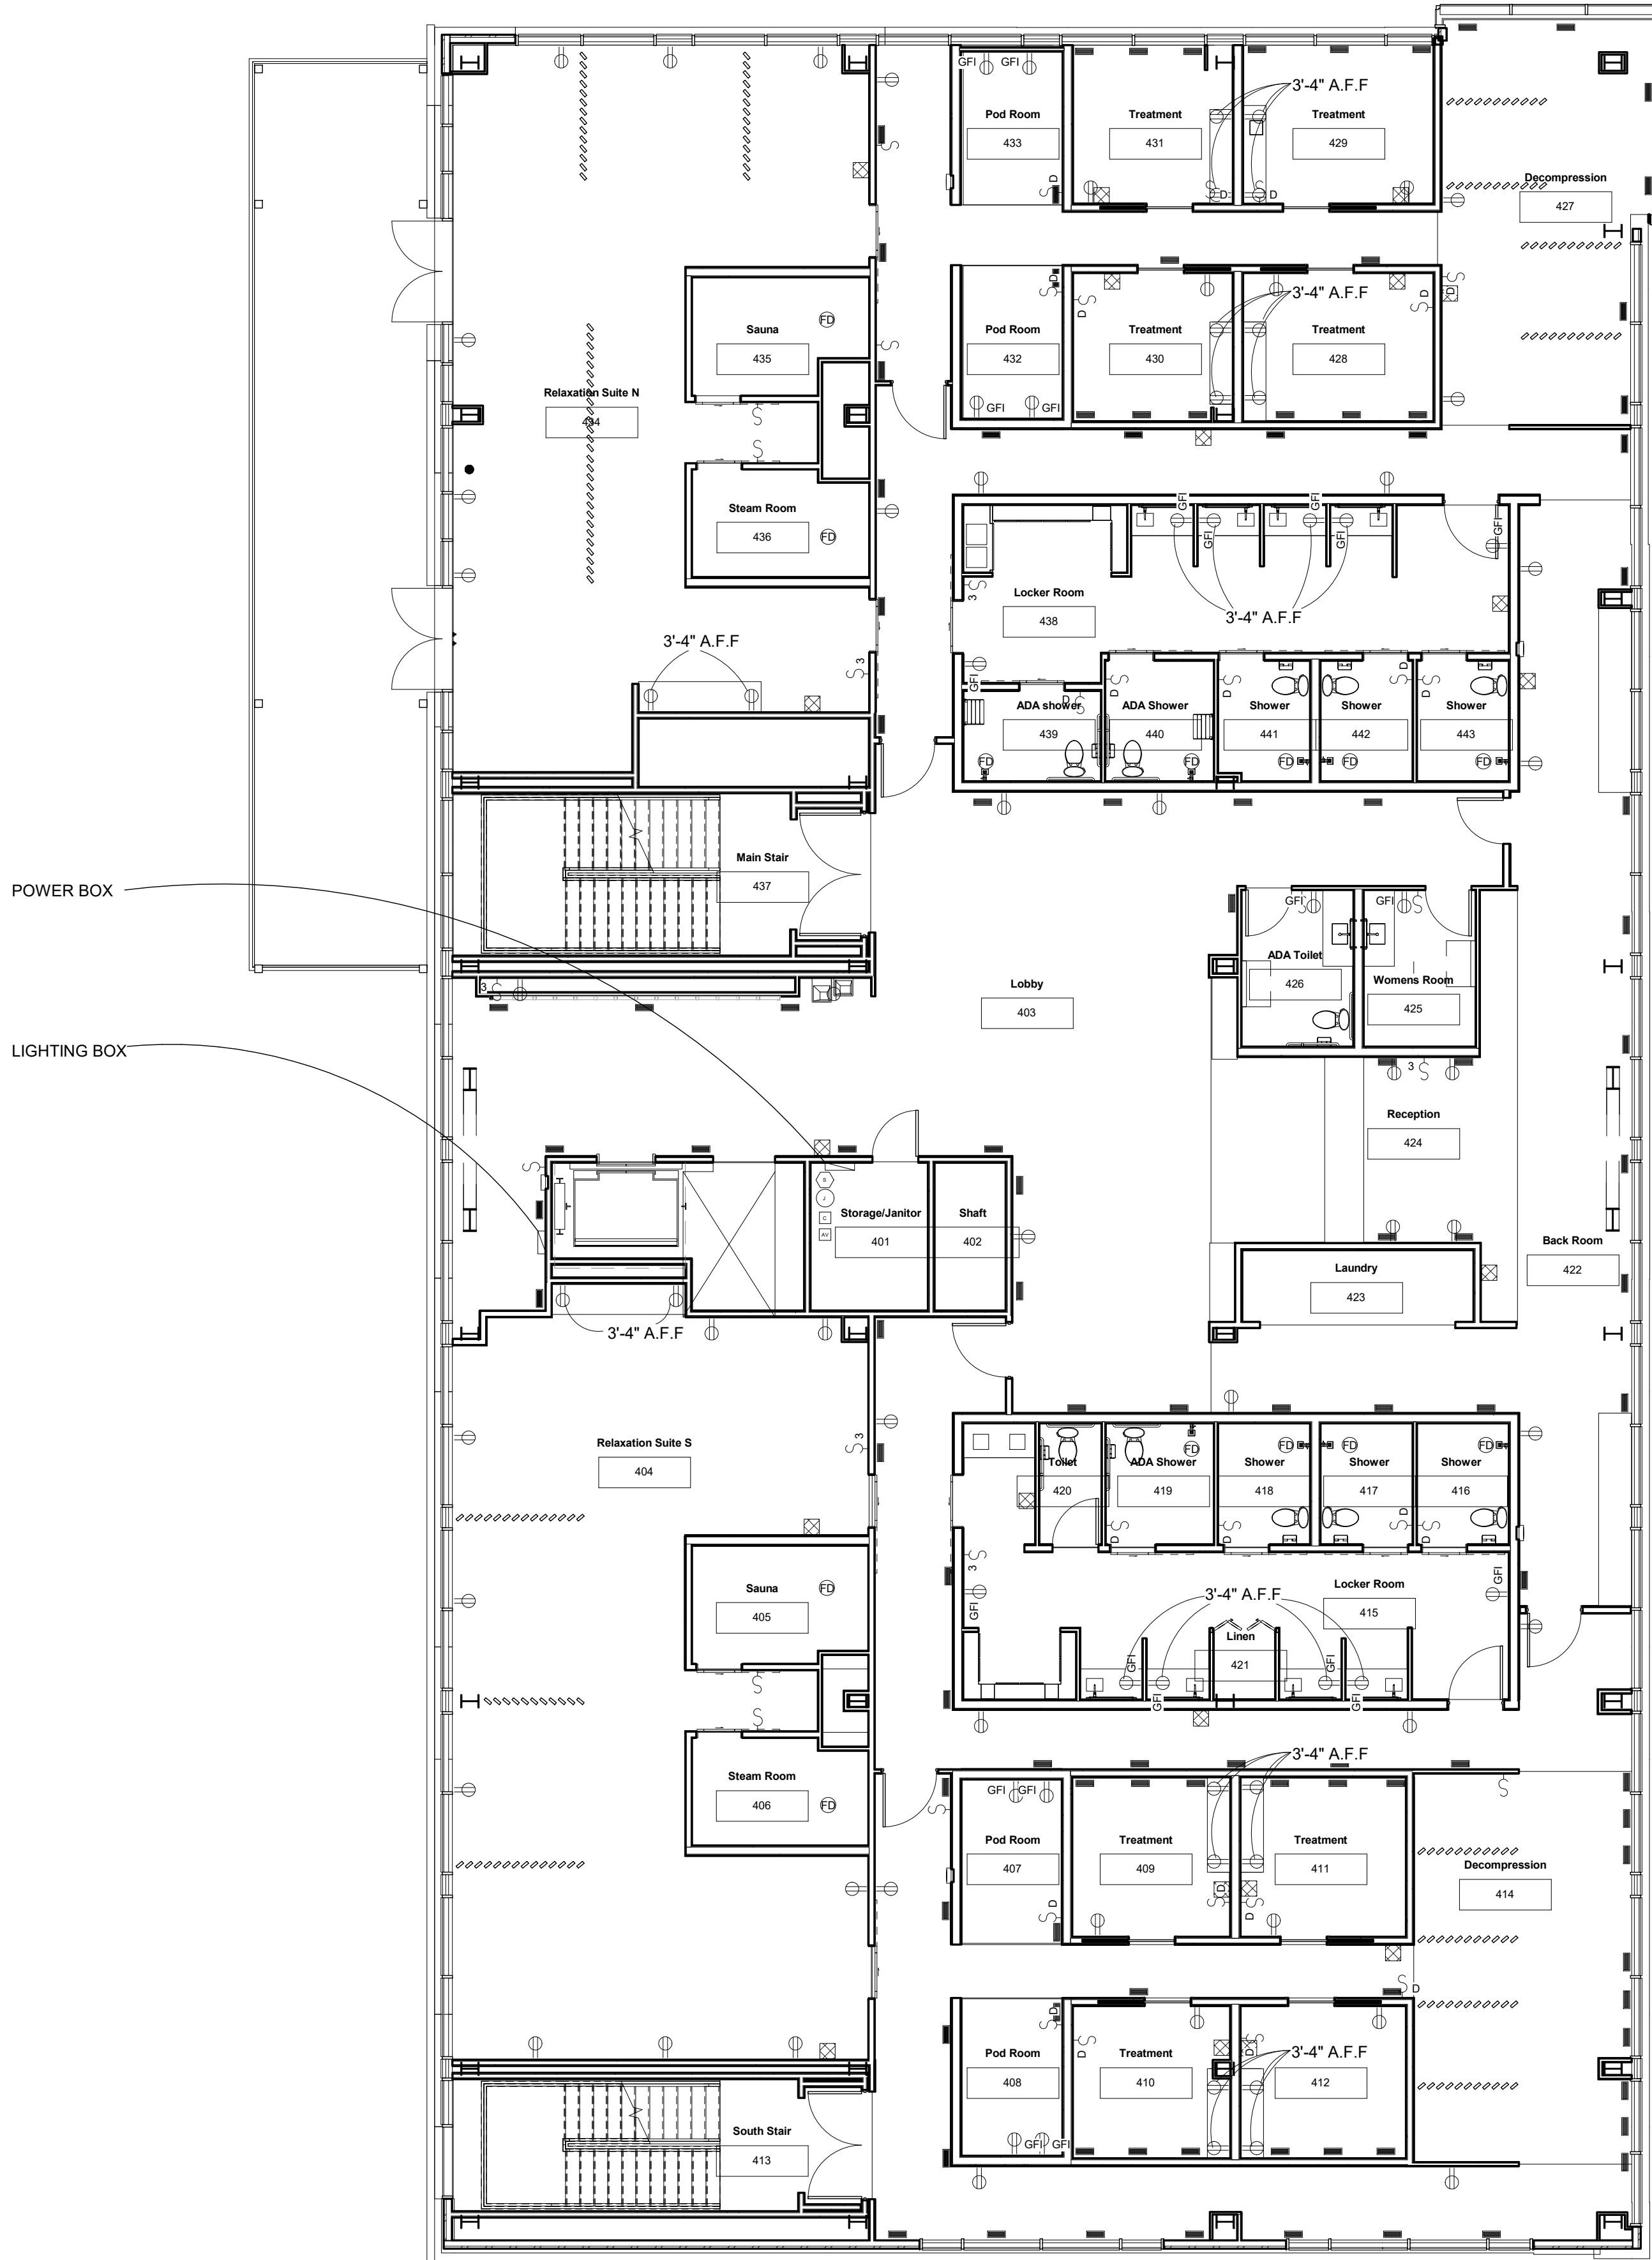

SYMBOLS

	SINGLE FLOOR OUTLET		SINGLE SWITCH
	SINGLE OUTLET		DOUBLE SWITCH
	TRIPLEX OUTLET		LIGHTING PANEL
	SECTION HEAD SYMBOL		POWER PANEL
	SECURITY		JUNCTION BOX
	LIGHTING CONTROL		AUDIO VISUAL CONTROL

GENERAL NOTES

1. ALL OUTLETS TO BE INSTALLED AT 18" A.F.F. UNLESS SPECIFIED OTHERWISE
2. CONTRACTOR TO ENSURE ALL OUTLETS WITHIN 6'-0" OF PLUMBING FIXTURES ARE GROUND FAULT INTERPRETTER (GFI)
3. CONTRACTOR TO REMOVE ALL CABLE TO BACK EXISTING ELECTRICAL PANEL SOURCE AND PATCH WITH DRYWALL AND PAINT
4. ELECTRICAL PANEL RELOCATED TO MECHANICAL ROOM
5. WALL MOUNTED OUTLETS TO BE SUPPORTED BY STUD AT ALL LOCATIONS


SHEET NOTES

1. ADA COMPLIANT AUTOMATIC DOOR OPENER 110 V OUTLET REQUIRED WIRELESS MODEL 4300 BATTERY BACKUP
2. CARD READERS: COORDINATE WITH SECURITY VENDOR



Description	Date

Date	Issue Date
Drawn by	
Checked by	
ID-3.1	
Scale	As indicated

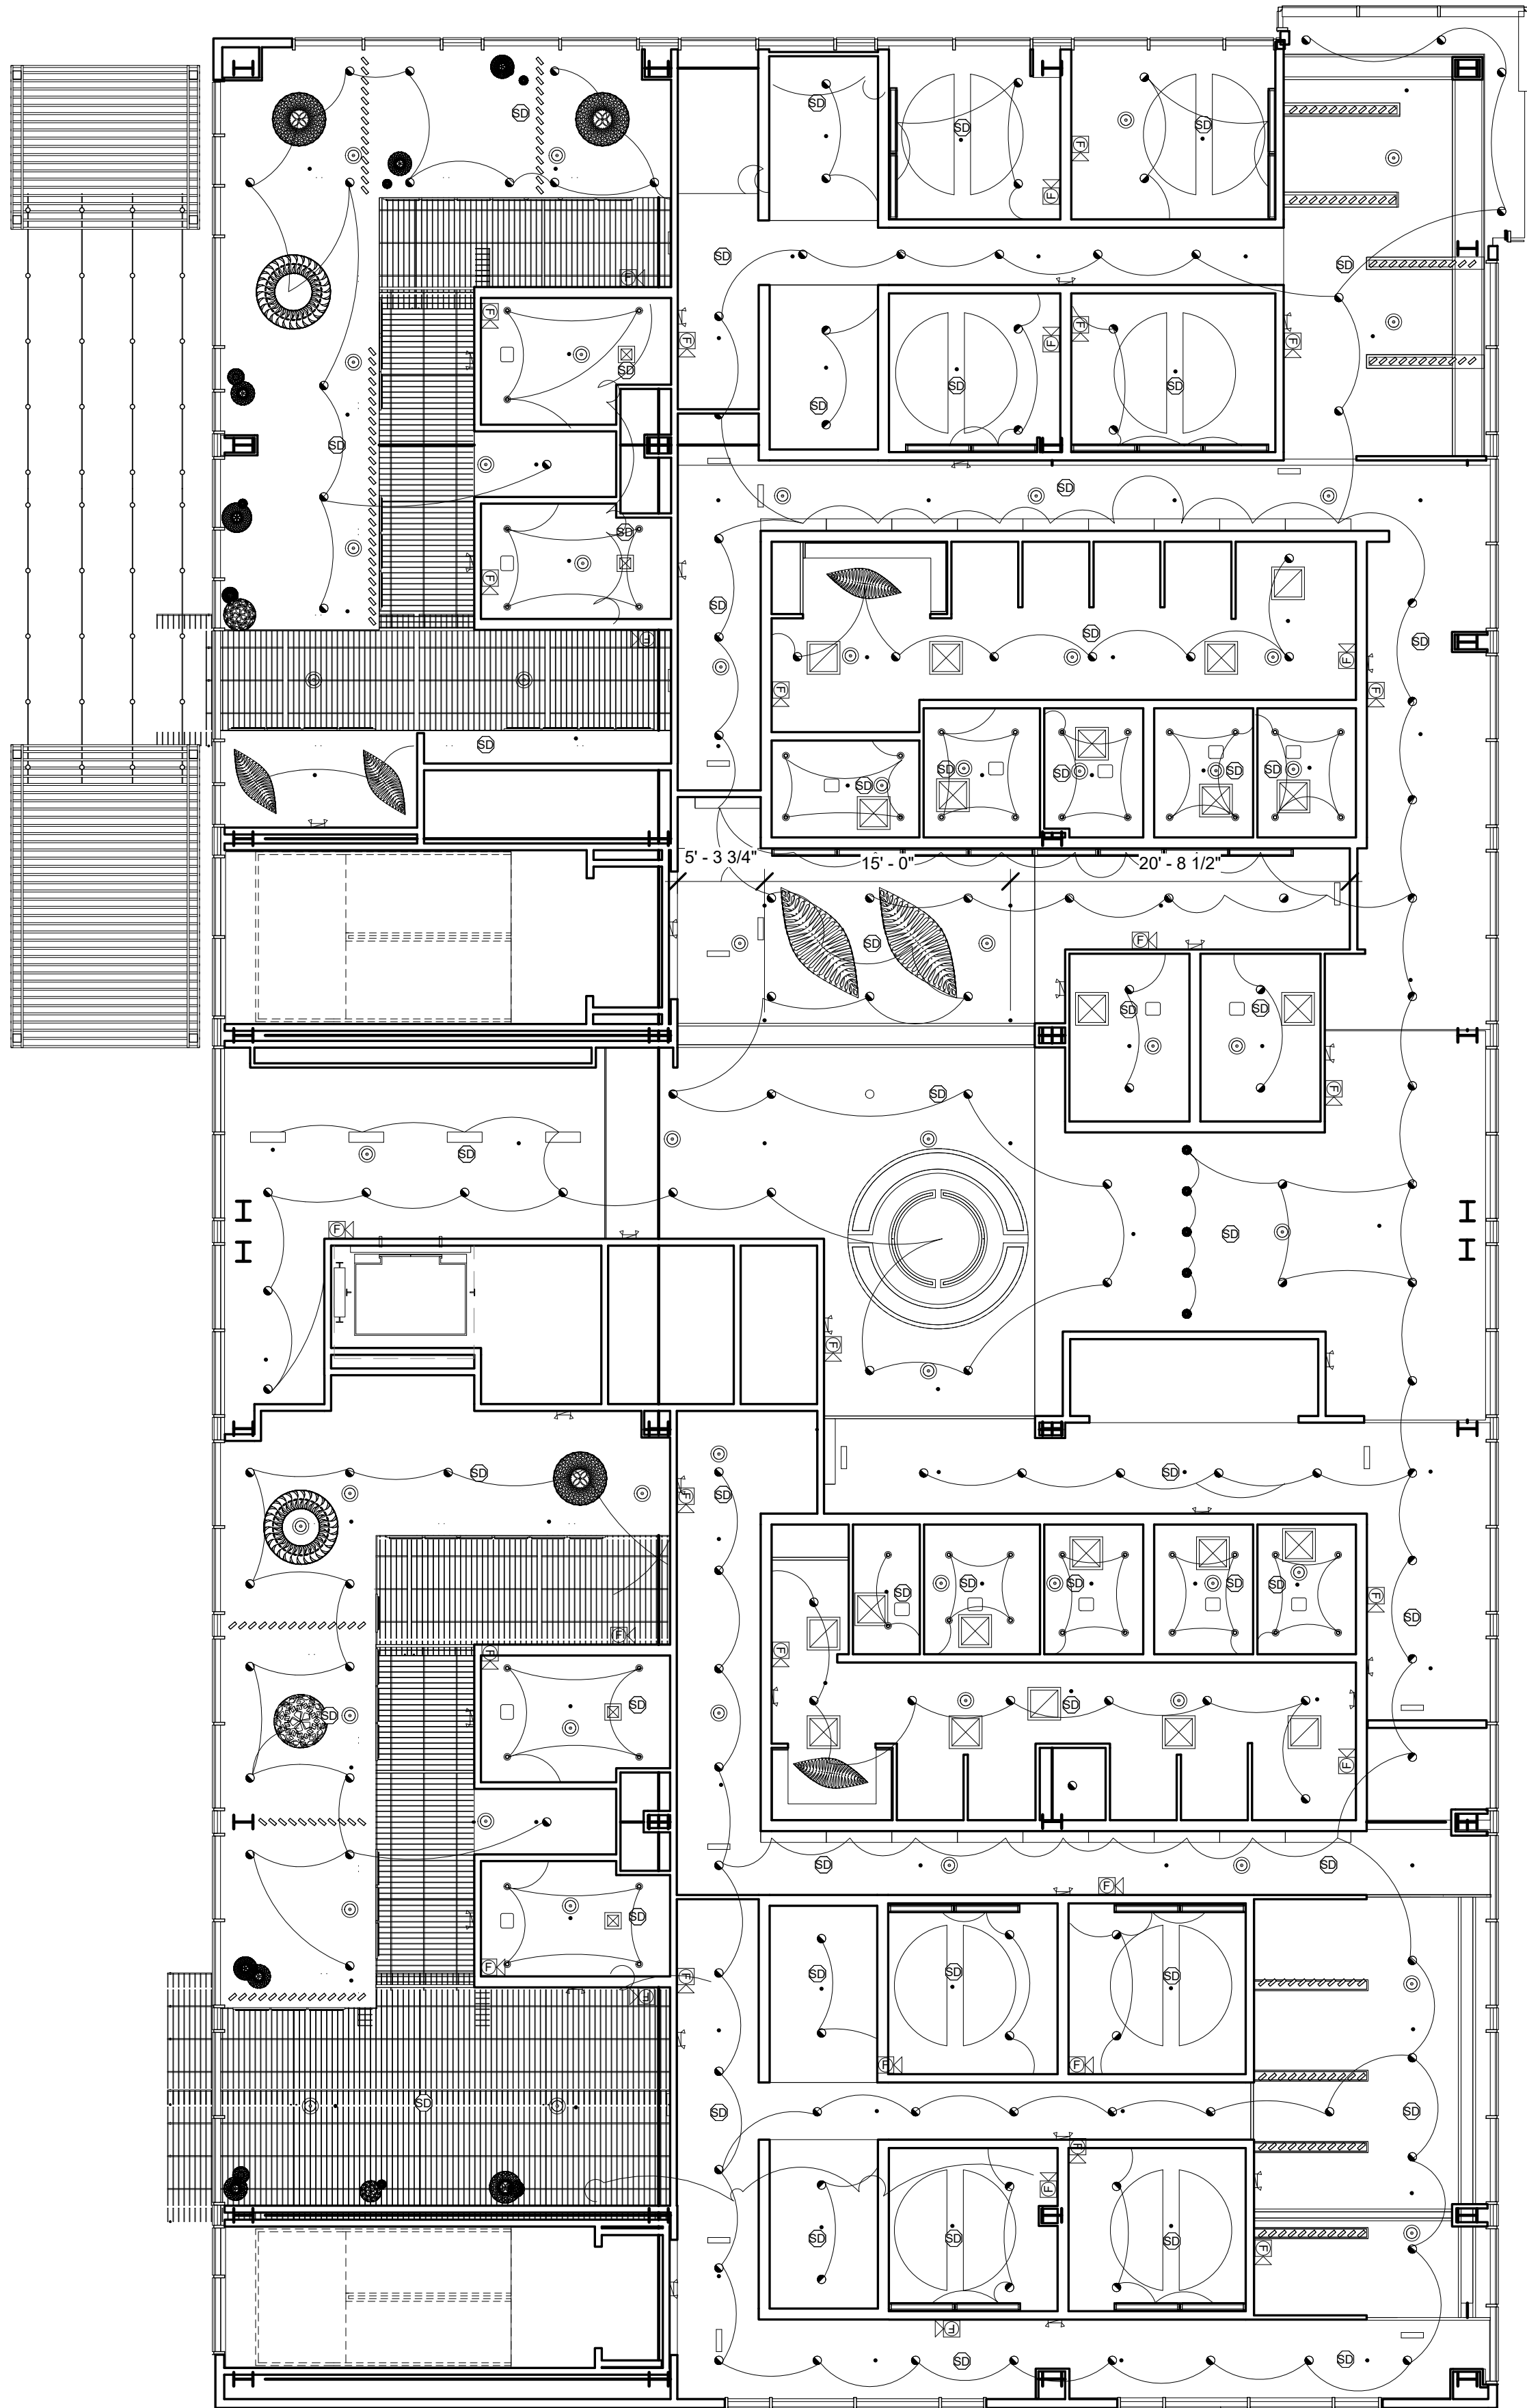

1 Switching Plan
1/8" = 1'-0"

SYMBOLS

SM-1	○	SMOKE DETECTOR	P-1	●	KOURA PENDANT
SP-1	•	SPRINKLER	P-2	●	HINAKI PENDANT
E-1	▬	EMERGENCY STROBE LIGHT	P-3	○	SY305 PENDANT
E-2	⊕	EMERGENCY EXIT LIGHT	CH-1	⊗	MARU CHANDELIER
E-3	⊞	EMERGENCY ENUNCIATOR	CH-2	⊗	KINA CHANDELIER
SV-1	⊠	SUPPLY VENT	CH-3	⊗	CORAL CHANDELIER
RV-1	⊠	RETURN VENT	CH-4	⊗	NAVICULA CHANDELIER
DV-1	□	DIFFUSER VENT W/ BLUETOOTH SPEAKER	R-1	●	FINIRE PRIME 3"
S-1	⊙	SPEAKER	R-2	●	STREAM DOT 4"
WW-1	▬	WALL WASH LIGHT	R-3	▬	LIGHTOLIER ALCYON LED

GENERAL NOTES

1. CEILING IS A FINISHED GYPSUM CEILING UNLESS OTHERWISE NOTED.
2. UNLESS OTHERWISE, CEILING MOUNTED FIXTURE LOCATIONS ARE EVENLY SPACED ACCORDING TO TYPICAL DIMENSIONS SPECIFIED.
3. PROVIDE EMERGENCY LIGHTING, STROBES, ALARMS, FIRE PULLS AND SMOKE DETECTORS AS REQUIRED BY CODE.
4. SWITCHING INDICATES CONTROL OF SPECIFIC FIXTURES, NOT CIRCUITING, SEE ELECTRICAL DRAWINGS FOR CIRCUITING. NON TYPICAL SWITCHING ONLY IS INDICATED.
5. ALL THE LIGHTS IN THE LOBBY ARE R-1 UNLESS NOTED OTHERWISE.

KSU
ID

Kylie Arett

Kylie Arett
ID 645
Spring Semester
karet@ksu.edu

The Origins Wellness Center
4TH & PIERRE ST. MANHATTAN,
KS. 66502

Description	Date

Switching
Plan

Date	Issue Date
Drawn by	
Checked by	

ID-3.2

Scale	As indicated
-------	--------------



FLOOR FINISHES LEGEND

- F1

TYPE: CASALGRANDE PORCELAIN
MANUFACTURER: ASM CasalGrande
STYLE: 24" X 12"
COLOR: BIANCO CASSERO
- F2

TYPE: CORK TILE
MANUFACTURER: VERSACORK
STYLE: PRE-FINISHED
COLOR: NATURAL WITH BLACK GROUT
- F3

TYPE: HARDWOOD
MANUFACTURER: ASM STILE
STYLE: PLANK
COLOR: ROVERE SMOKED DARK

WALL BASE

- B1

TYPE: WOOD
MANUFACTURER: BAYER BUILT
STYLE: FARMHOUSE TRADITIONAL MODERN
COLOR & ITEM #: ASIAN NIGHT #R4160HEIGHT: 4"

WALL FINISHES

- P1

TYPE: INTERIOR PAINT
MANUFACTURER: SHERWIN-WILLIAMS
LOCATOR #: 261-C1
COLOR: WHITETAIL SW 7103
- WT

TYPE: WALL TILE
MANUFACTURER: DAL TILE
STYLE: RETRO ROUNDS
COLOR: MATTE WHITE
- P2

TYPE: INTERIOR PAINT
MANUFACTURER: SHERWIN-WILLIAMS
LOCATOR #: 248-C1
COLOR: SHITAKE SW 9173
- CT

TYPE: CORK WALL TILE
MANUFACTURER: VERSACORK
STYLE: PRE-FINISHED
COLOR: MATTE WHITE
- P3

TYPE: INTERIOR PAINT
MANUFACTURER: PPG
LOCATOR #: PPG1028-4
COLOR: SMOKY SLATE
- WP

TYPE: WALL PAPER
MANUFACTURER: SCHUMACHER
COLOR: WILLOW LEAF

CEILING TYPE FINISHES

- AC1

TYPE: SEAMLESS ACOUSTIC CEILING
MANUFACTURER: ARMSTRONG
STYLE: ACOUSTIBUILT
THICKNESS: 7/8
PAINT: P-1
- RAD

TYPE: DROP CEILING PANELS
MANUFACTURER: ARMSTRONG
STYLE: OPTIMA RADIAL PANELS
THICKNESS: 6"
- FW

TYPE: FELTWORKS
MANUFACTURER: ARMSTRONG
STYLE: PEAKS & VALLEYS
THICKNESS: 6" X 6'-0"
- DP

TYPE: SWAGGED UPHOLSTERY
MANUFACTURER: KNOLL
STYLE: BEWITCHED
THICKNESS: 1"


GENERAL NOTES

- ALL FLOORING TO INSTALLED PER MANUFACTURER'S INSTALLATION INSTRUCTIONS
- ALL WALLS SHOULD BE PAINTED WITH P-1 UNLESS NOTED OTHERWISE
- ALL WALLS ARE TO HAVE B-1 WALL BASE UNLESS NOTED OTHERWISE
- ALL CEILINGS ARE AC1 UNLESS NOTED OTHERWISE
- ALL WALLCOVINGS TO BE INSTALLED PER MANUFACTURER'S INSTALLION INSTRUCTIONS
- CONTRACTOR TO PREPARE FLOORS TO RECIEVE NEW TILE AND HARDWOOD FLOORING
- CONTRACTOR TO PREPARE WALLS TO RECIEVE NEW PAINT AND MASONRY
- CHECK F.F.E SPECIFICATIONS PROVIDED BY DESIGNER.



Description	Date

Date	Issue Date
Drawn by	
Checked by	
ID-4.1	
Scale	As indicated

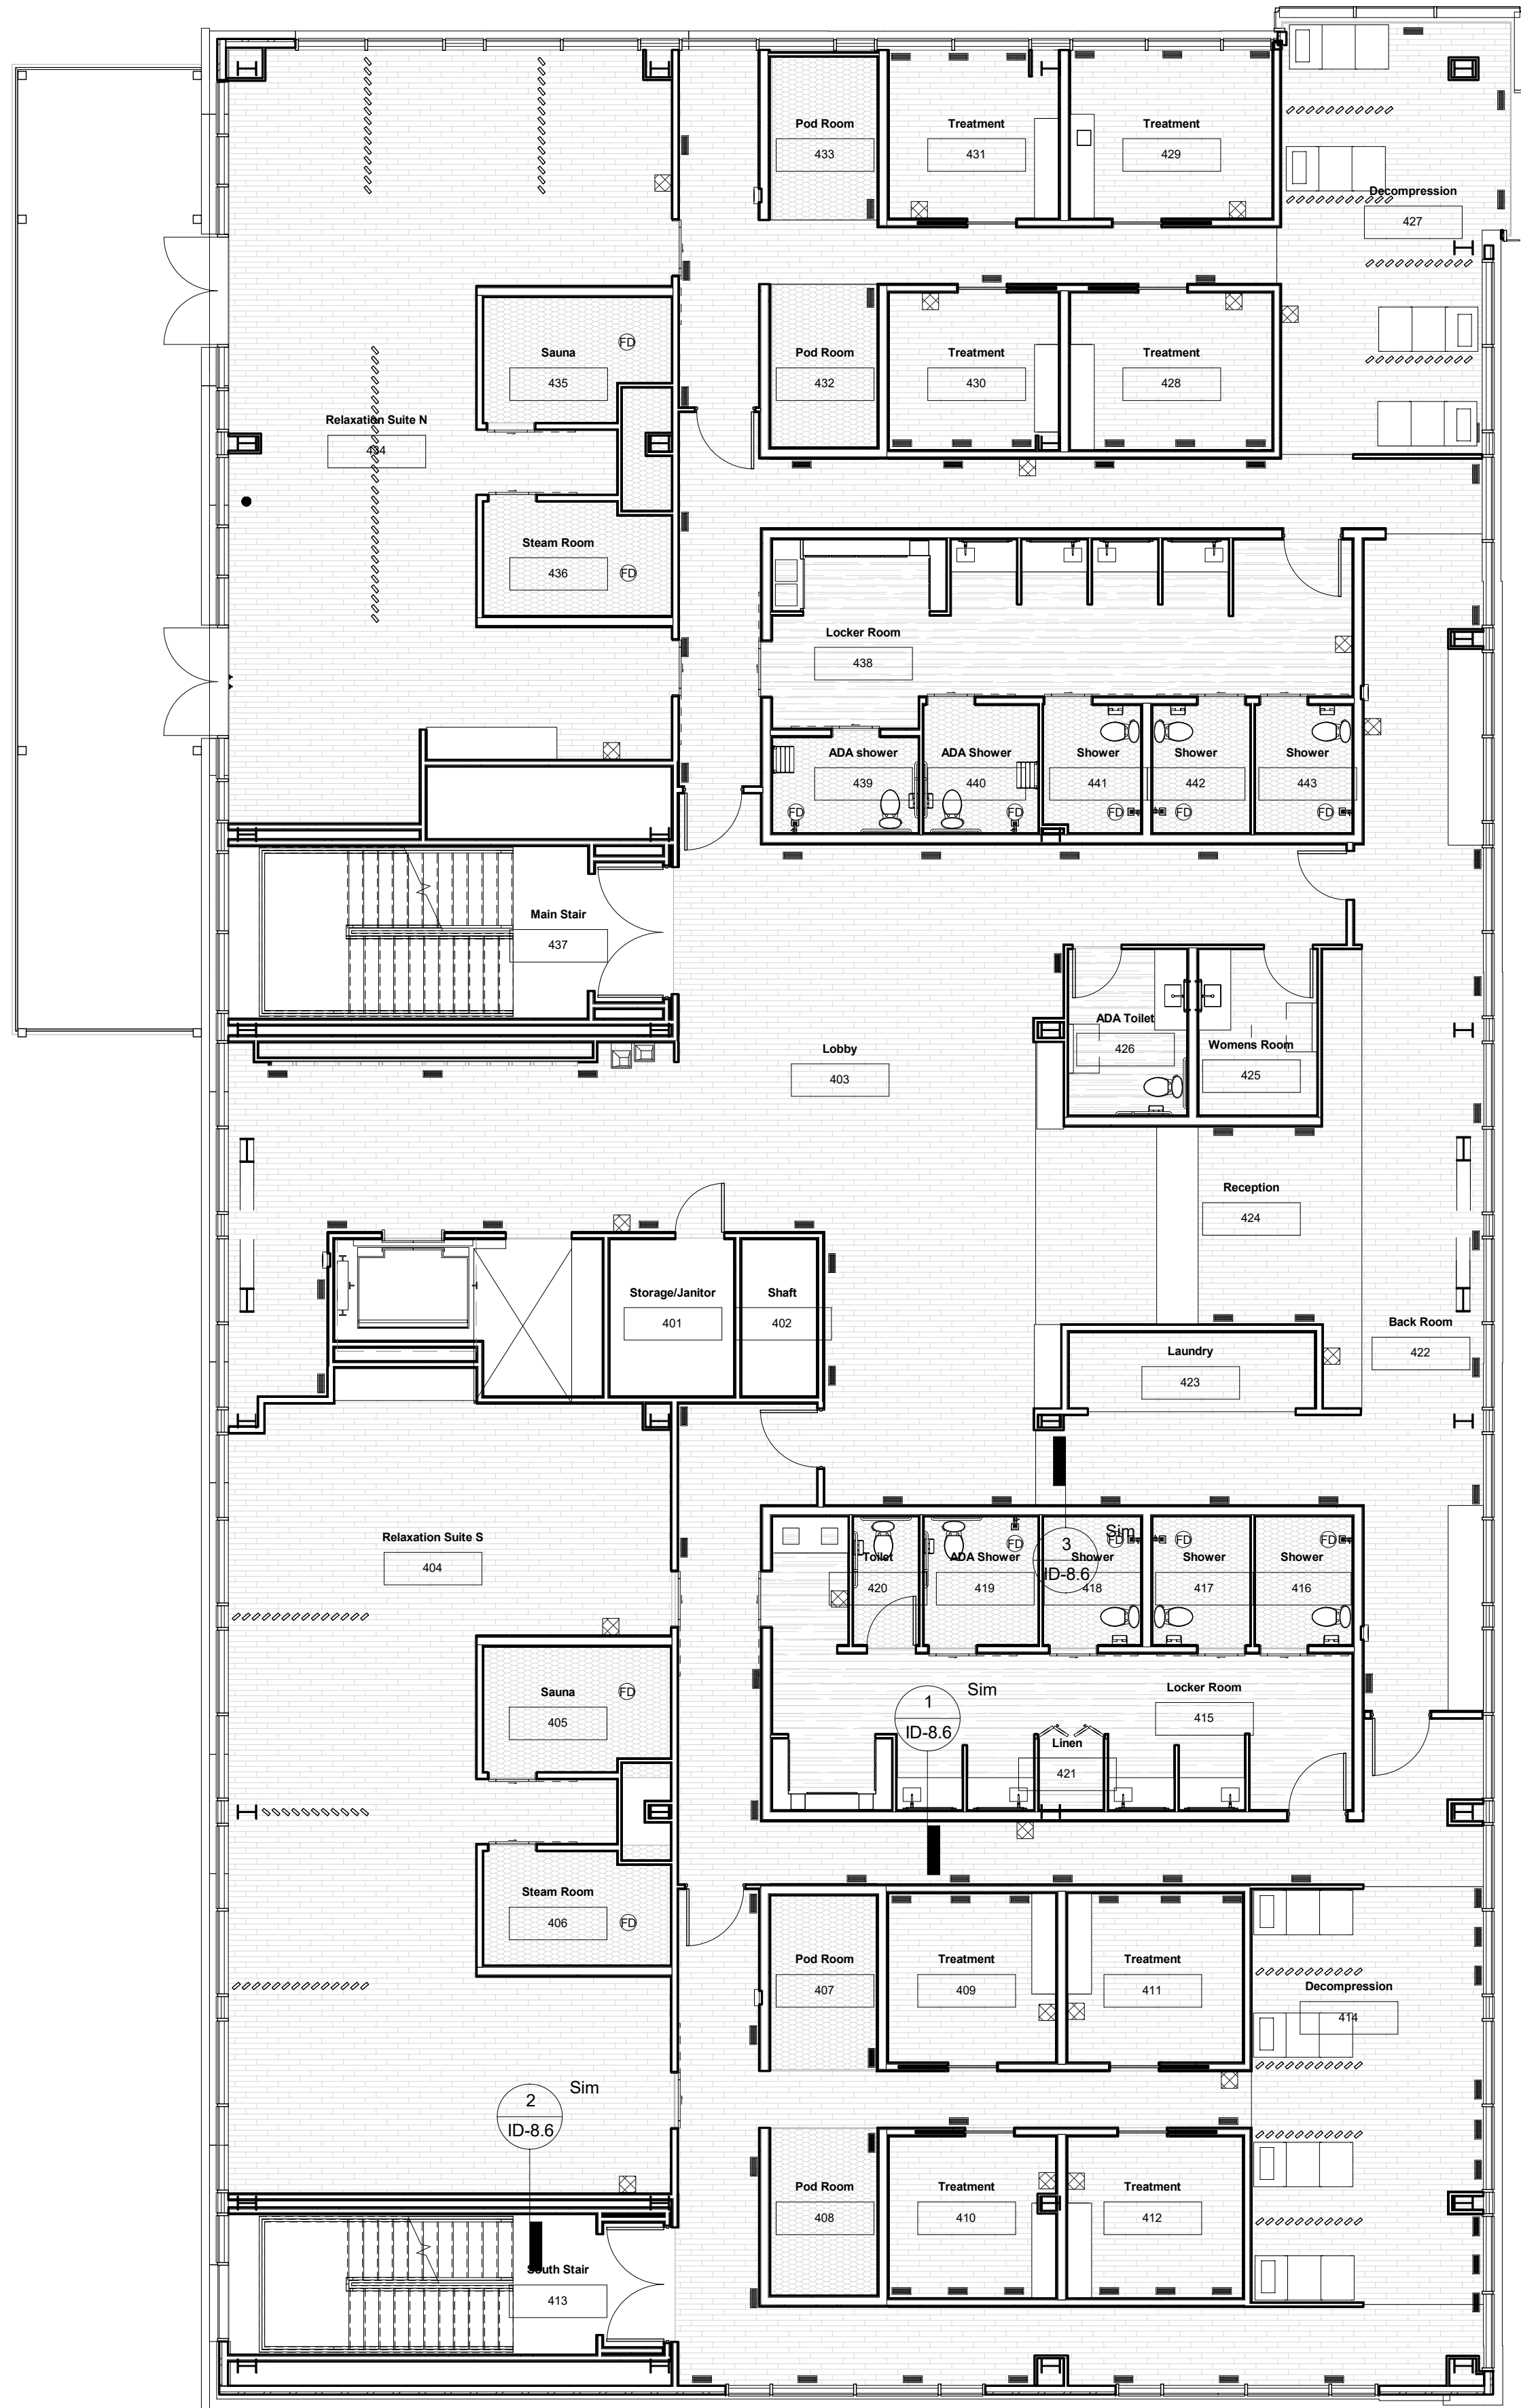

② Finish Plan 2
1/8" = 1'-0"



No.	Room	Floor	Base	Walls				Ceiling	Ceiling Ht.	Notes
				N	S	E	W			
403	Lobby	F3	B1	CK	W1	W1	W1	AC1	10'-10"	
424	Reception	F3	B1	W1	W1	W	W	AC1	9'-6"	
426	Bathroom	F1	B1	W1	W1	W1	W1	AC1	8'-6"	
423	Laundry	F3	B1	W1	W1	W1	W1	AC1	9'-0"	
415	Locker Room S	F1	B1	W5	WT	W2	W2	AC1	9'-0"	Wall tiles on the walls behind vanities
438	Locker Room N	F1	B1	WT	W4	W2	W2	AC1	9'-0"	Wall tiles on the walls behind vanities
439	Shower	F2	B1	CK	CK	W1	CK	AC1	8'-6"	On south and north walls only half is cork tile, the other half is gyp with w1
440	shower	F2	B1	CK	CK	CK	W1	AC1	8'-6"	On south and north walls only half is cork tile, the other half is gyp with w1
441	Shower	F2	B1	W1	CK	CK	CK	AC1	8'-6"	On East and West walls, only half is cork tile, the other half is gyp with W1
442	Shower	F2	B1	W1	CK	CK	CK	AC1	8'-6"	On East and West walls, only half is cork tile, the other half is gyp with W1
443	Shower	F2	B1	W1	CK	CK	CK	AC1	8'-6"	On East and West walls, only half is cork tile, the other half is gyp with W1
416	Shower	F2	B1	CK	W1	CK	CK	AC1	8'-6"	On East and West walls, only half is cork tile, the other half is gyp with W1
417	Shower	F2	B1	CK	W1	CK	CK	AC1	8'-6"	On East and West walls, only half is cork tile, the other half is gyp with W1
418	Shower	F2	B1	CK	W1	CK	CK	AC1	8'-6"	On East and West walls, only half is cork tile, the other half is gyp with W1
419	Shower	F2	B1	CK	CK	CK	W1	AC1	8'-6"	On south and north walls only half is cork tile, the other half is gyp with w1
425	Mother's Room	F3	B1	W2	W2	W2	W2	AC1	8'-6"	
404	Relaxation Suite S	F3	B1	W4	CT	W2	W	AC1 & FW	9'-6"	
434	Relaxation Suite N	F3	B1	W4	CT	W2	W	AC1 & FW	9'-6"	
405&435	Sauna	F2	CT	CT	CT	CT	CT	AC1	8'-6"	
406&436	Steam	F2	CT	CT	CT	CT	CT	AC1	8'-6"	
407	Sensory Deprivation	F2	B1	W3	W3	W3	W3	AC1	8'-0"	
408	Sensory Deprivation	F2	B1	W3	W3	W3	W3	AC1	8'-0"	
432	Sensory Deprivation	F2	B1	W3	W3	W3	W3	AC1	8'-0"	
433	Sensory Deprivation	F2	B1	W3	W3	W3	W3	AC1	8'-0"	
409	Treatment room	F3	B1	CK	W3	W3	W3	AC1&RAD	9'-6"	
410	Treatment room	F3	B1	W3	CK	W3	W3	AC1&RAD	9'-6"	
411	Treatment room	F3	B1	CK	W3	W3	W3	AC1&RAD	9'-6"	
412	Treatment room	F3	B1	W3	CK	W3	W3	AC1&RAD	9'-6"	
428	Treatment room	F3	B1	W3	CK	W3	W3	AC1&RAD	9'-6"	
429	Treatment room	F3	B1	W	W3	CT	W3	AC1&RAD	9'-6"	
430	Treatment room	F3	B1	W3	CK	W3	W3	AC1&RAD	9'-6"	
431	Treatment room	F3	B1	W	W3	W3	CT	AC1&RAD	9'-6"	
414	Decompression Zone	F3	B1	W3	W3	W3	w	AC1&DP	11'-0"	
427	Decompression Zone	F3	B1	W3	W3	W3	w	AC1&DP	11'-0"	

- Key
- W4 = Wall paper
 - WT = porcelain wall Tile
 - F3 = Wood
 - F1 = porcelain tile
 - F2 & CT = cork
 - AC1 = ACOUSTIBUILT
 - FW = feltworks
 - RAD = radial drop
 - W1 = Light wall paint
 - B1 = Laminate Base
 - W = Window
 - W2 = Neutral wall paint
 - W3 = Green wall paint
 - DP = Swagged Drapery

KSU
ID

Kylie Arett

Kylie Arett
ID 645
Spring Semester
kkarett@ksu.edu

The Origins Wellness Center
4TH & PIERRE ST. MANHATTAN,
KS. 66502


Description	Date

Finish
Schedule

Date Issue Date
Drawn by
Checked by

ID-4.2

 Scale As indicated









KEY

- ## FURNITURE NOTES


- ## GENERAL NOTES

-
- 1/8" = 1'-0"

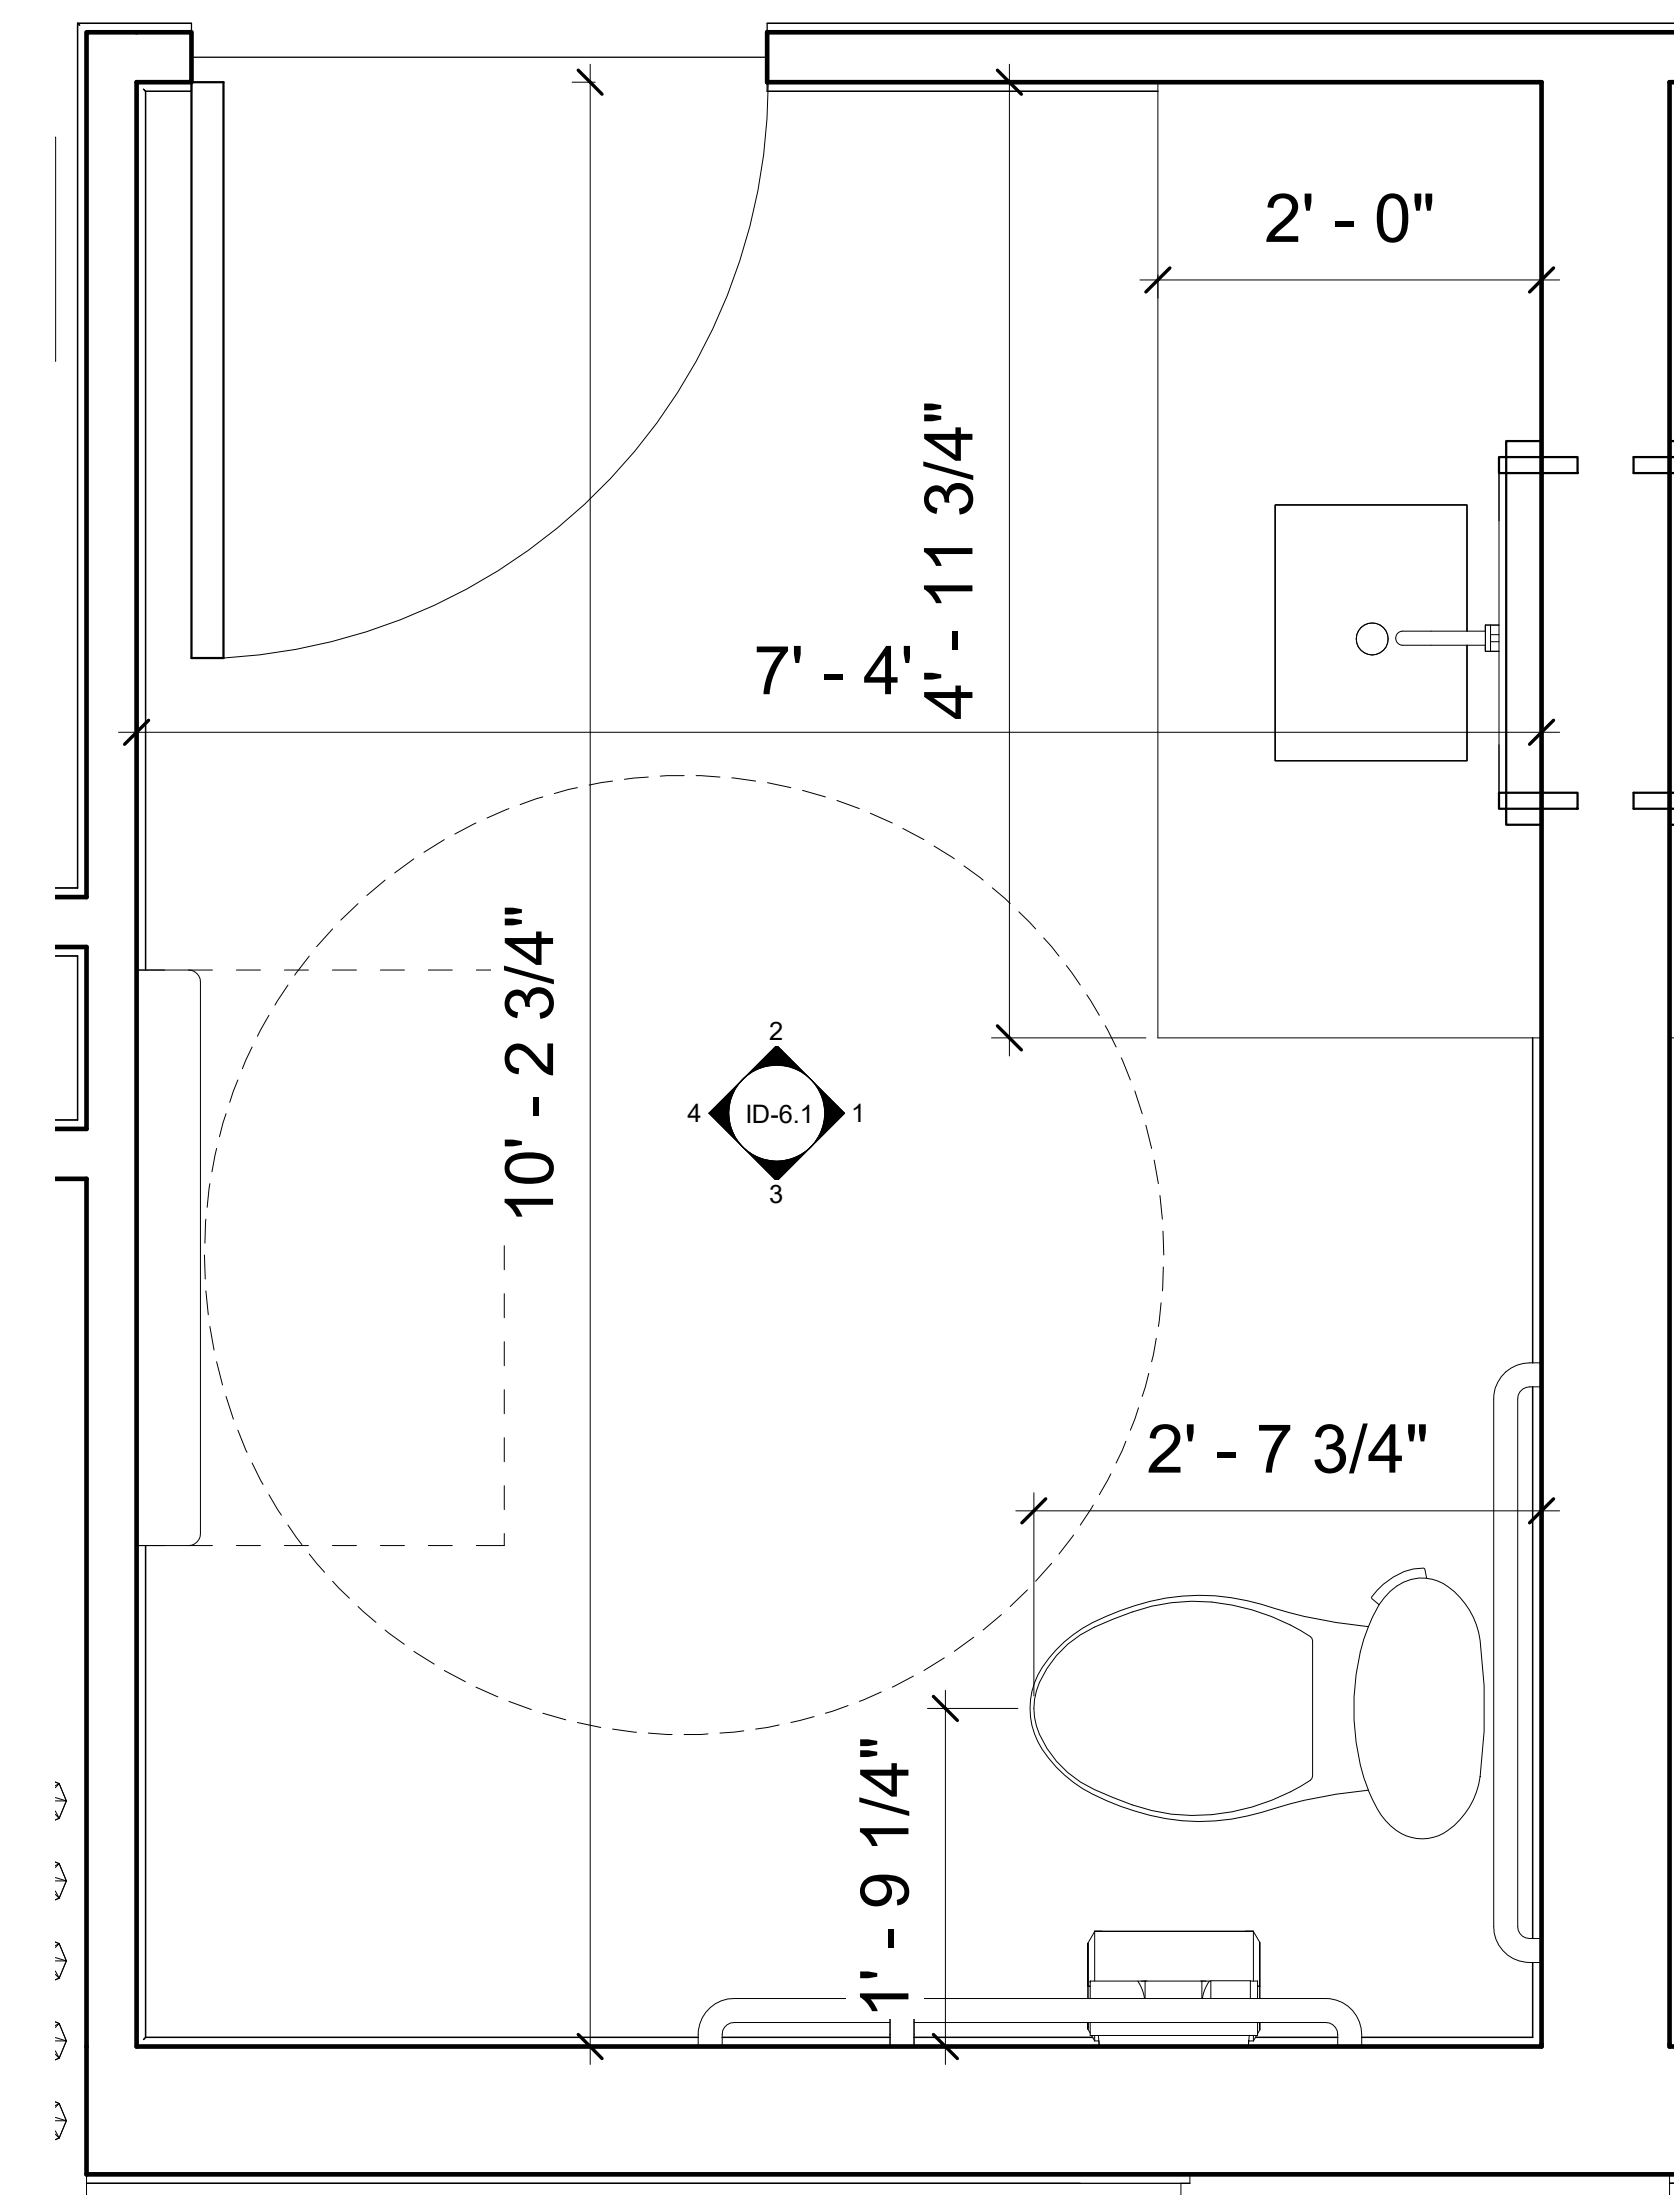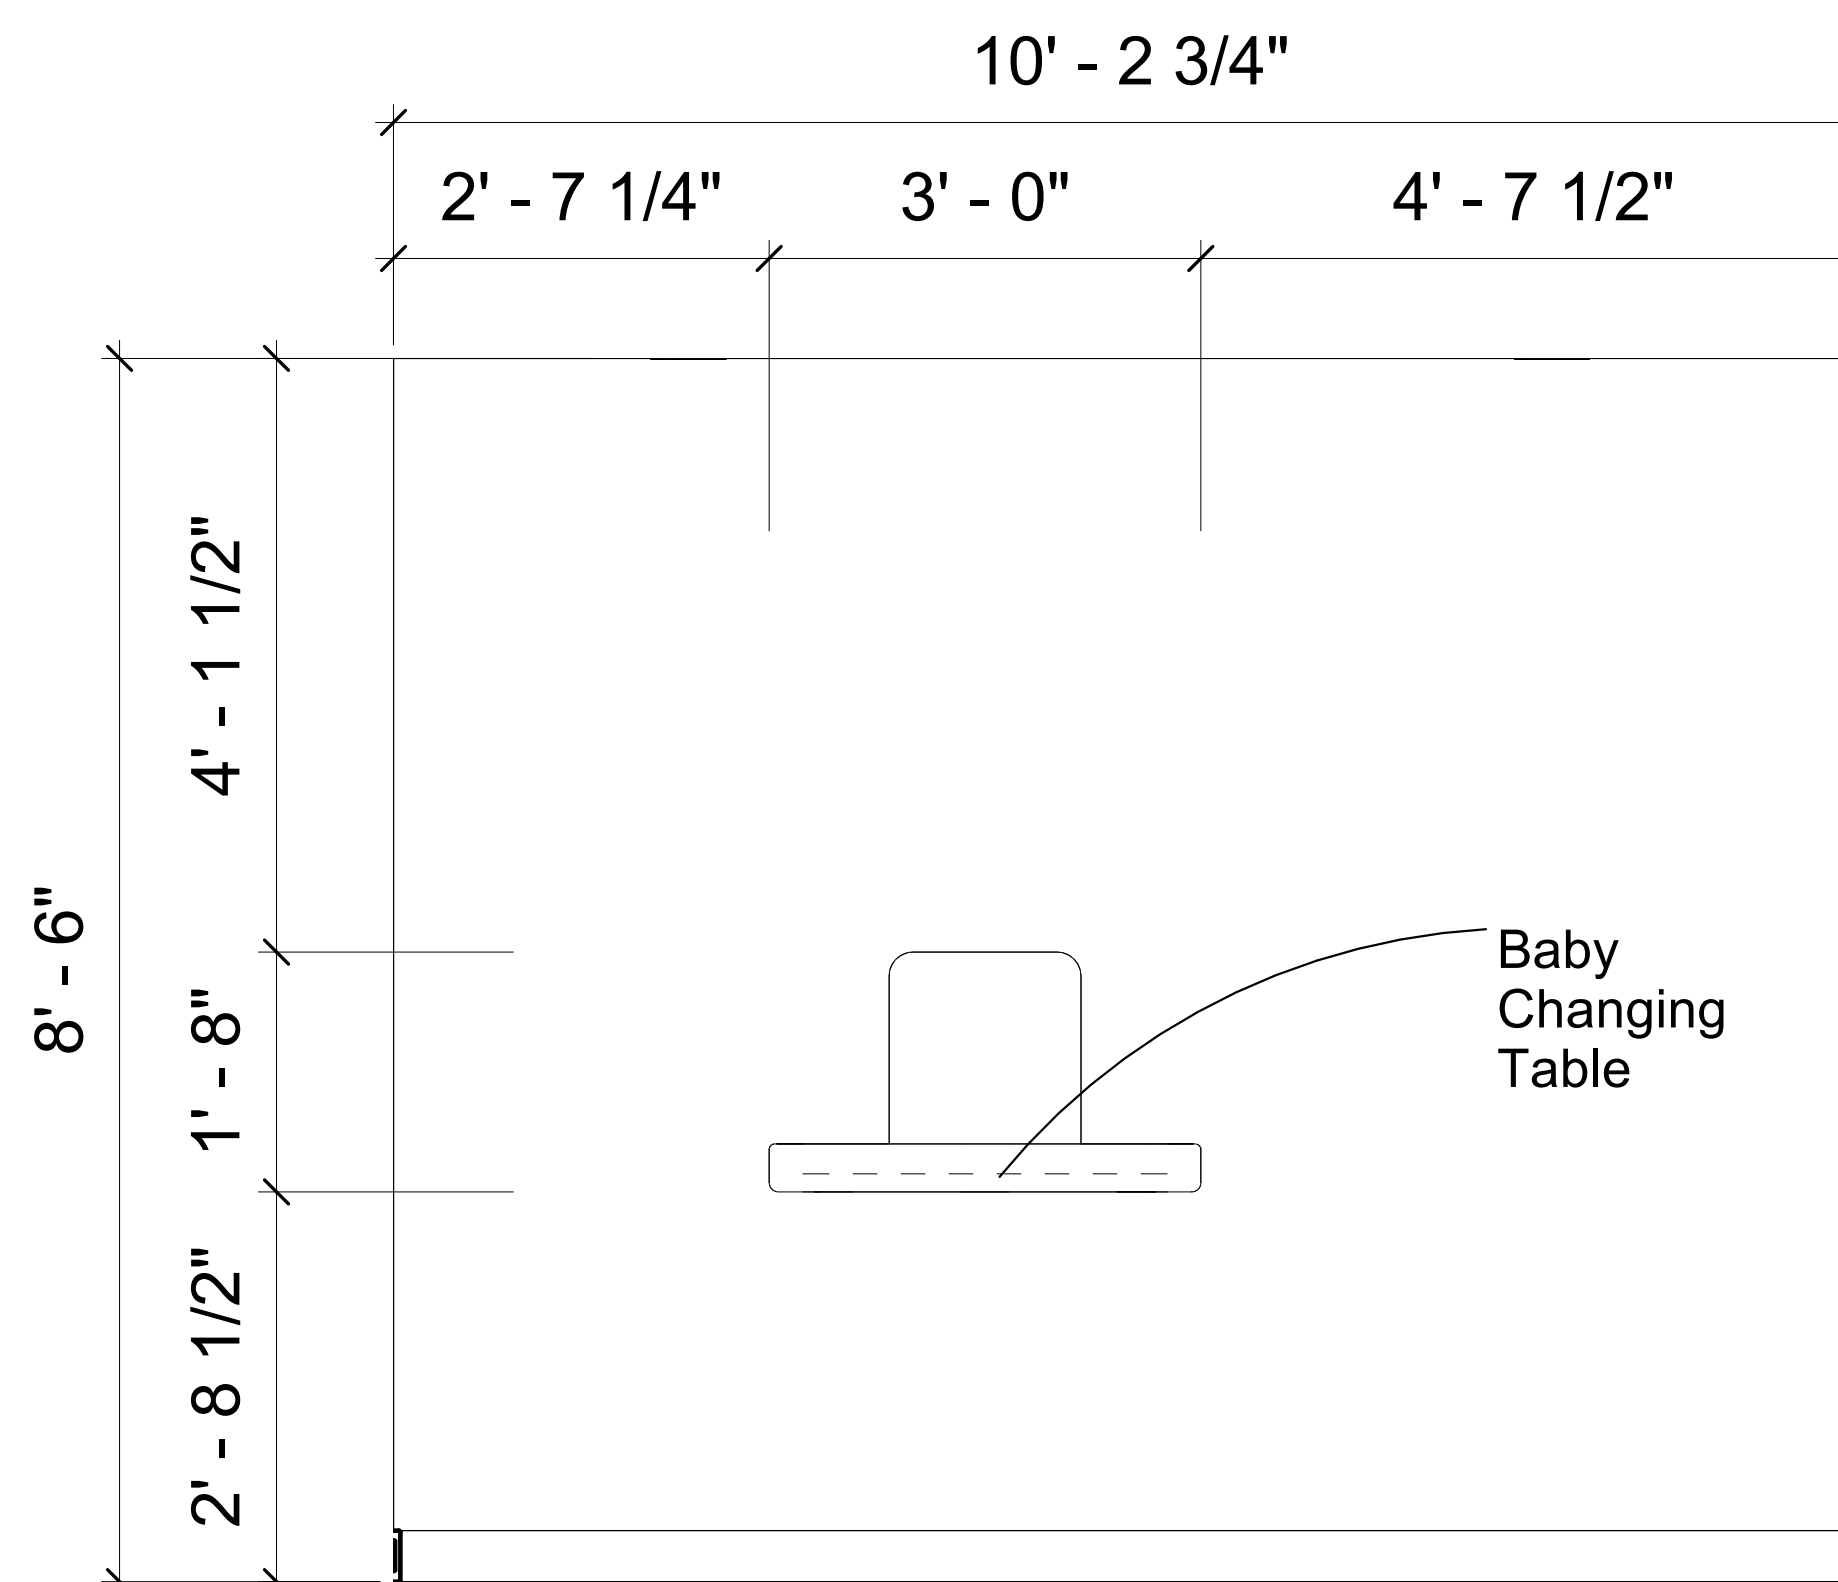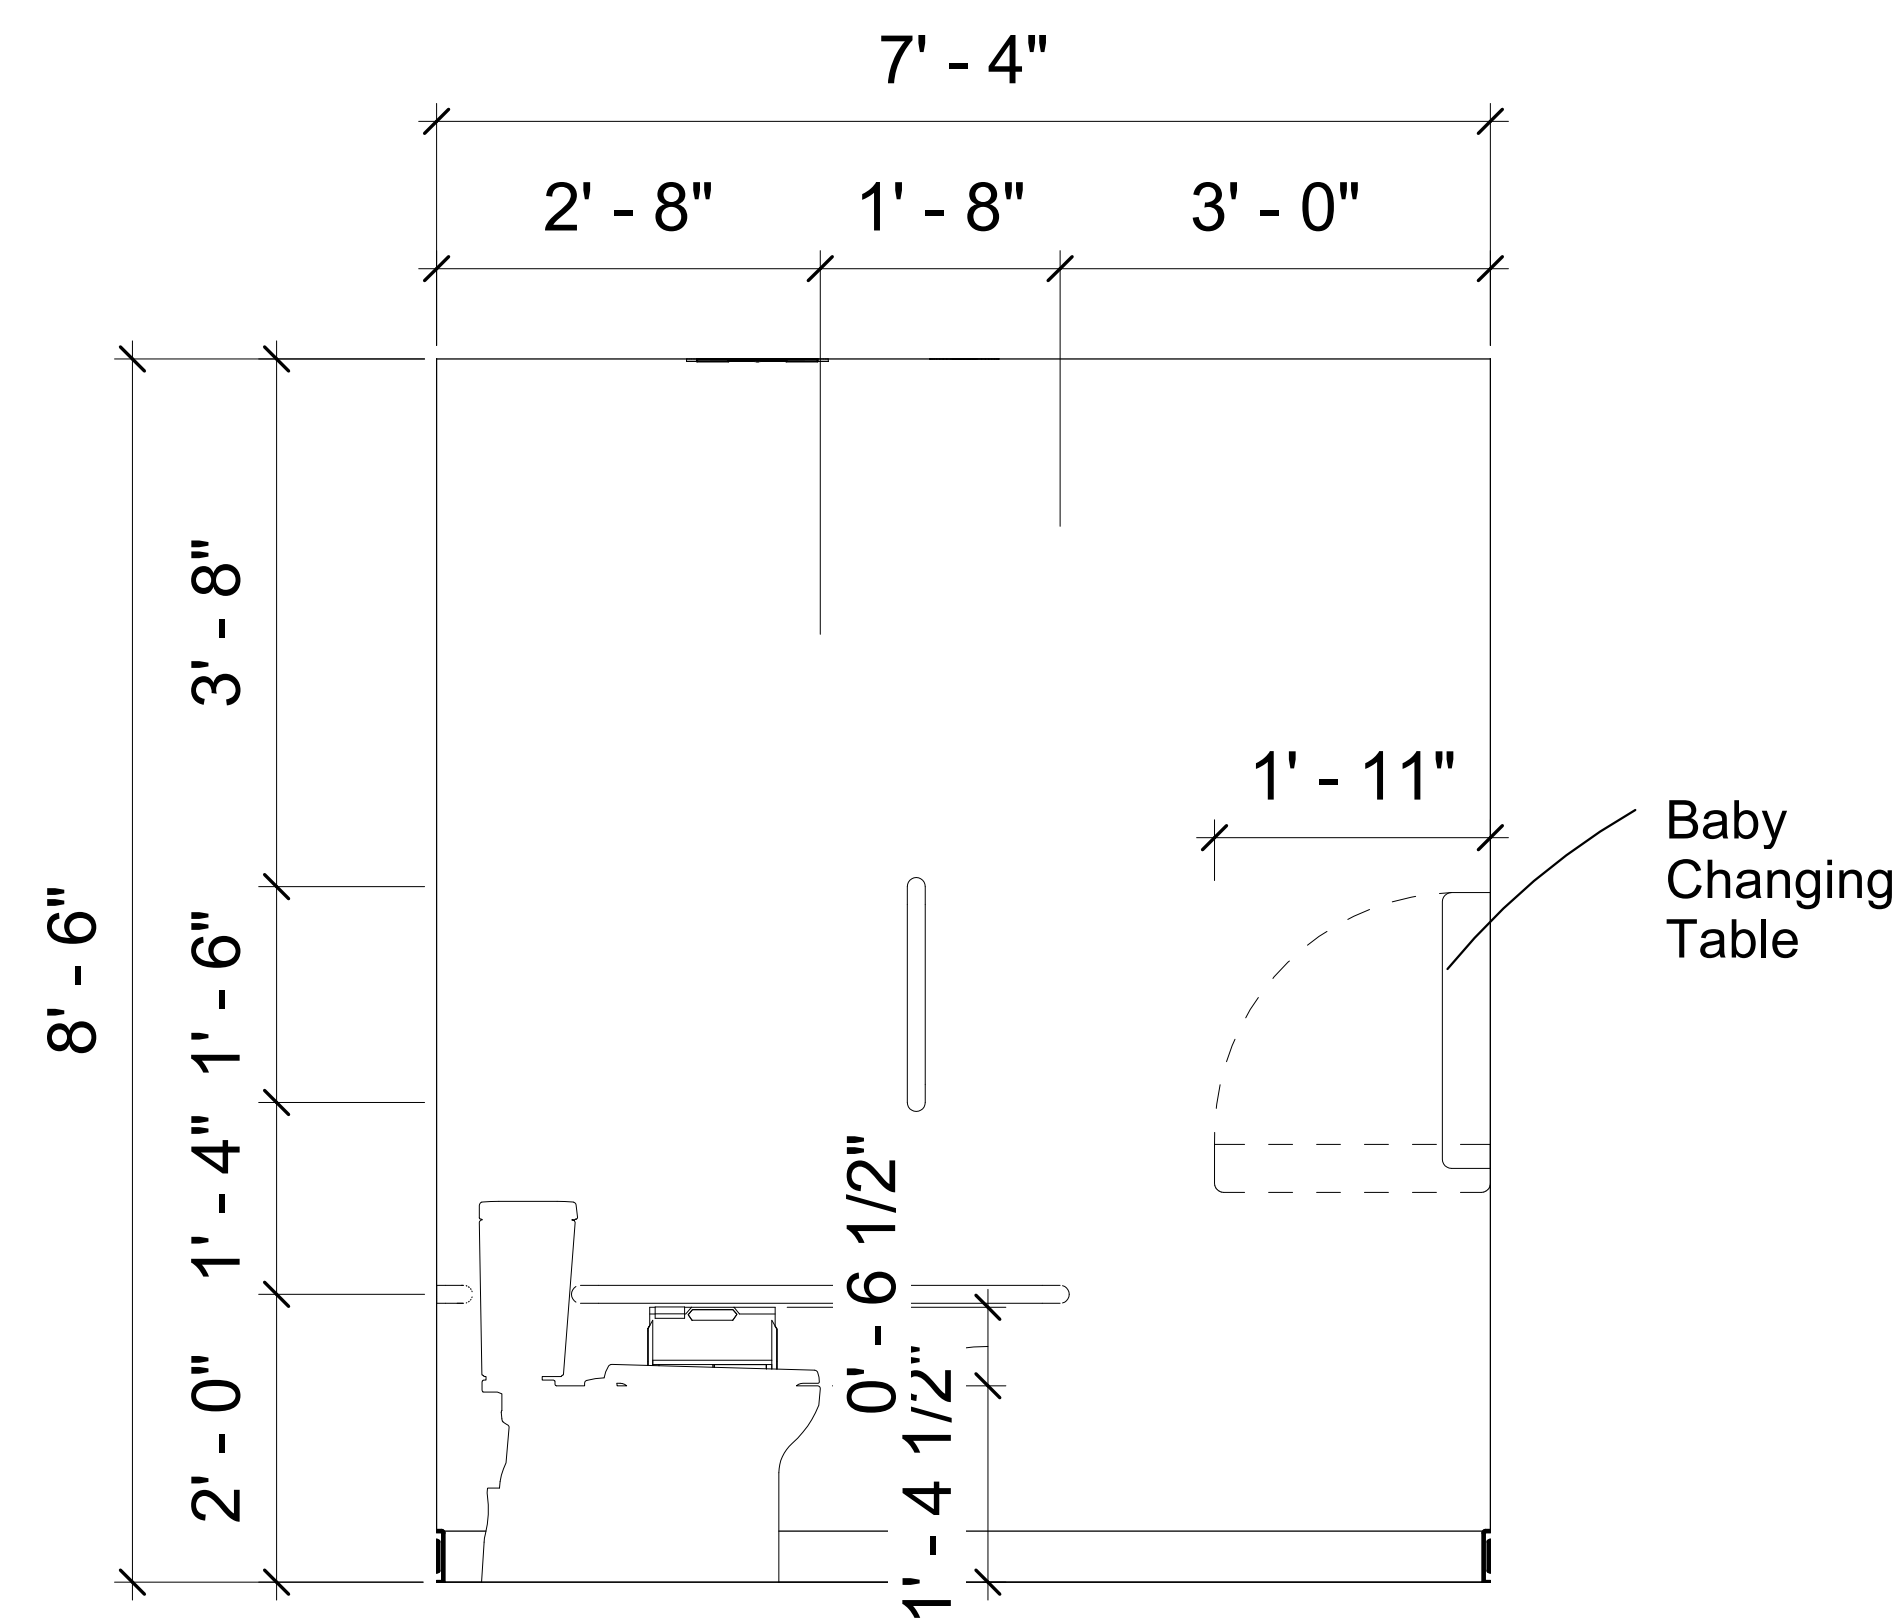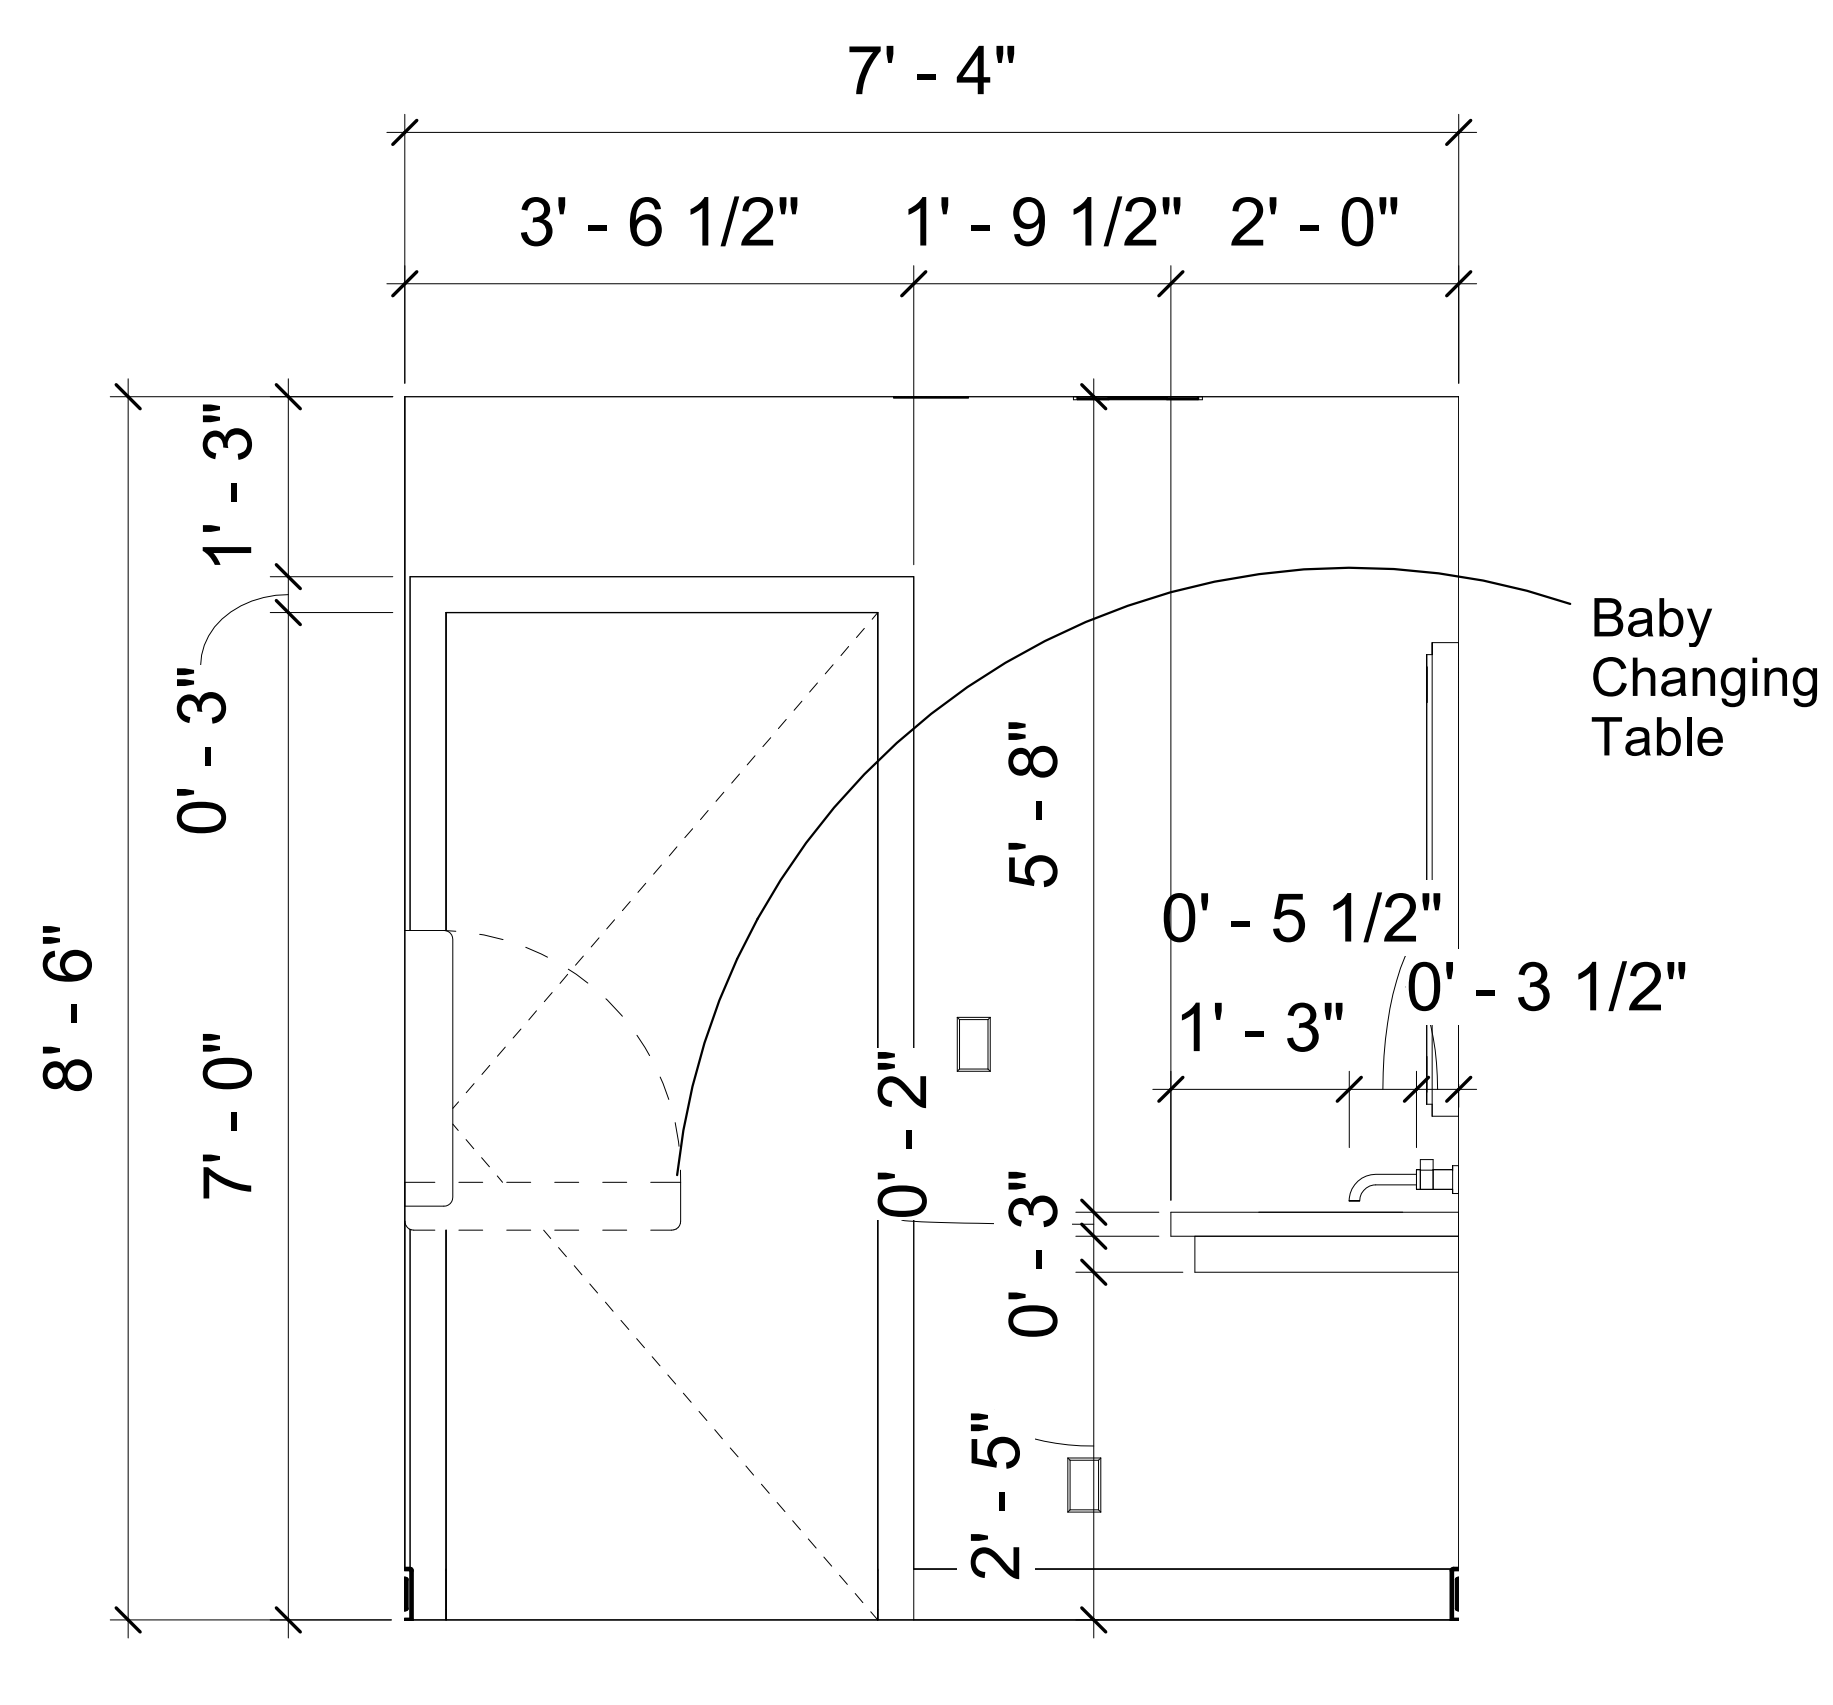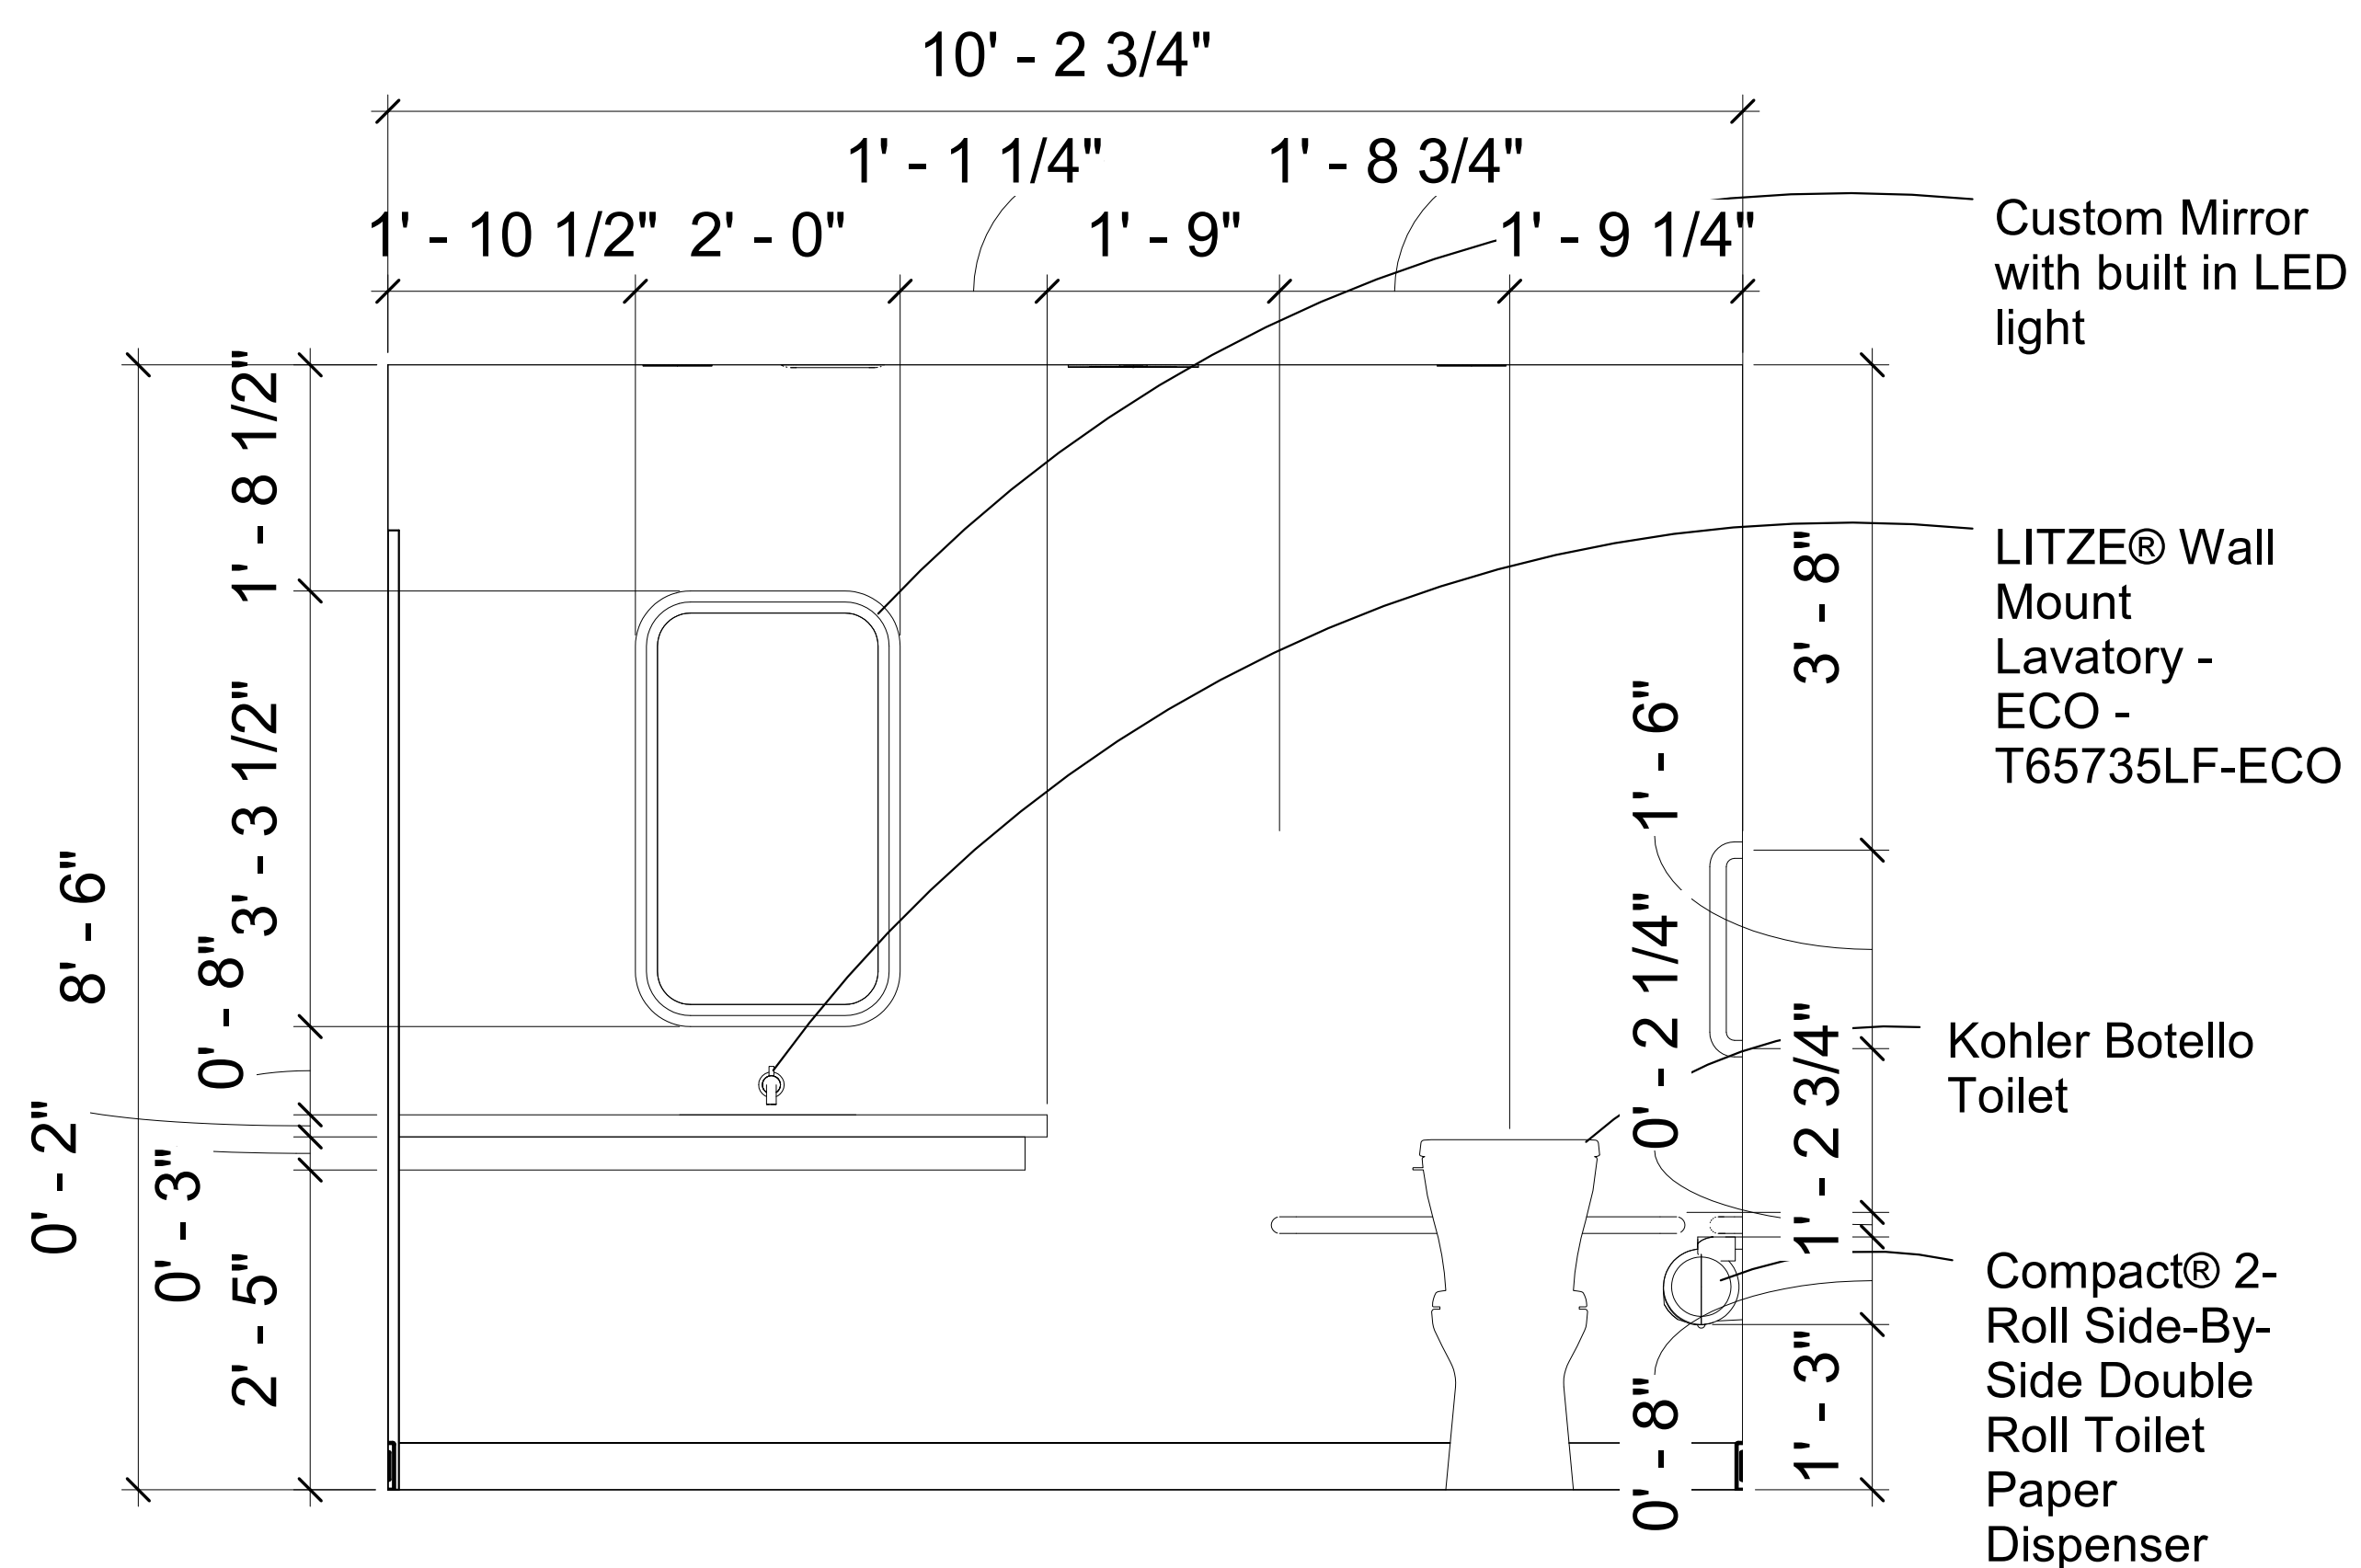
KSU
ID

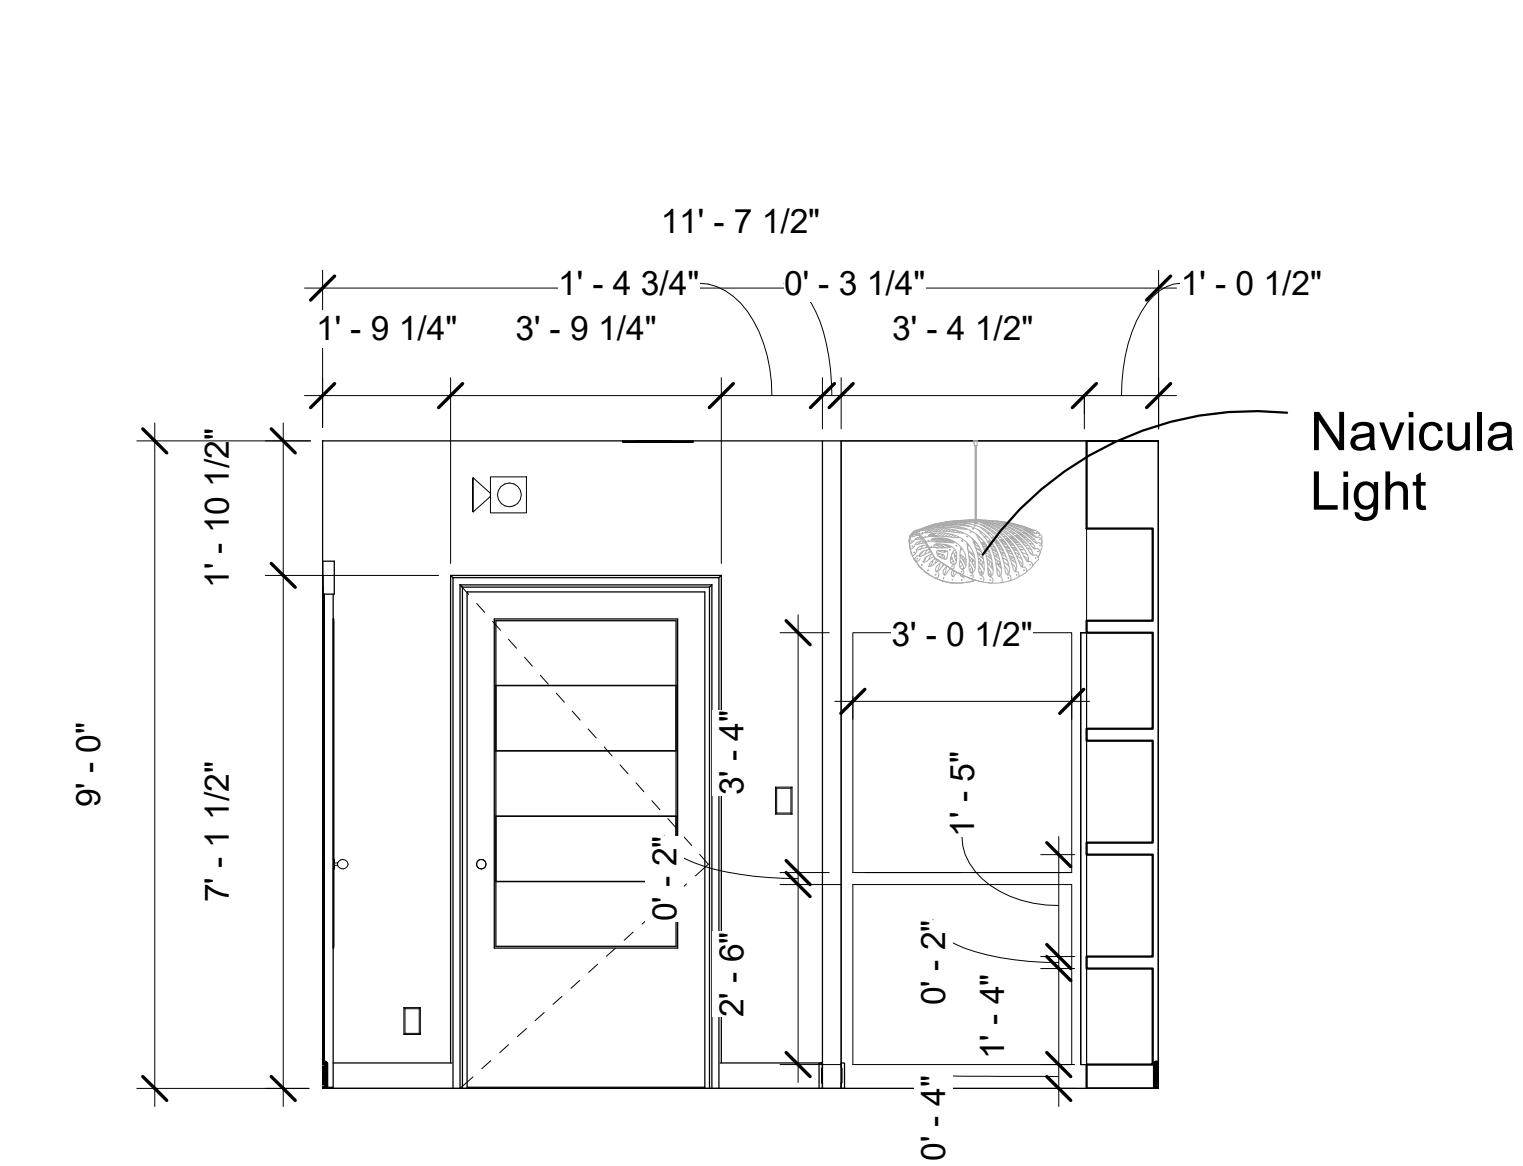


① West Locker Room
3/8" = 1'-0"

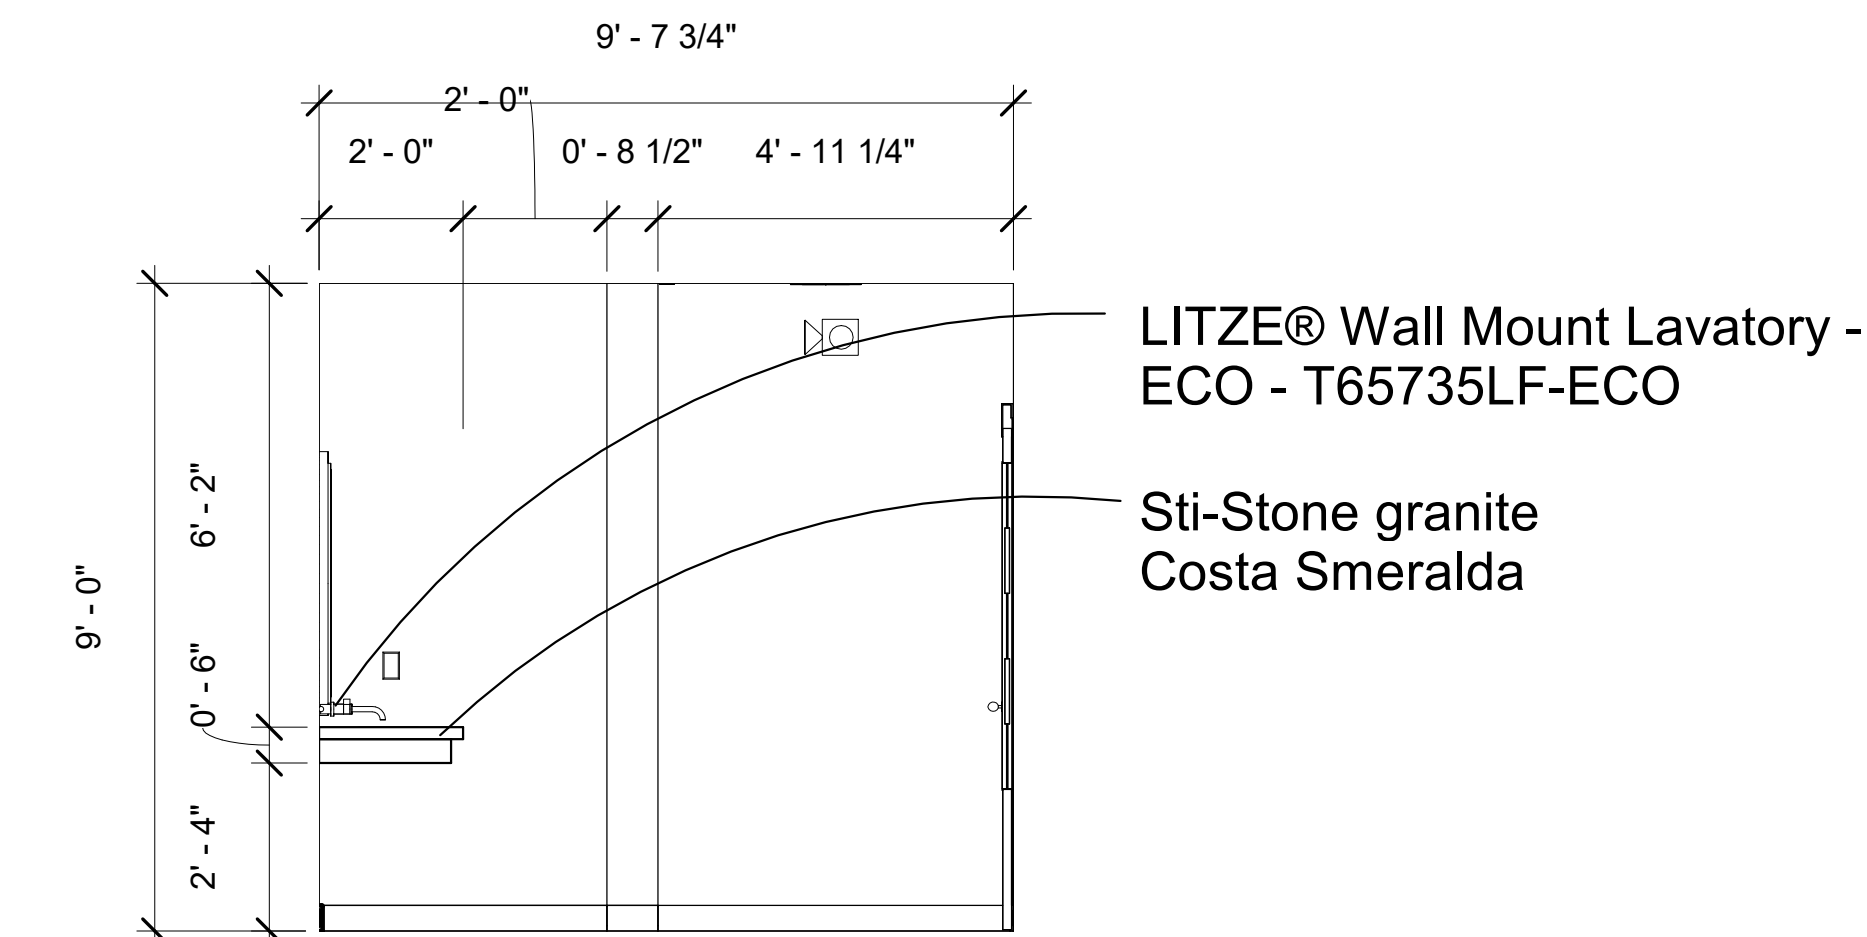


③ East Locker Room
3/8" = 1'-0"

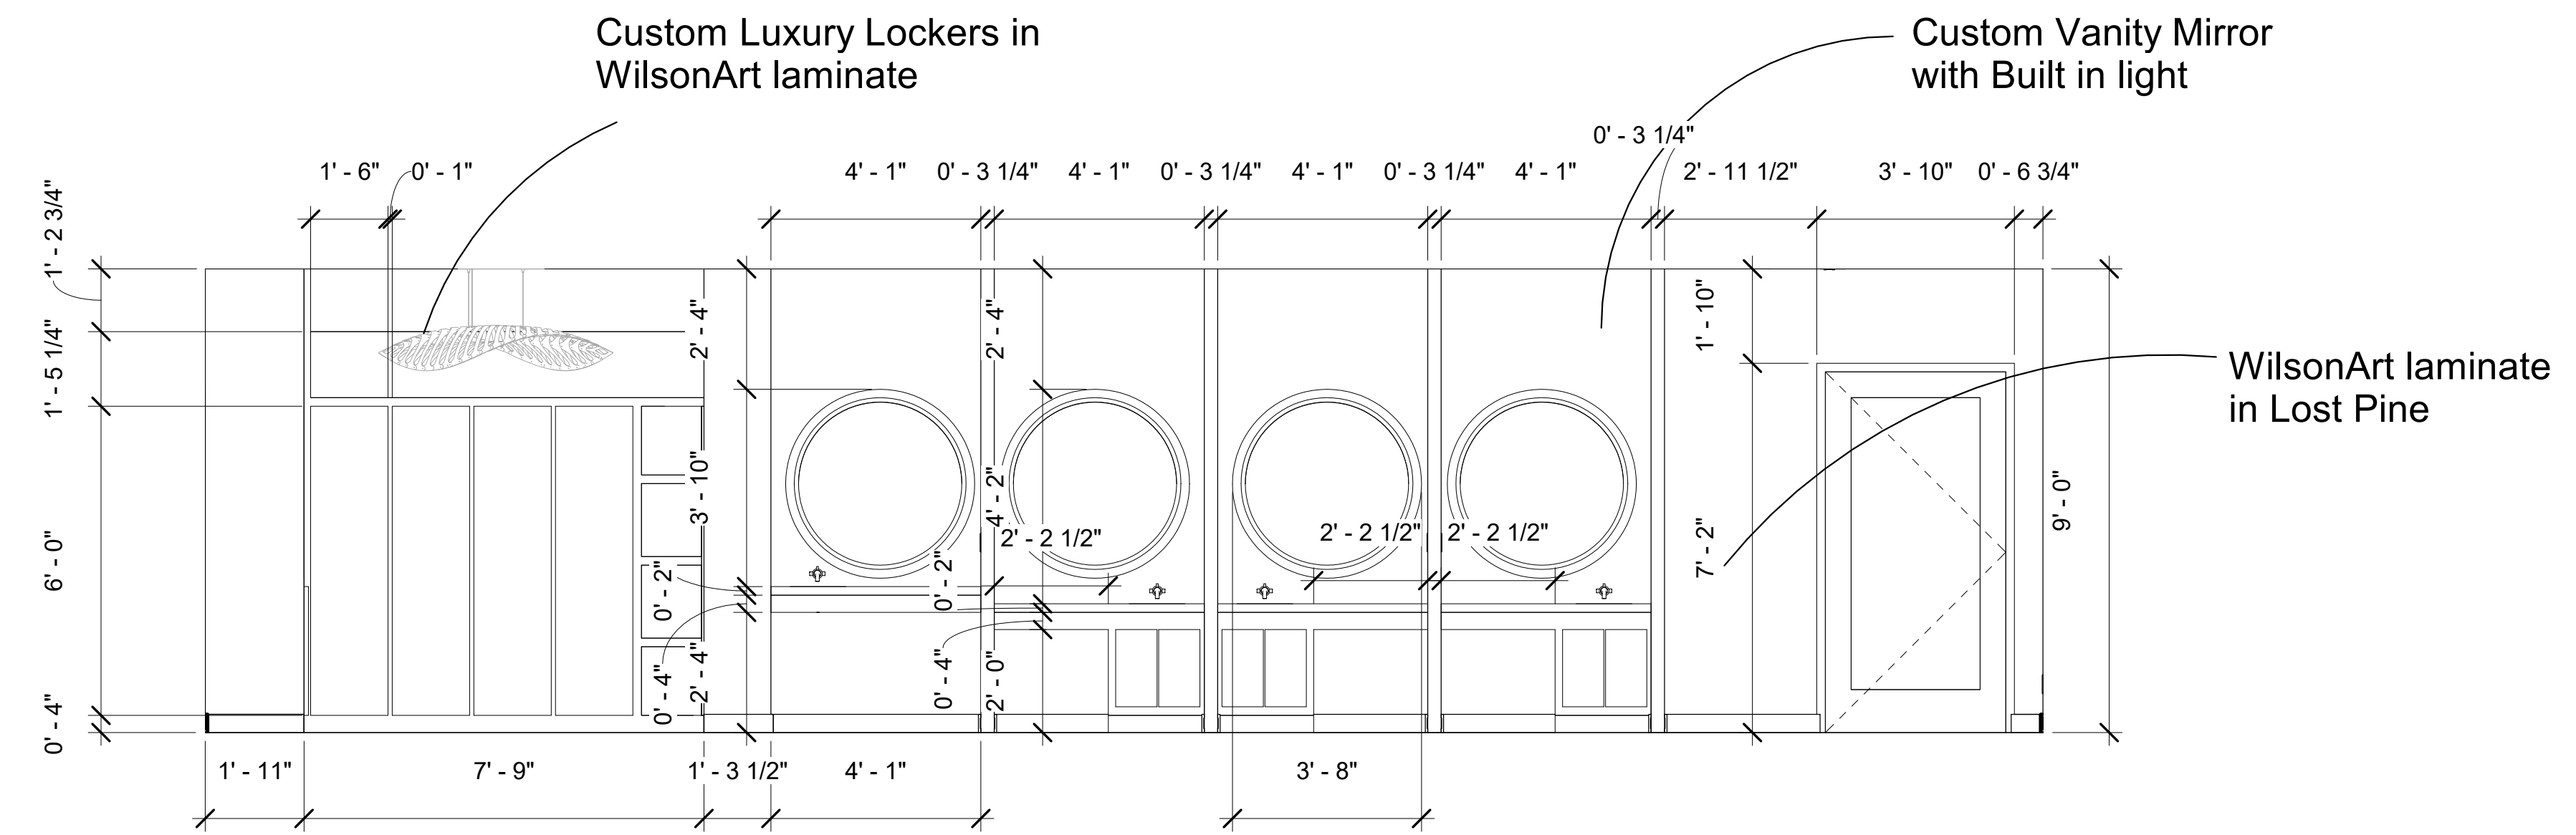

② North Locker Room
3/8" = 1'-0"

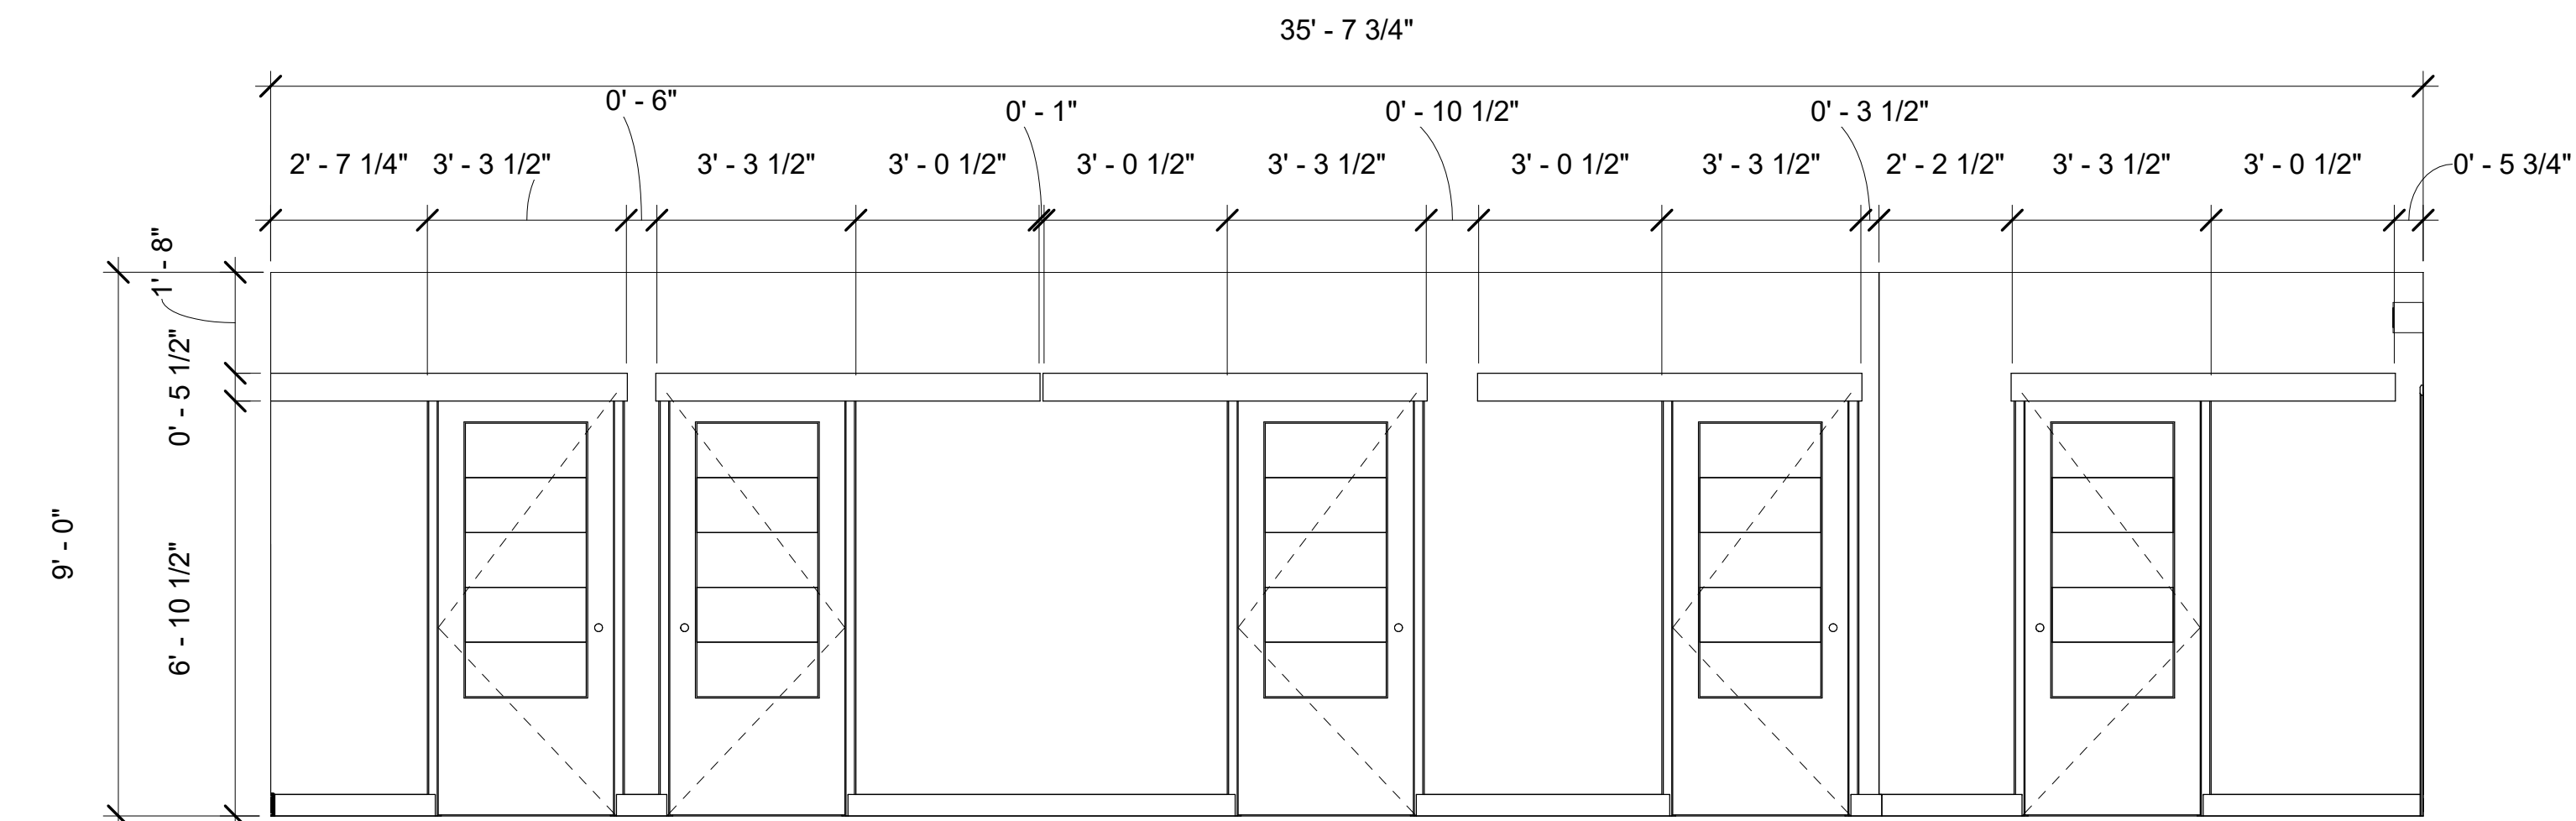

④ South Locker Room
3/8" = 1'-0"

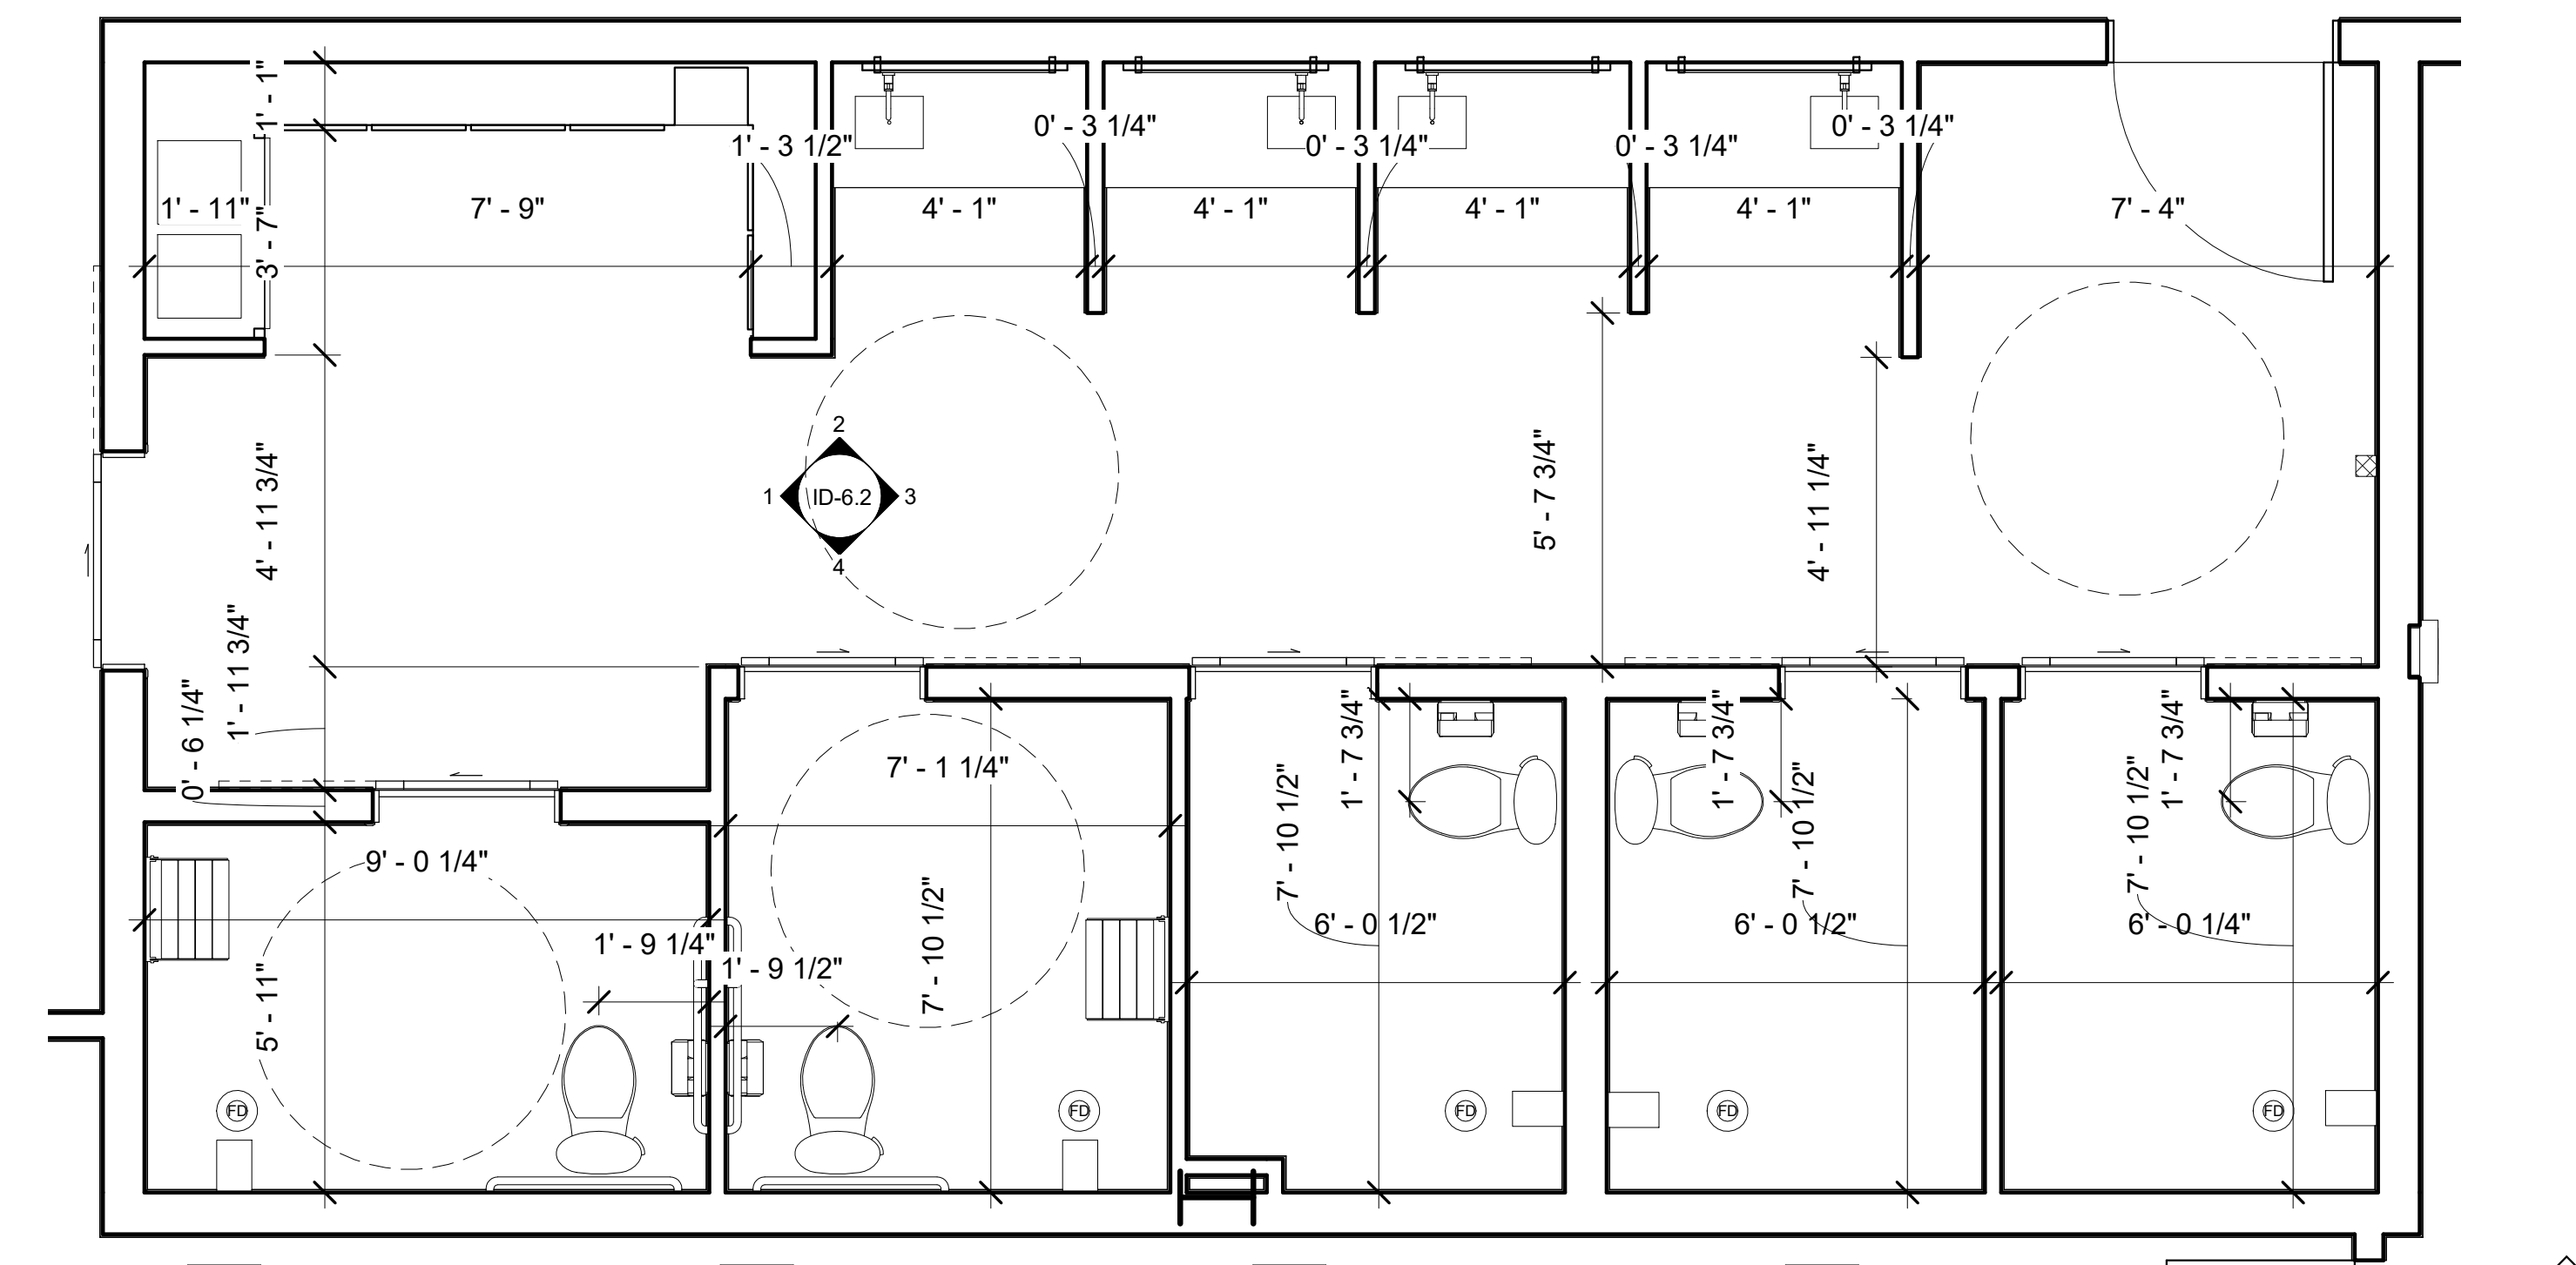

⑤ North Locker Room Enlarged Plan
3/8" = 1'-0"

KSU
ID

Kylie Arett

Kylie Arett
ID 645
Spring Semester
kkarett@ksu.edu

The Origins Wellness Center
4TH & PIERRE ST. MANHATTAN,
KS. 66502


Description	Date

Enlarged
Plan
Northern
Locker
Room


Date Issue Date
Drawn by
Checked by

ID-6.2


Scale 3/8" = 1'-0"

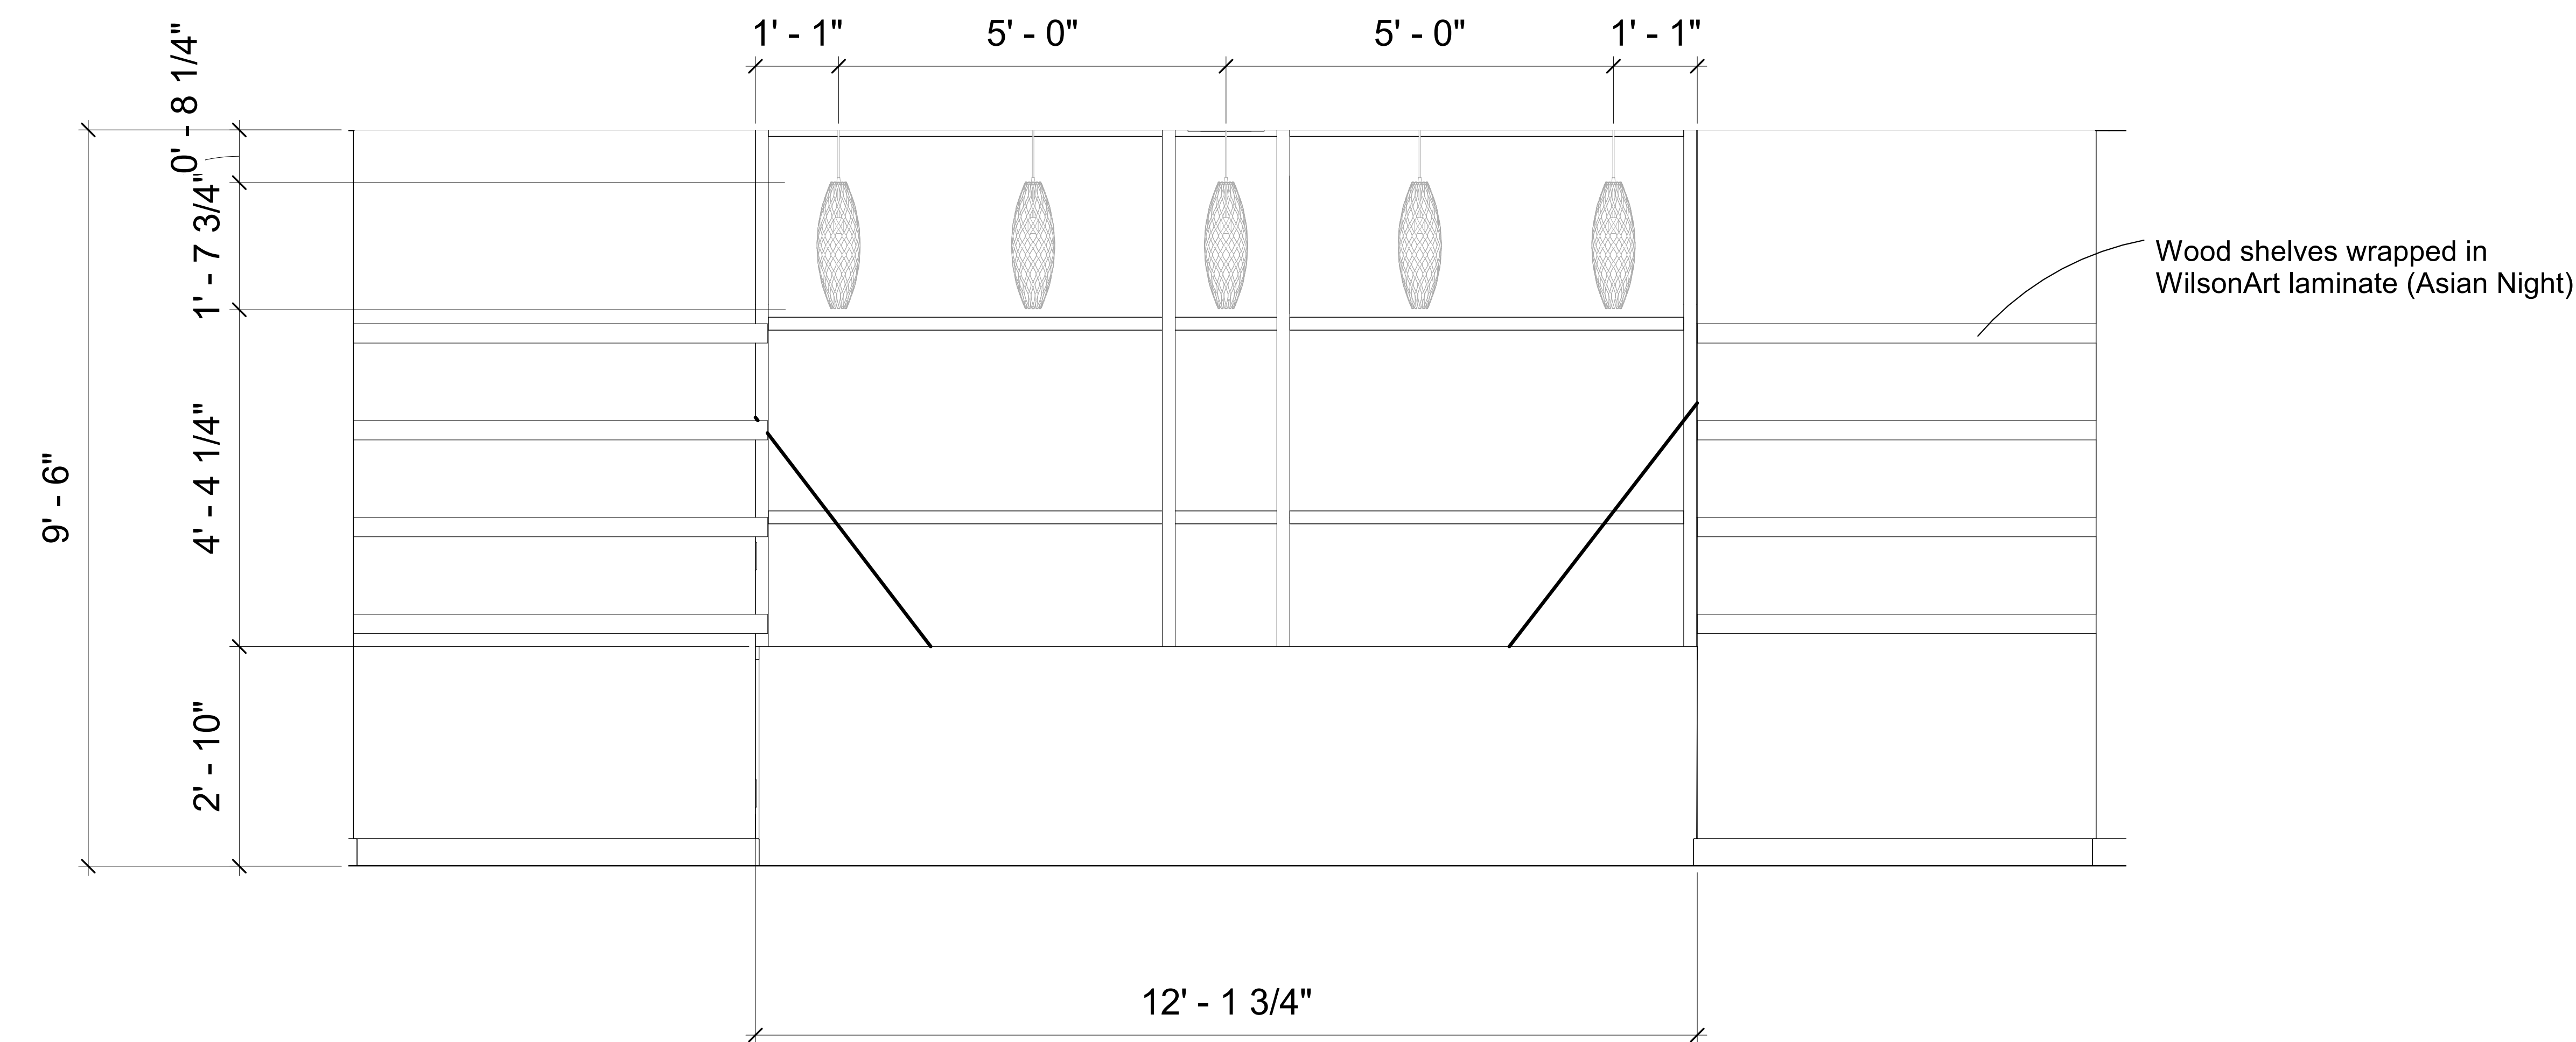

① Reception Front
3/4" = 1'-0"

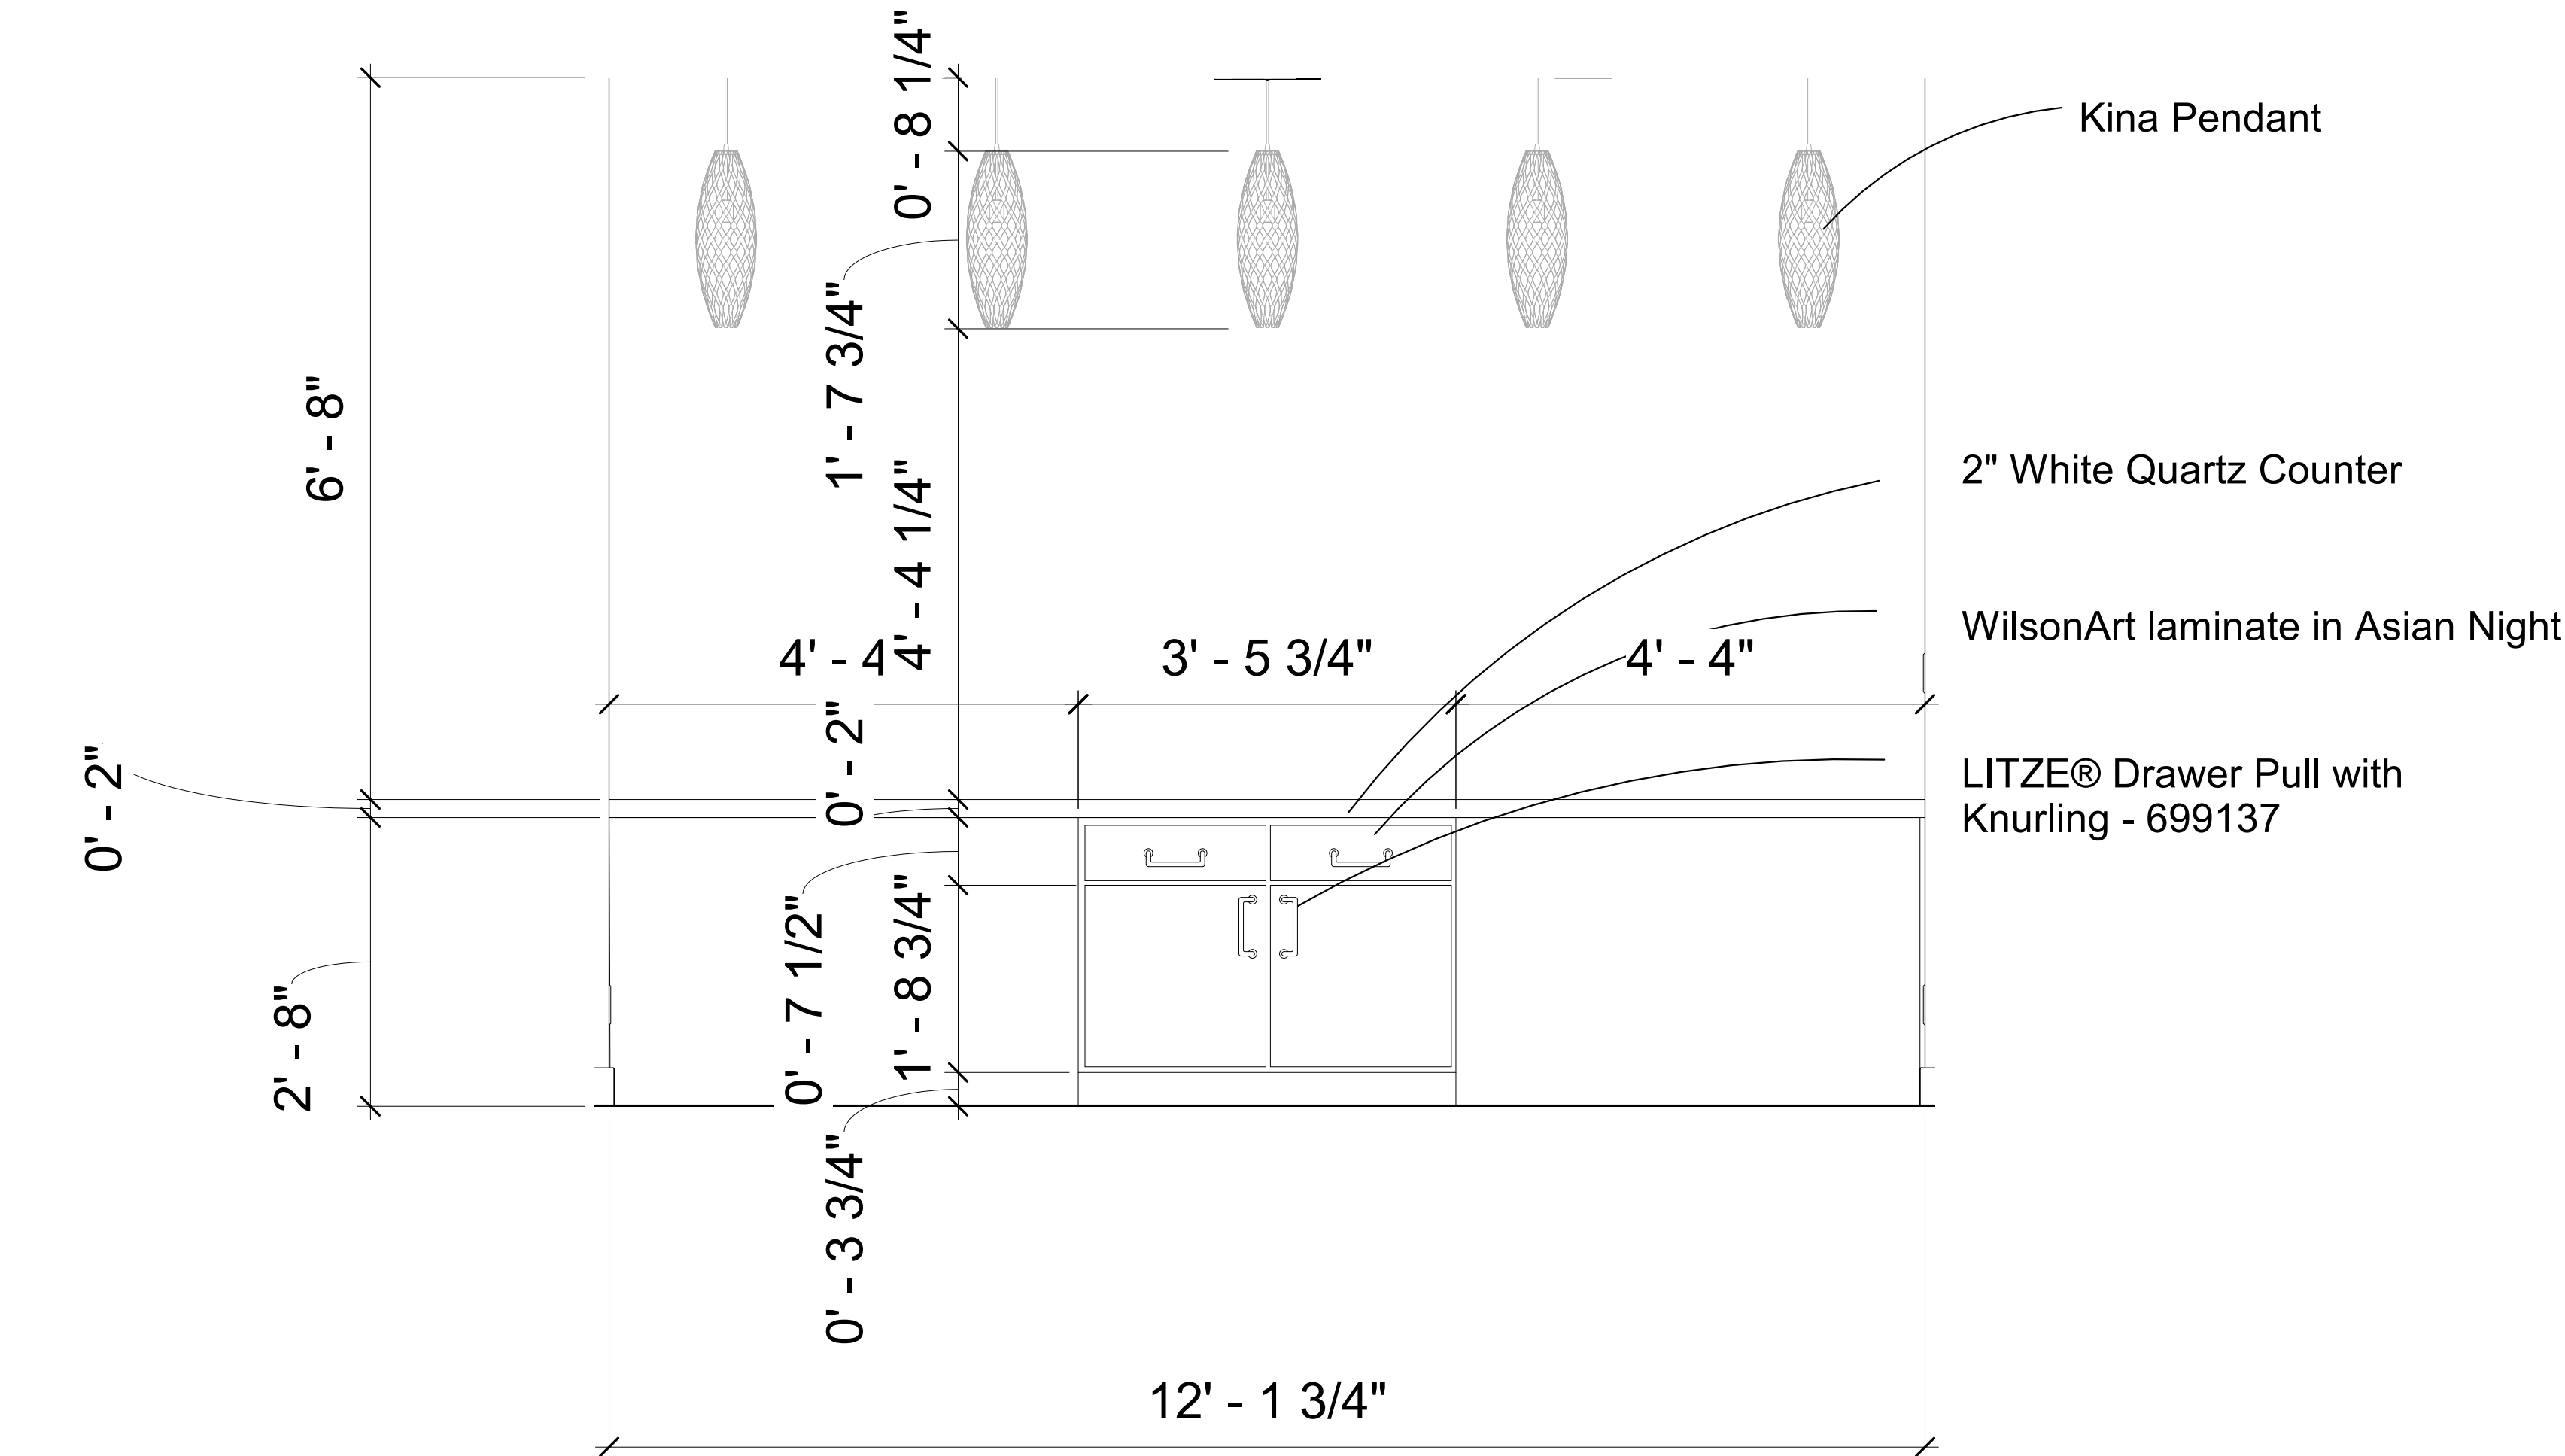

② Reception Back
3/4" = 1'-0"

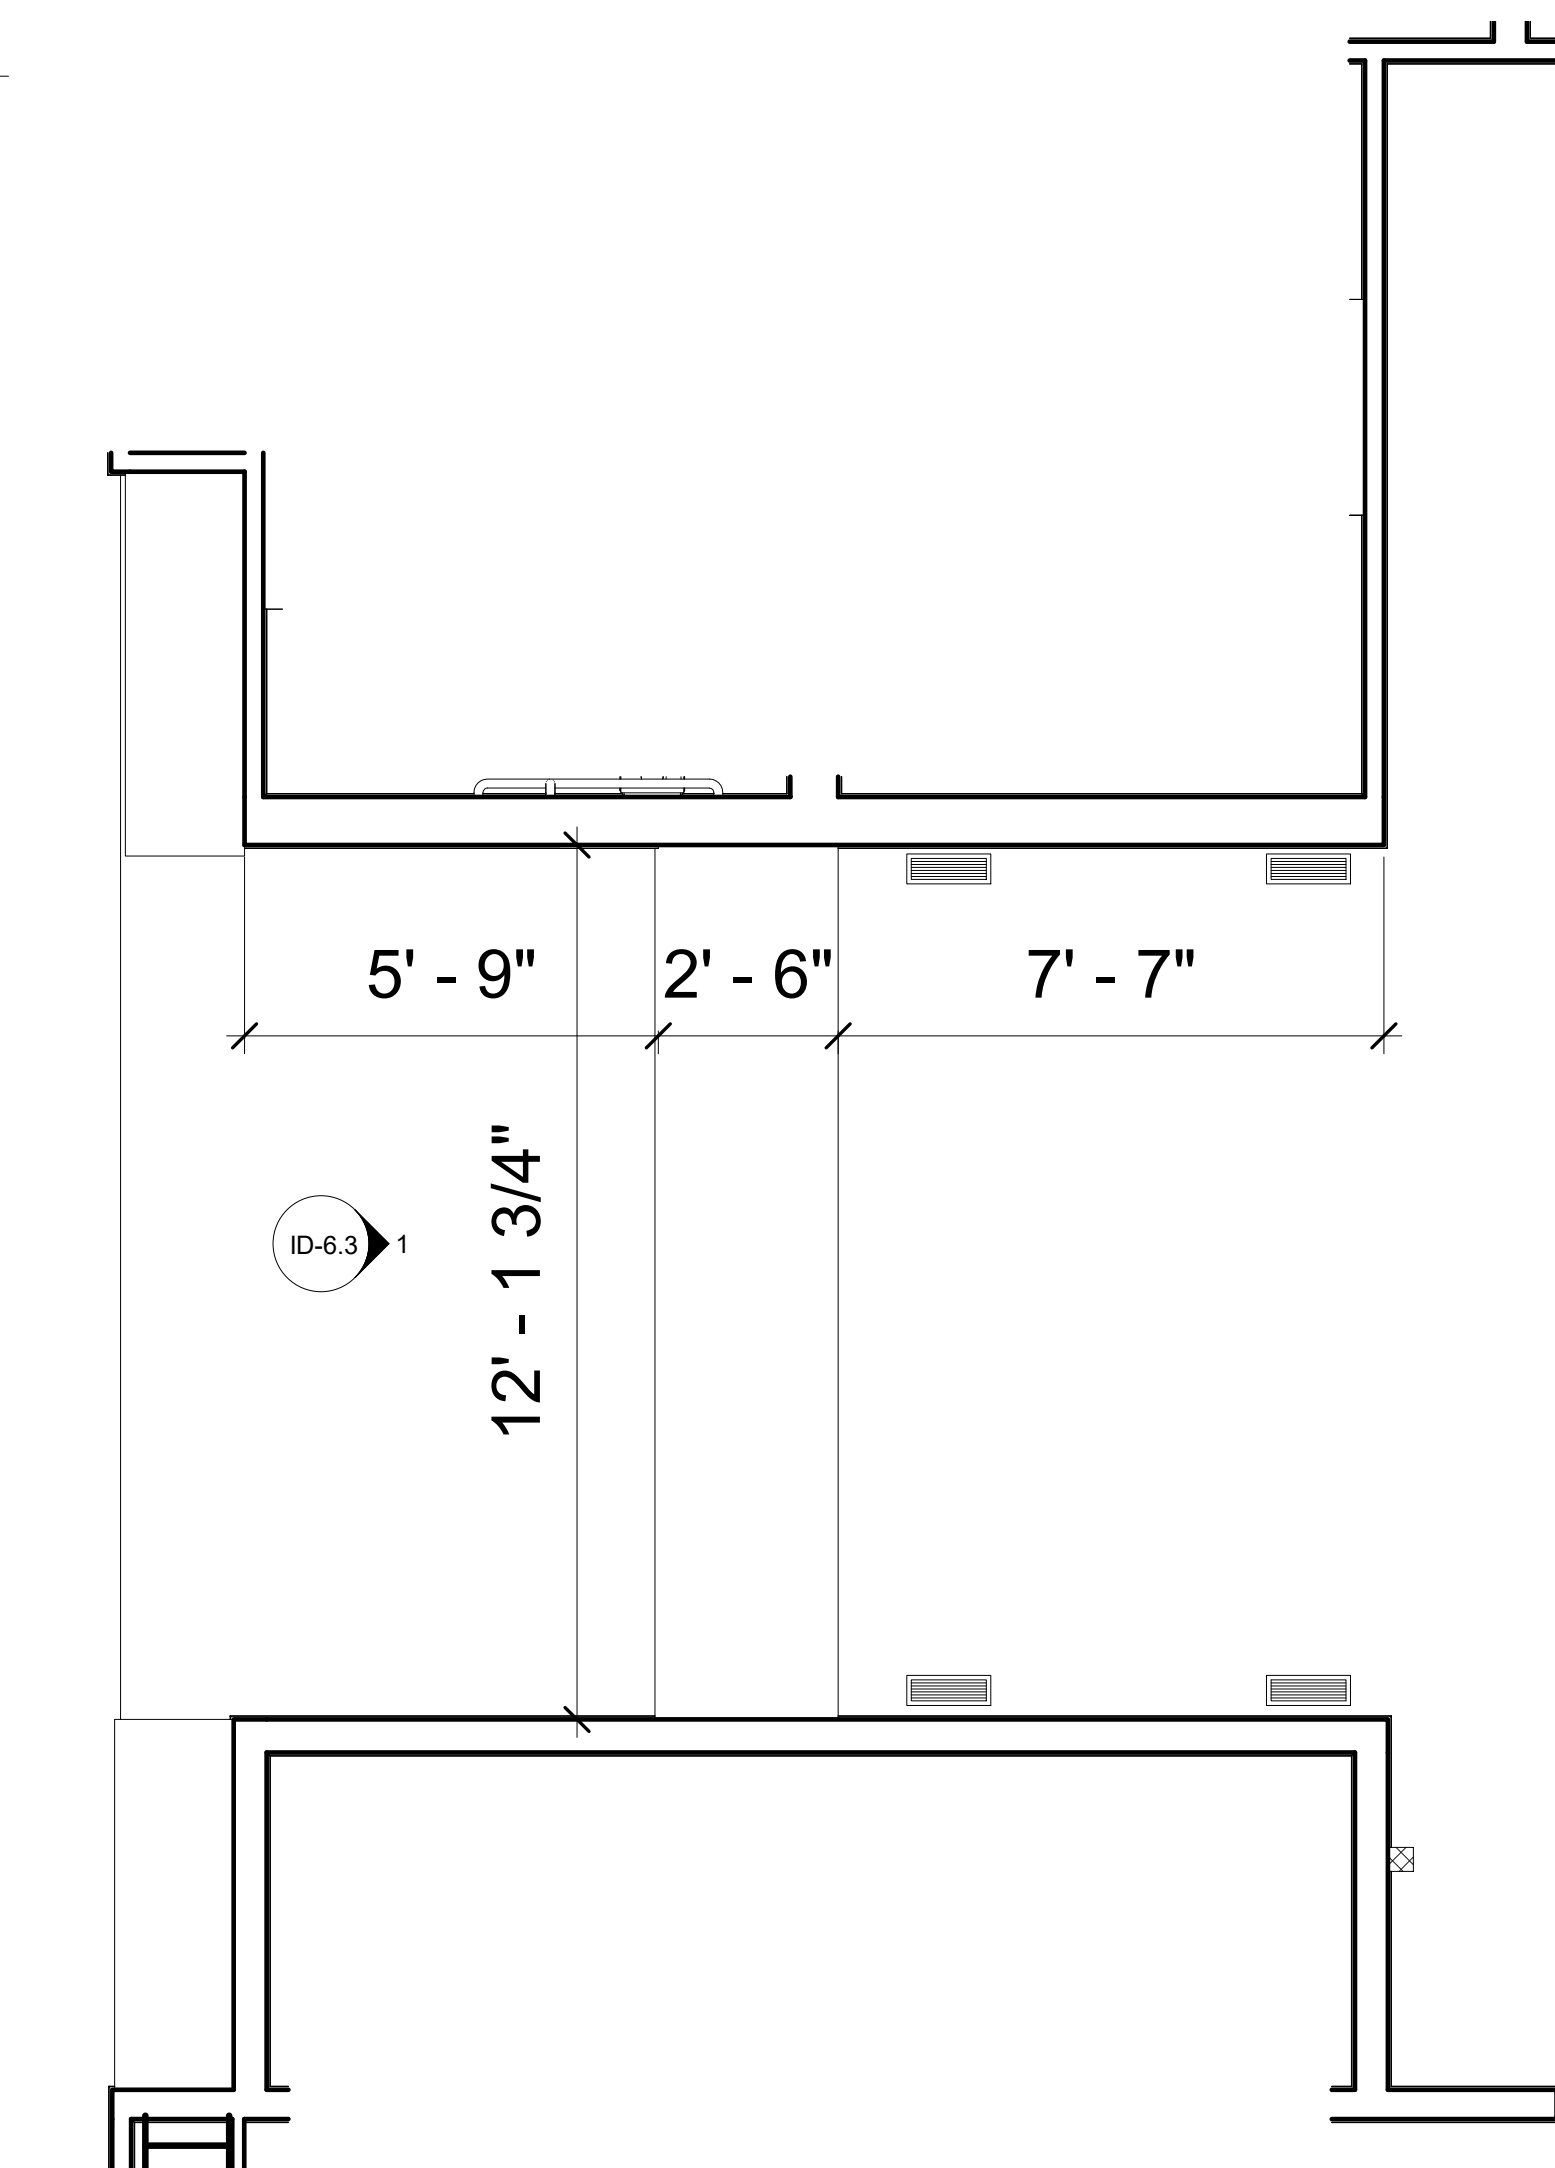

③ Reception Enlarged Plan
3/8" = 1'-0"

KSU
ID

Kylie Arett

Kylie Arett
ID 645
Spring Semester
kkarett@ksu.edu






The Origins Wellness Center
4TH & PIERRE ST. MANHATTAN,
KS. 66502

Description	Date

Enlarged
Plan
Reception


Date	Issue Date
Drawn by	
Checked by	
ID-6.3	
Scale	As indicated

4/28/2021 2:38:04 PM

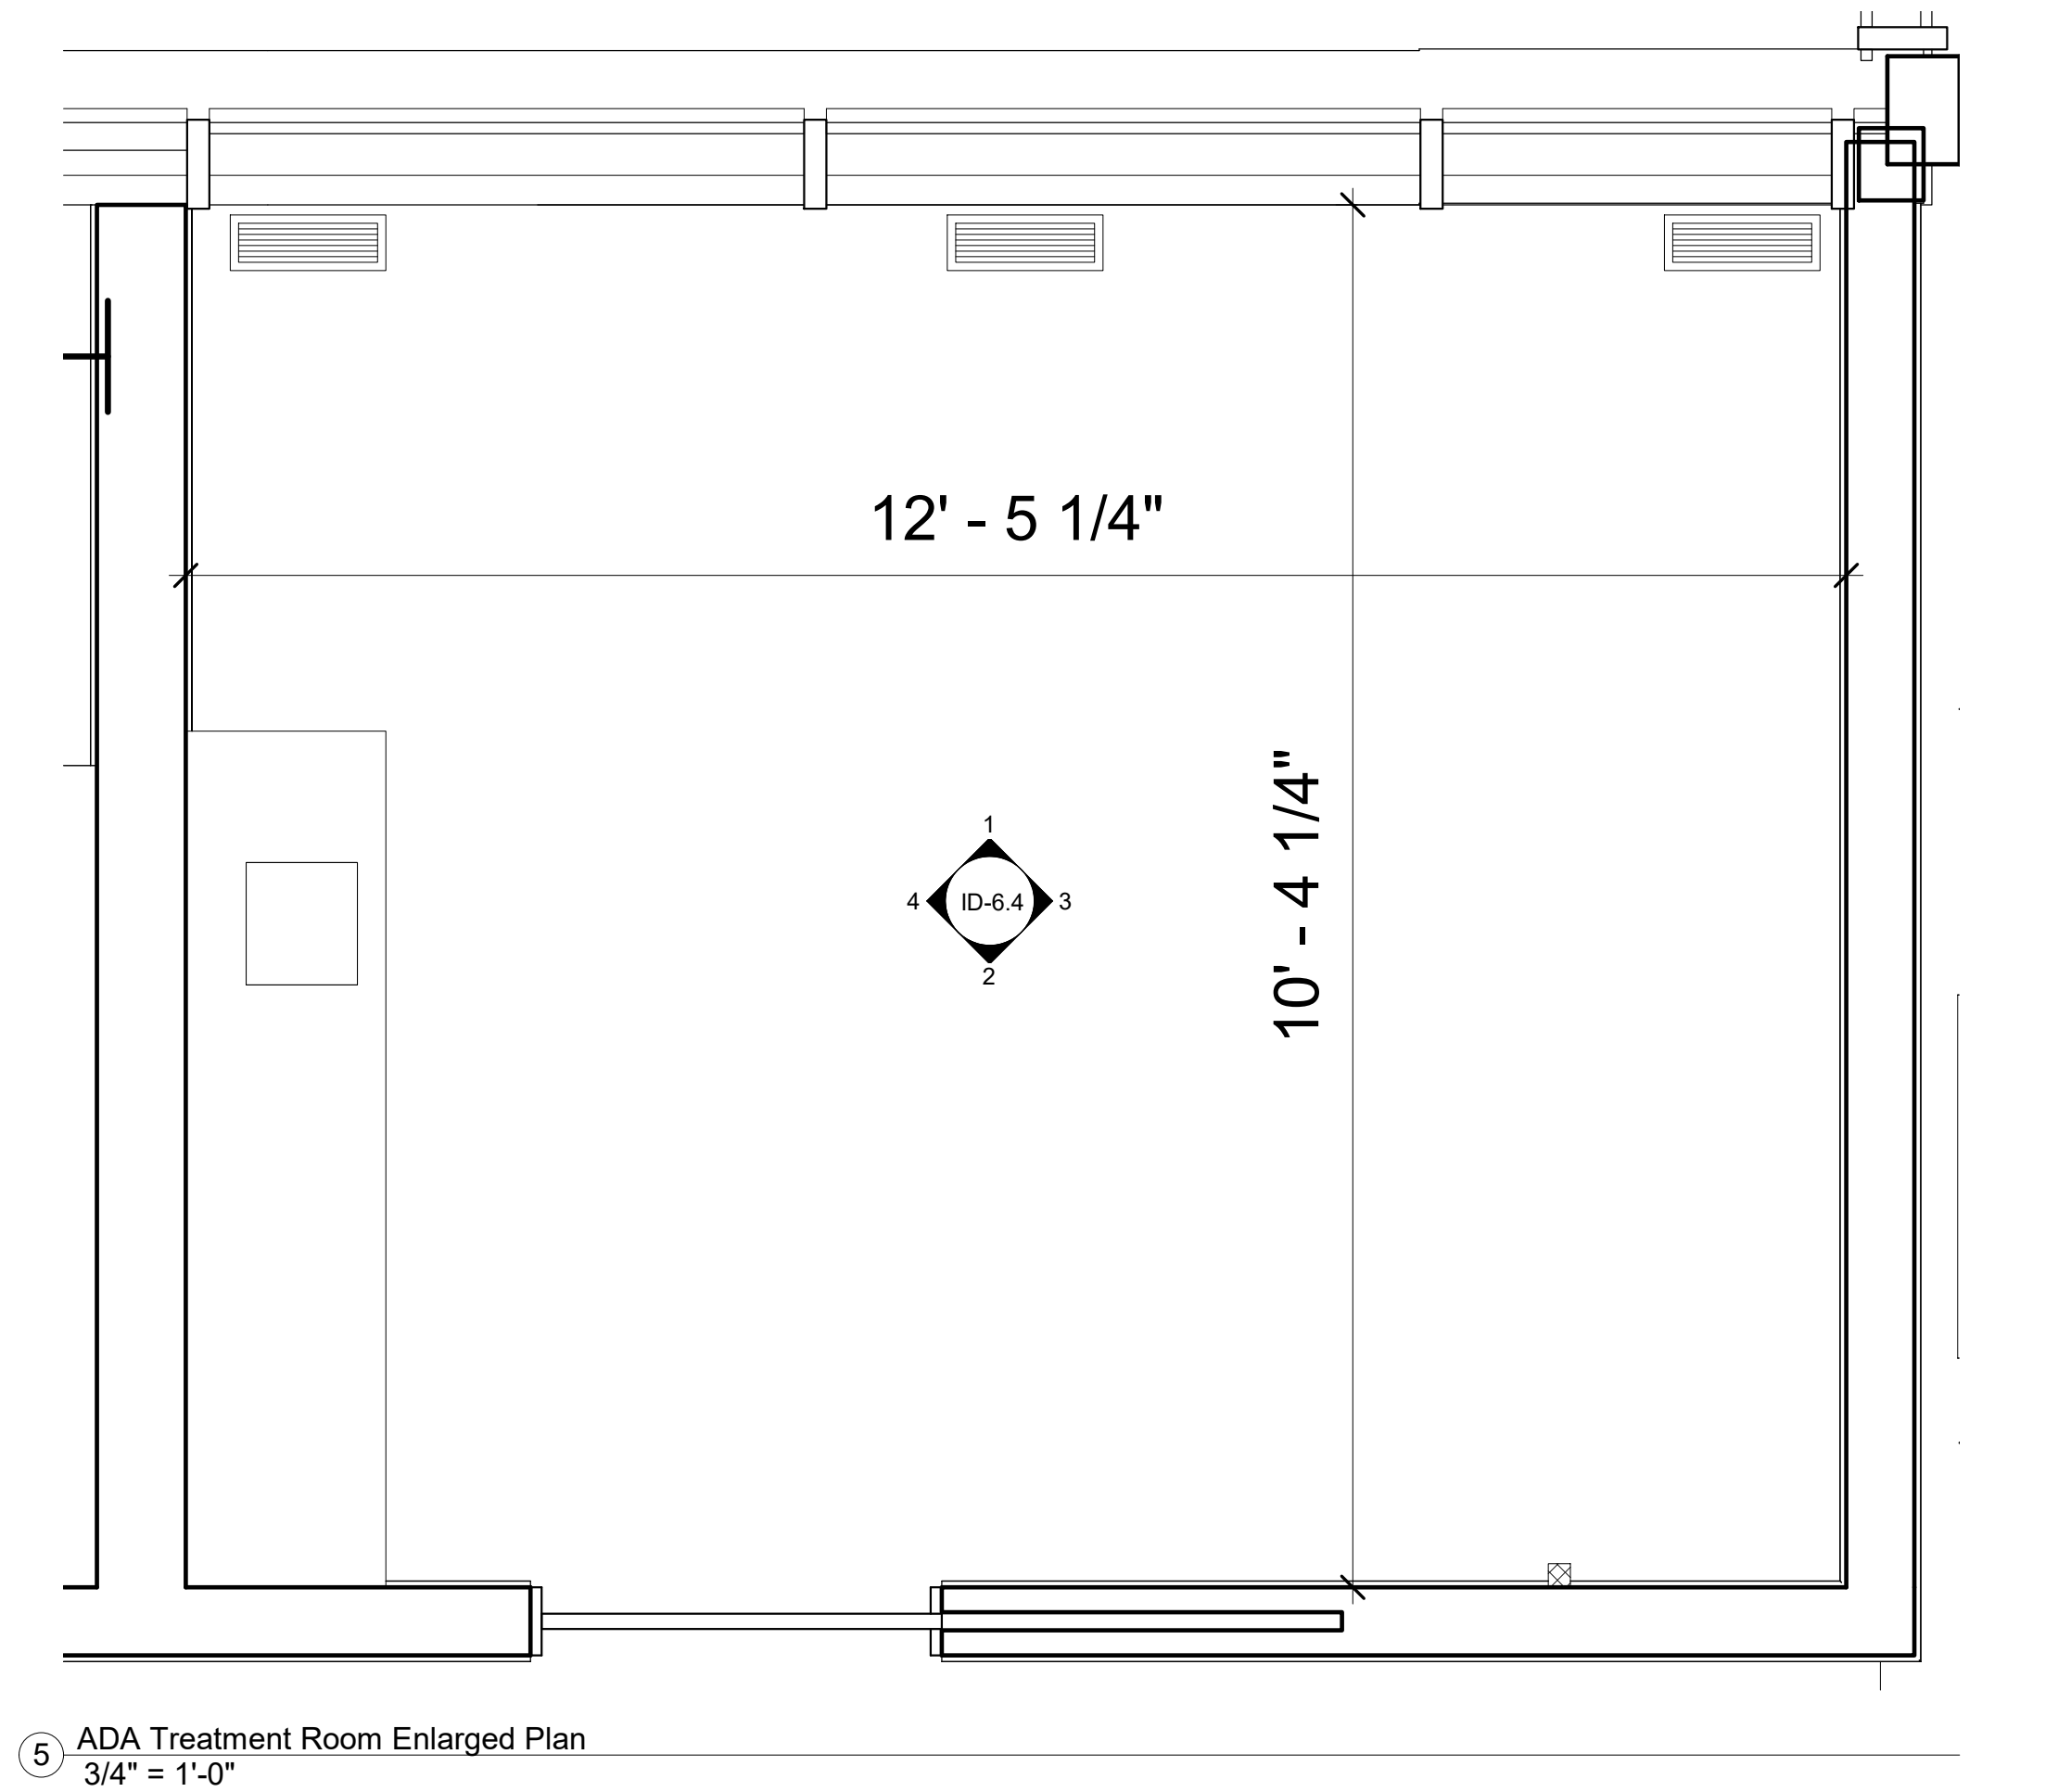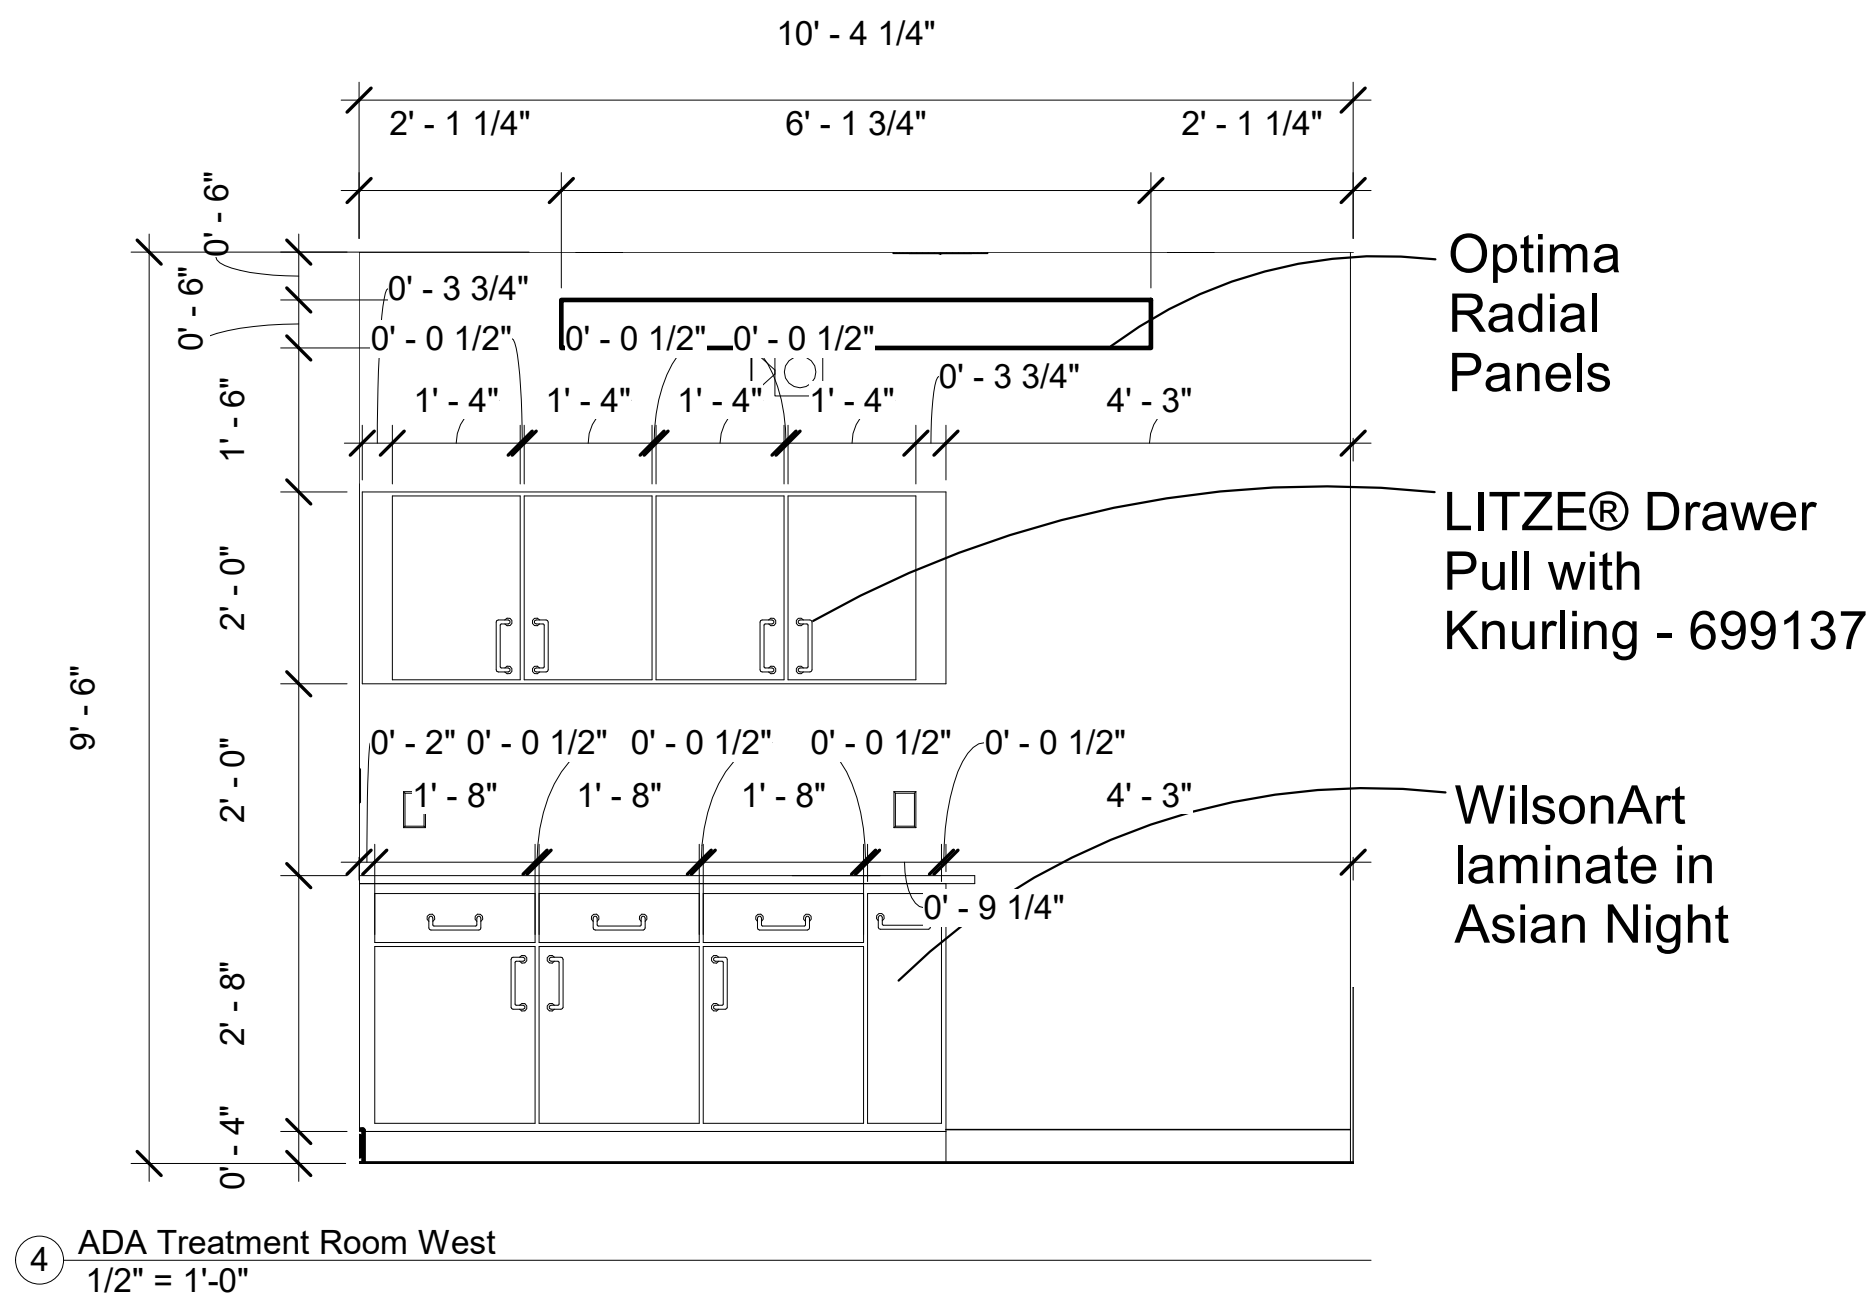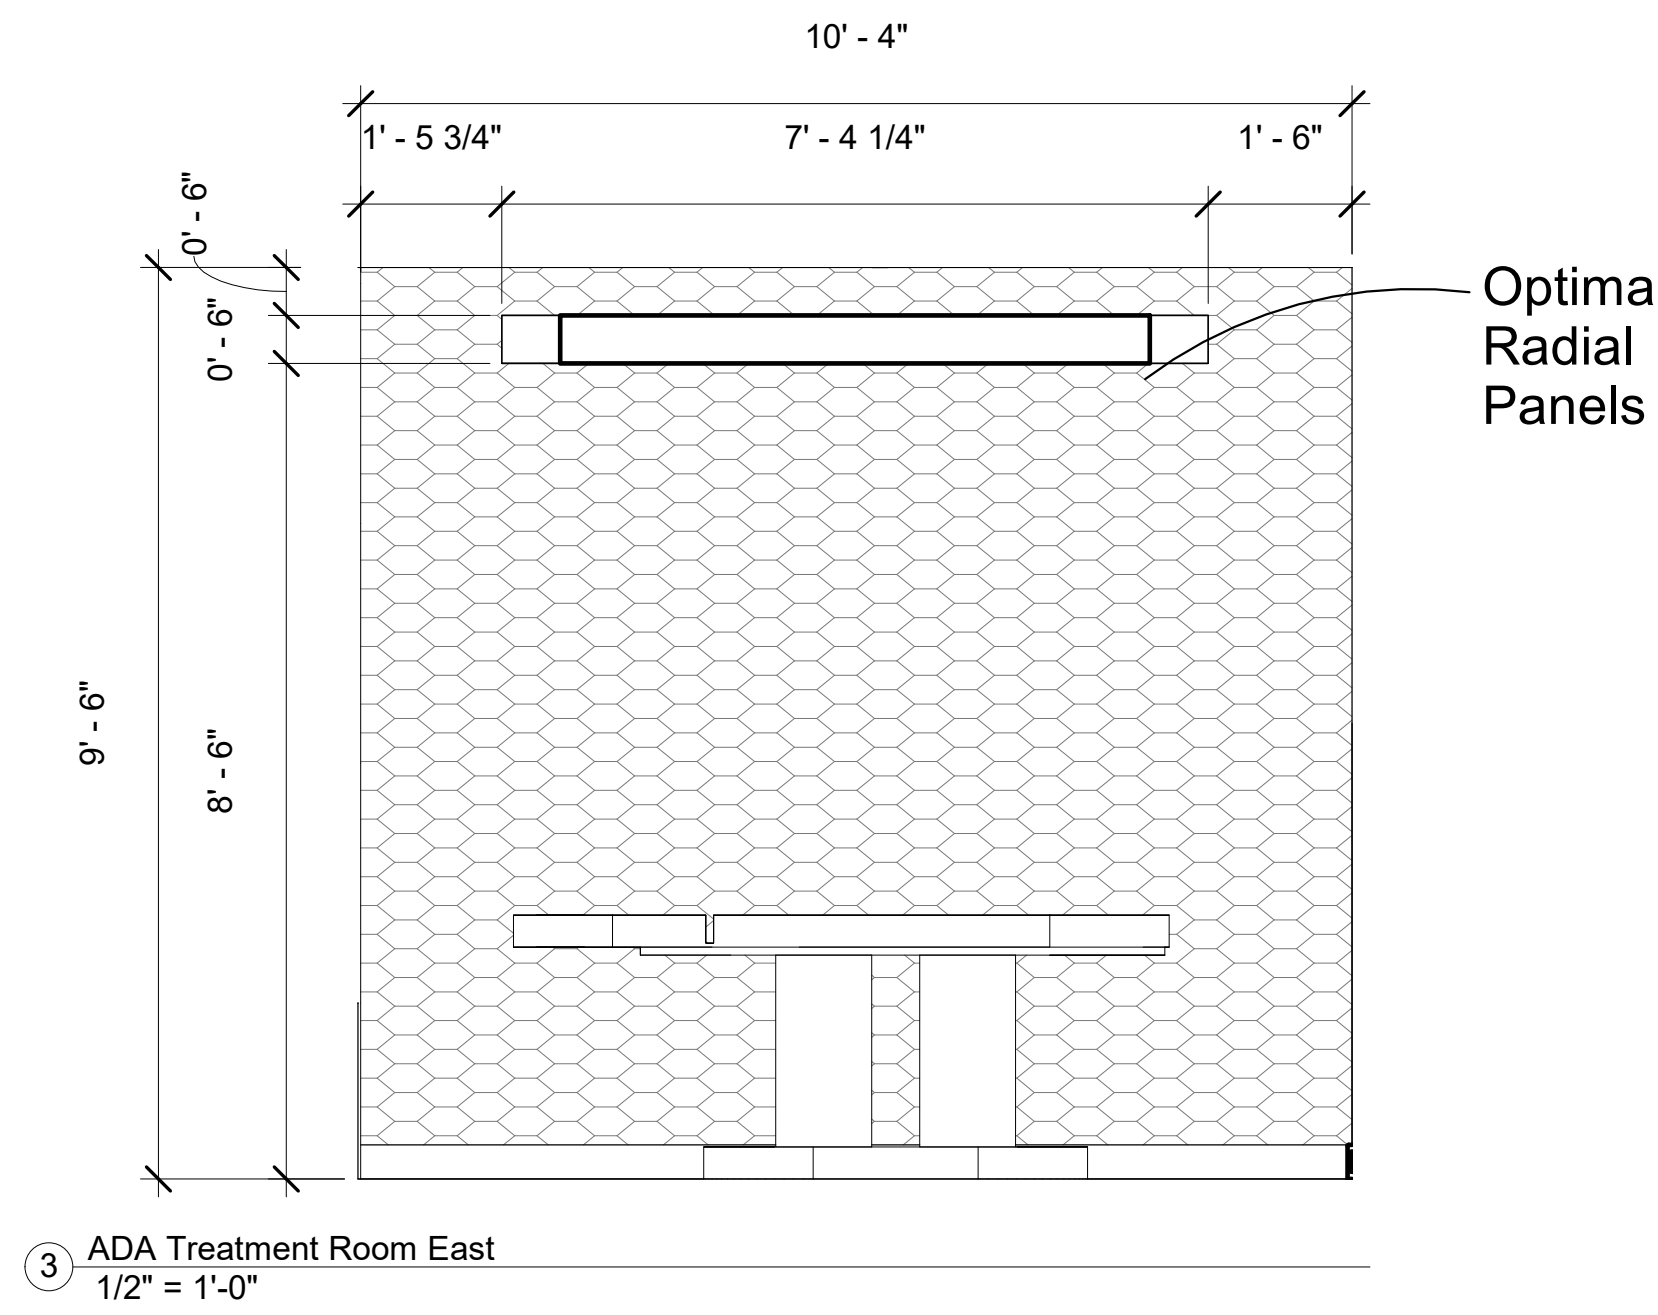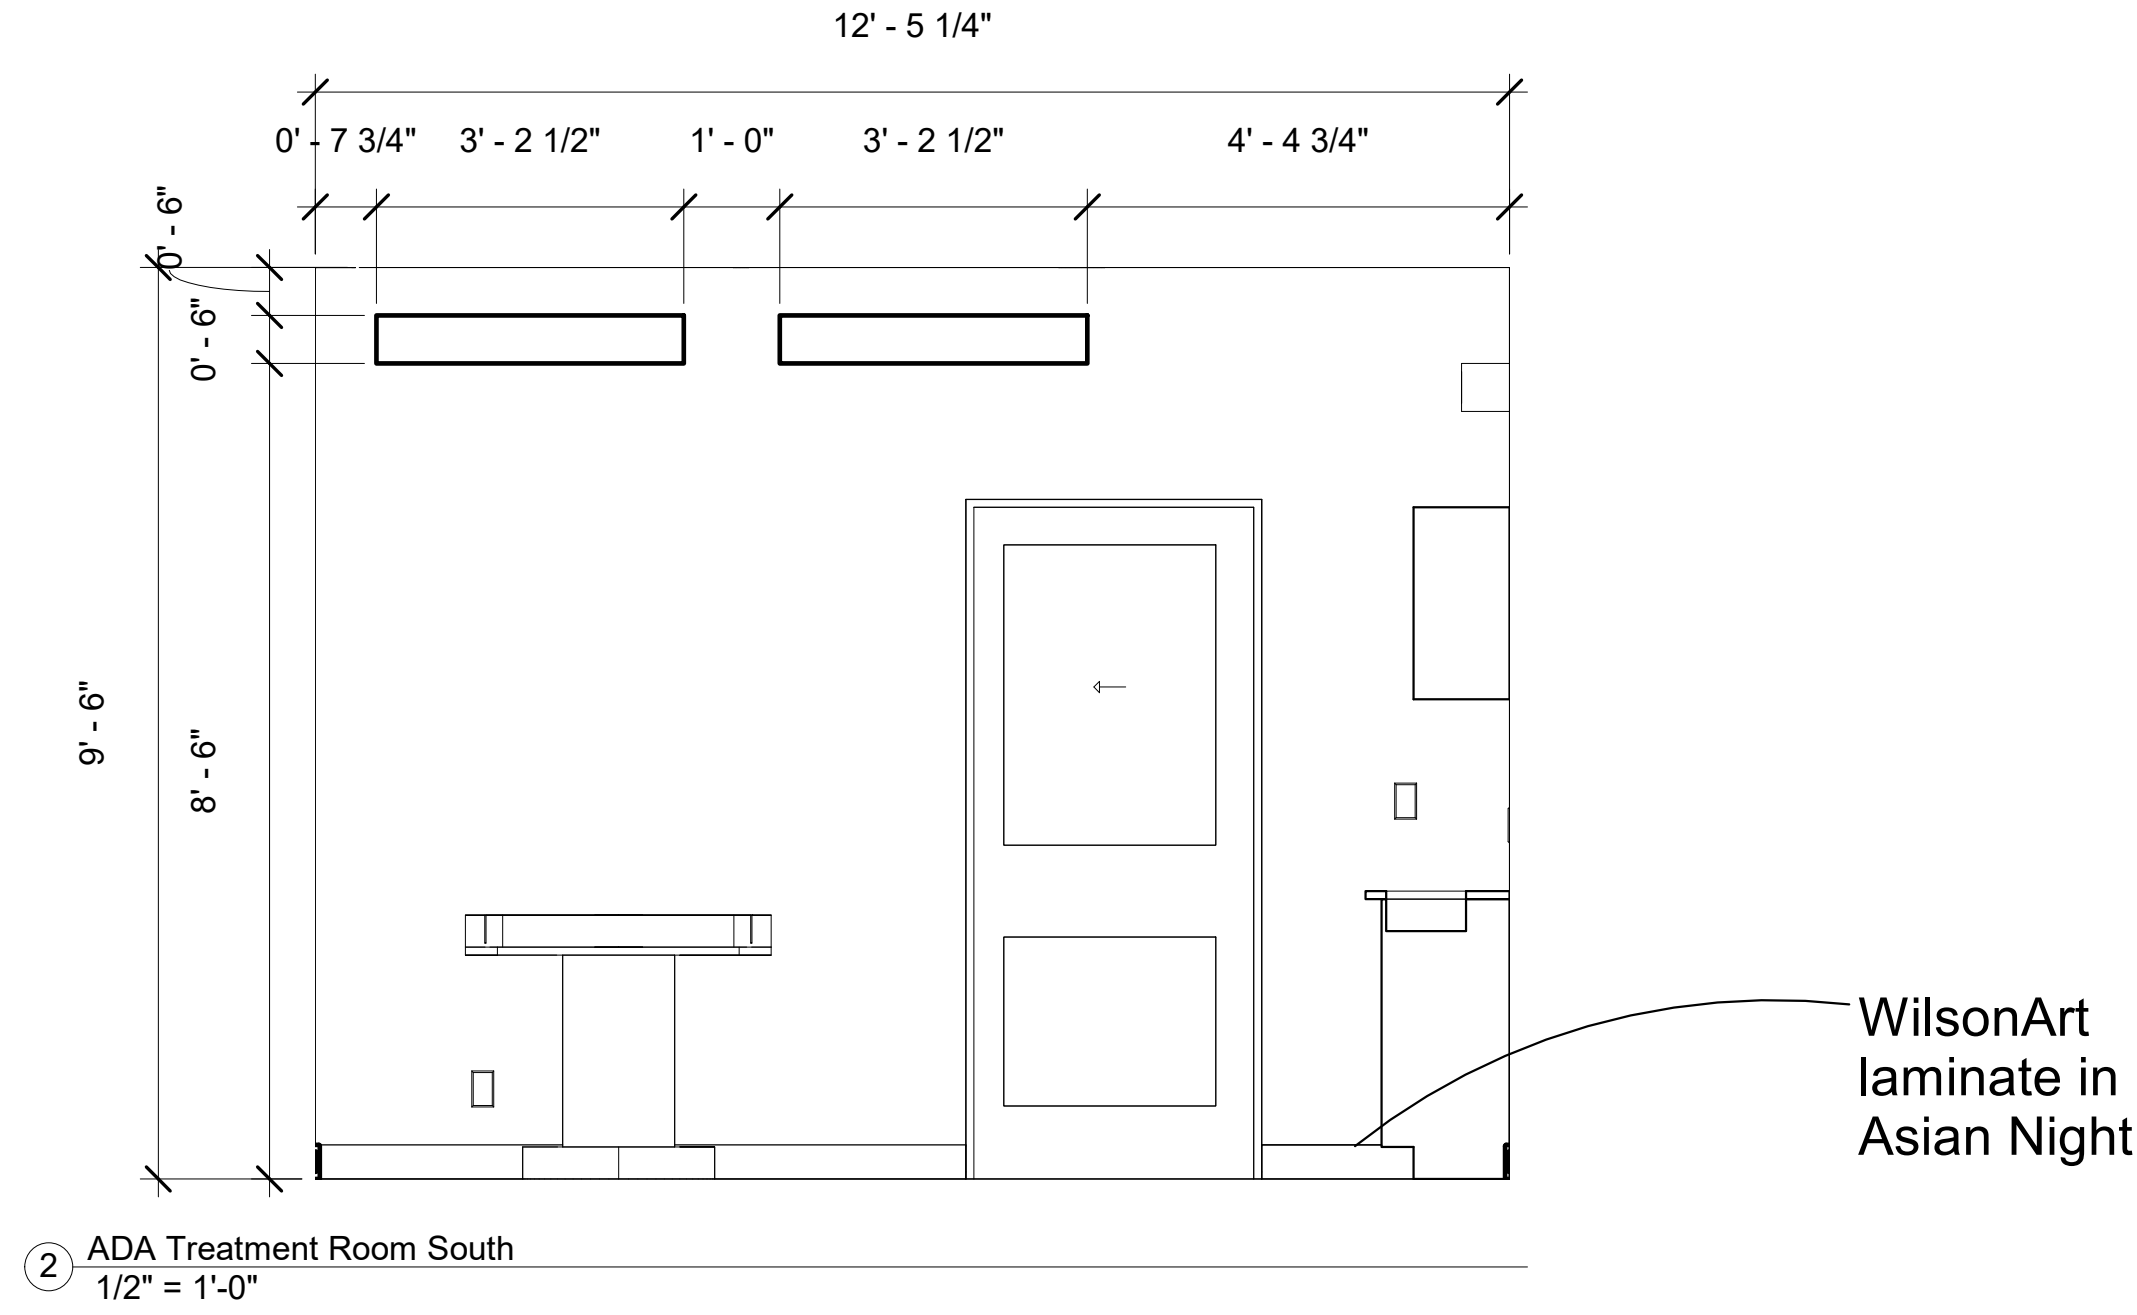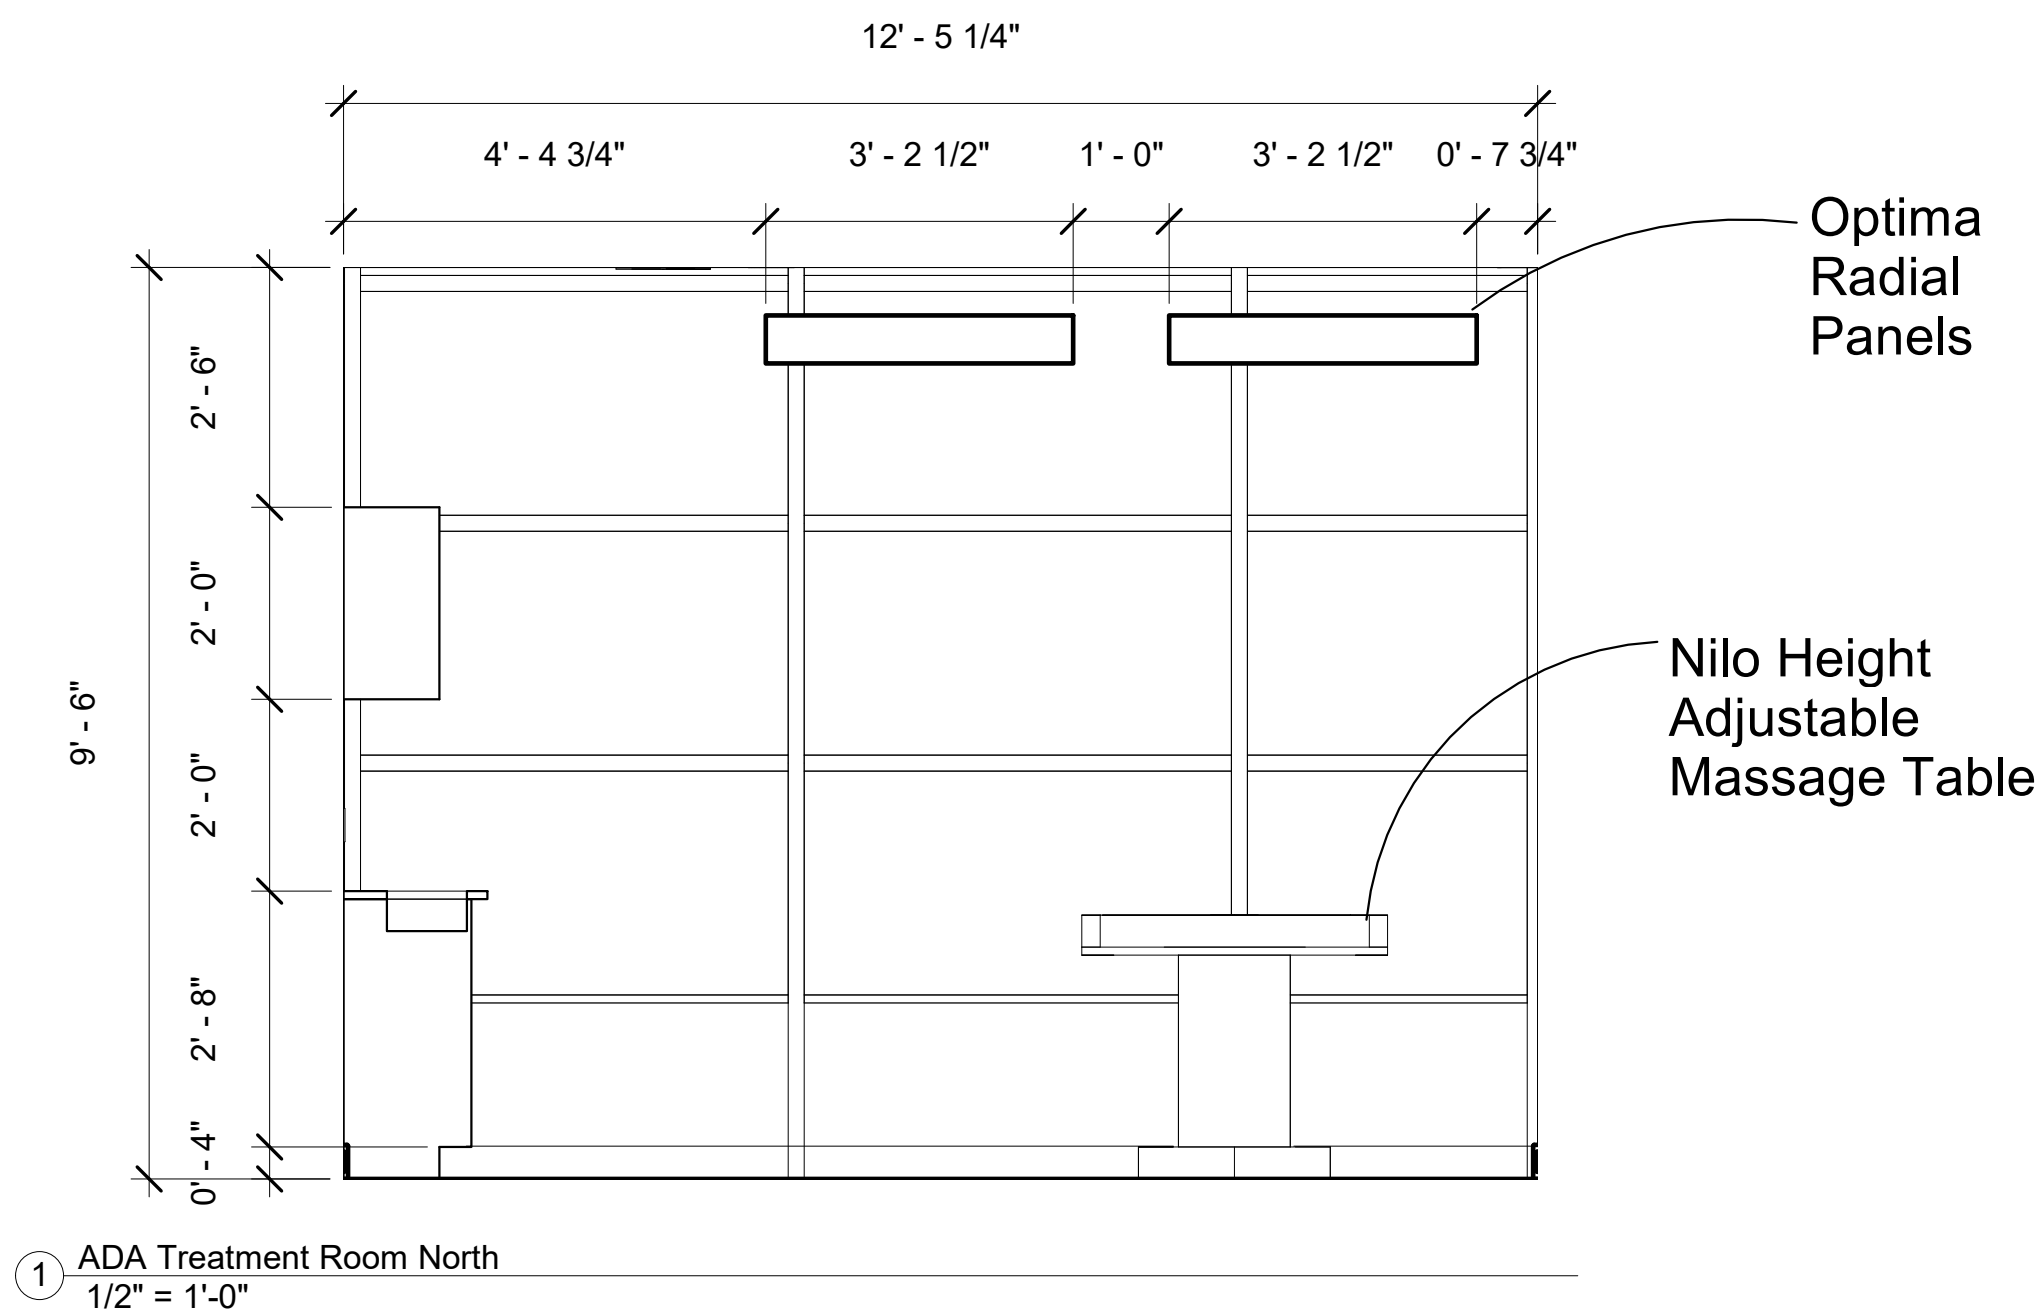


Description	Date

Enlarged Plan ADA Treatment Room	
Date	Issue Date
Drawn by	
Checked by	
ID-6.4	
Scale	As indicated

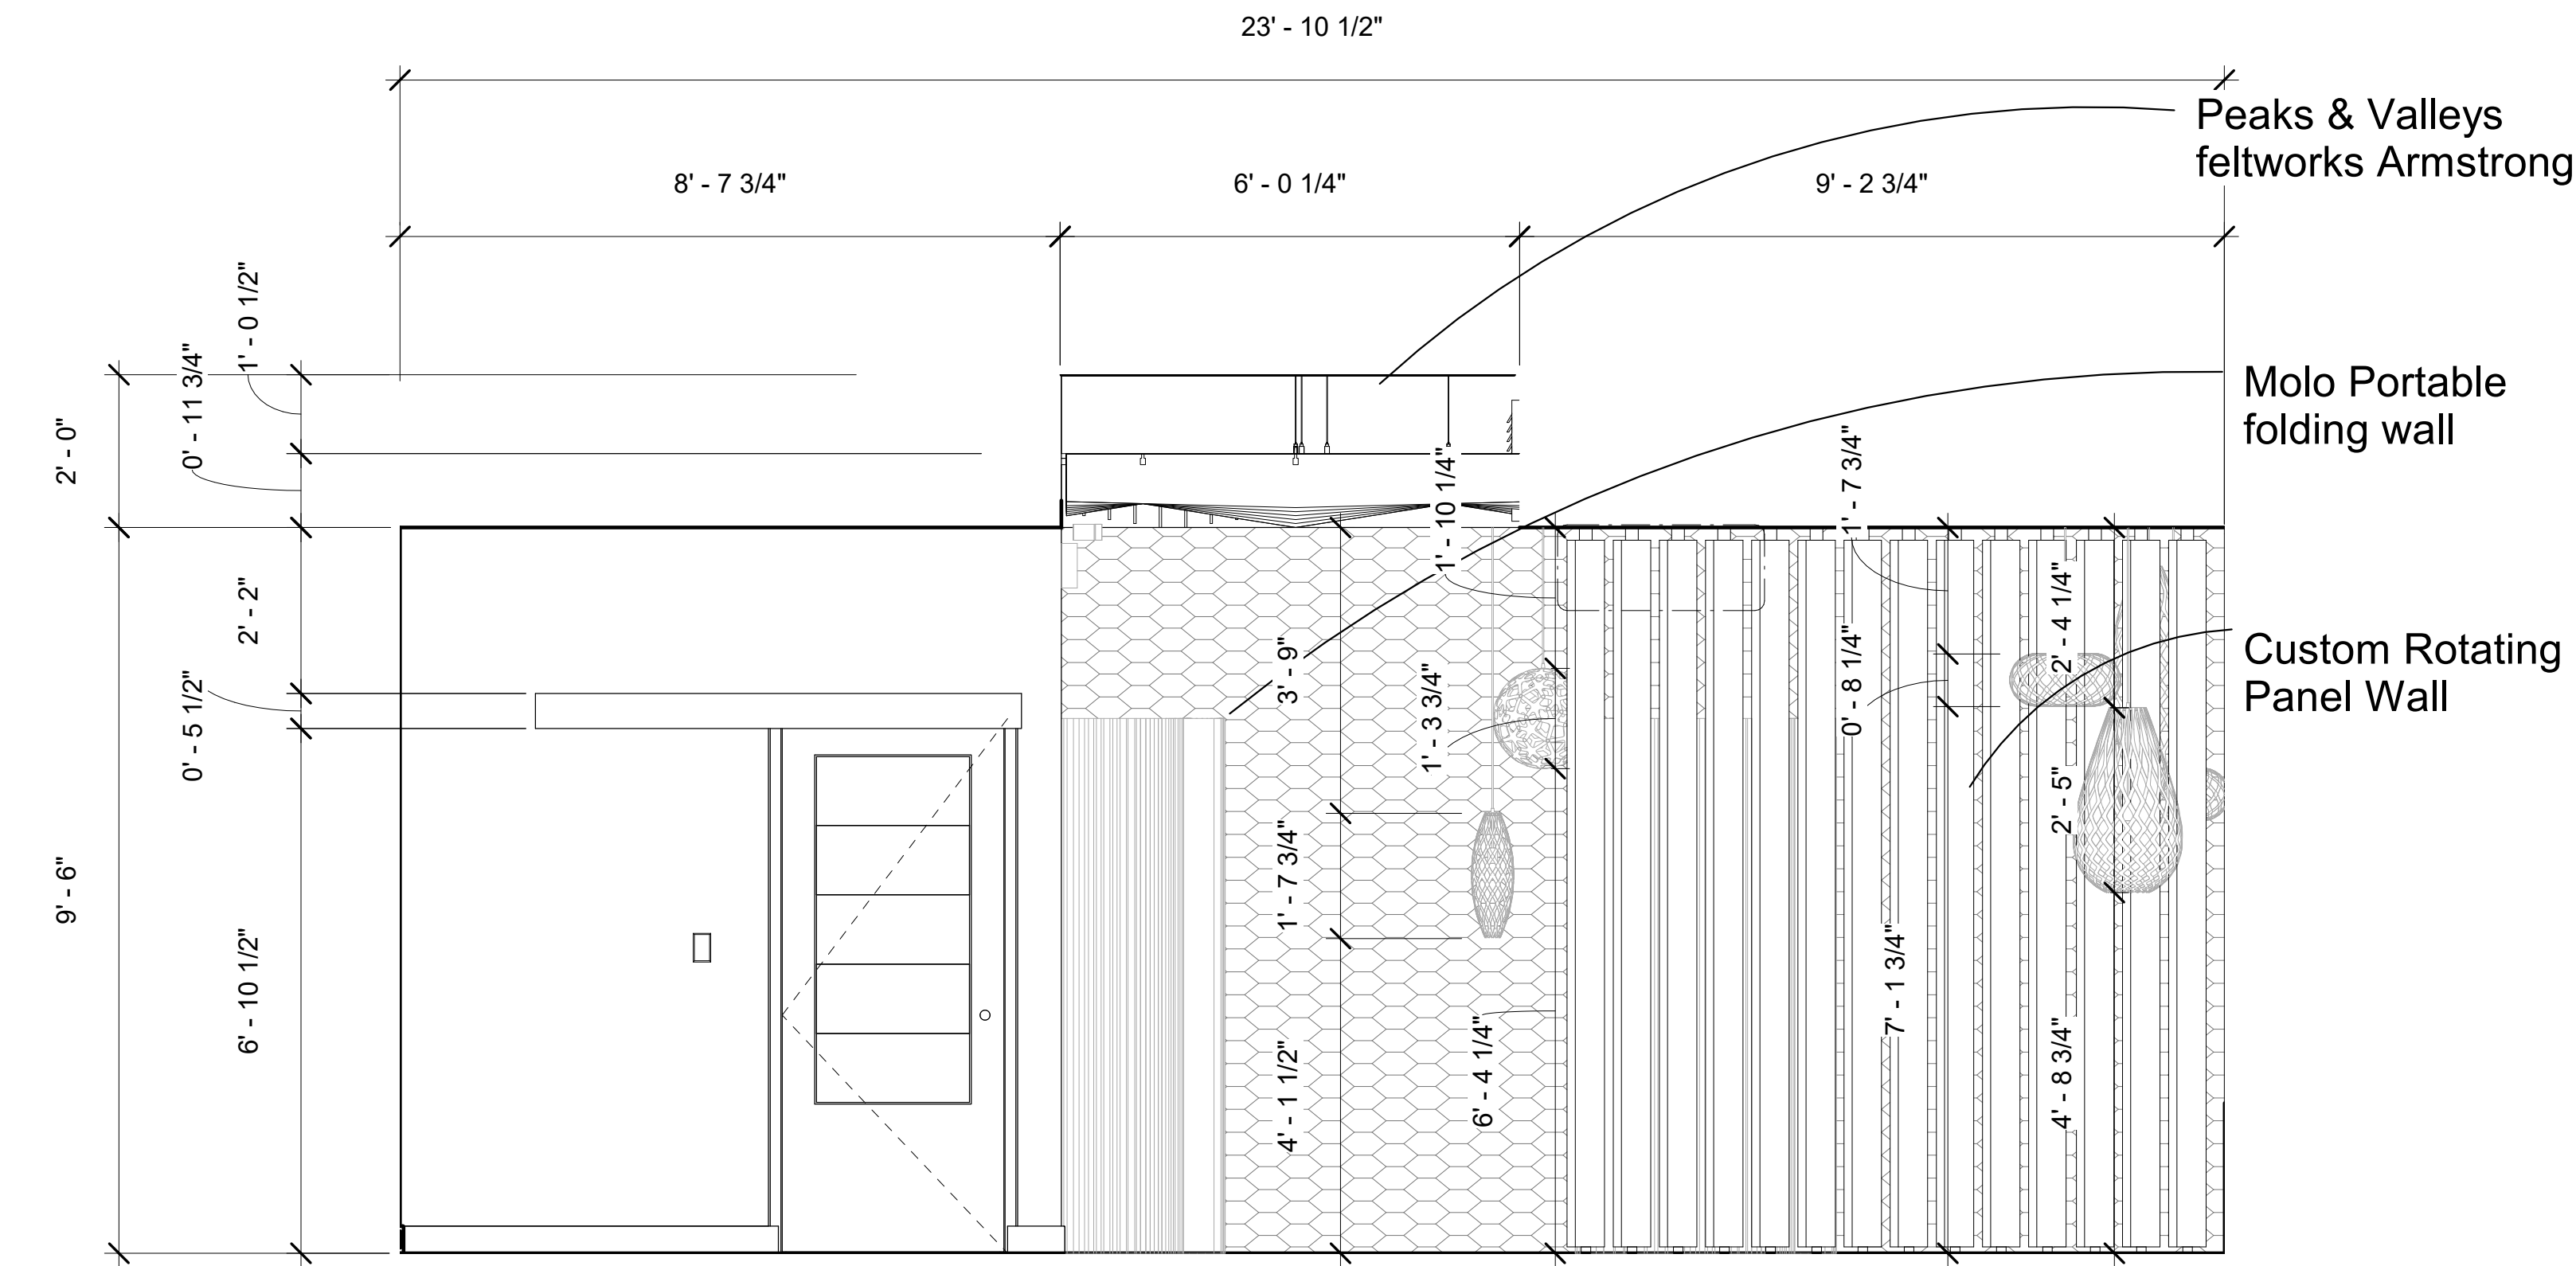

① South Wall Relaxation Suite
1/2" = 1'-0"

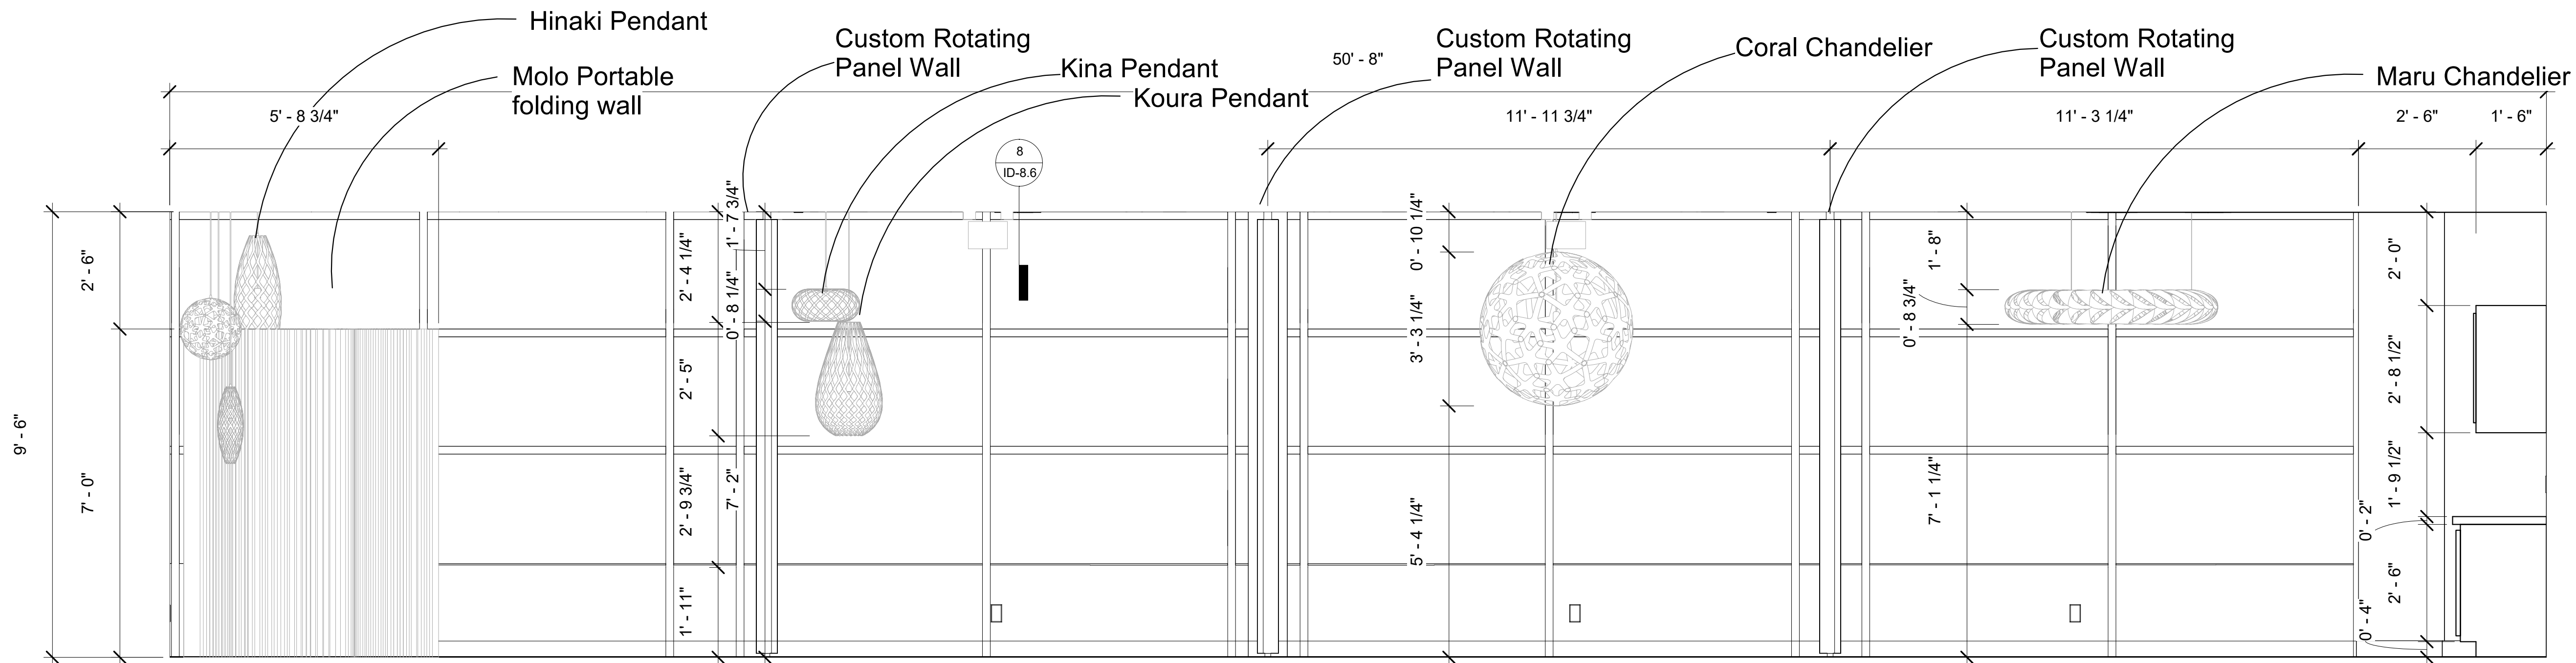

② West Wall Relaxation Suite
1/2" = 1'-0"

KSU
ID

Kylie Arett

Kylie Arett
ID 645
Spring Semester
kkarett@ksu.edu

The Origins Wellness Center
4TH & PIERRE ST. MANHATTAN,
KS. 66502

Description	Date

Elevations
Relaxation
Suite


Date Issue Date

Drawn by


Checked by

ID-7.1


Scale 1/2" = 1'-0"

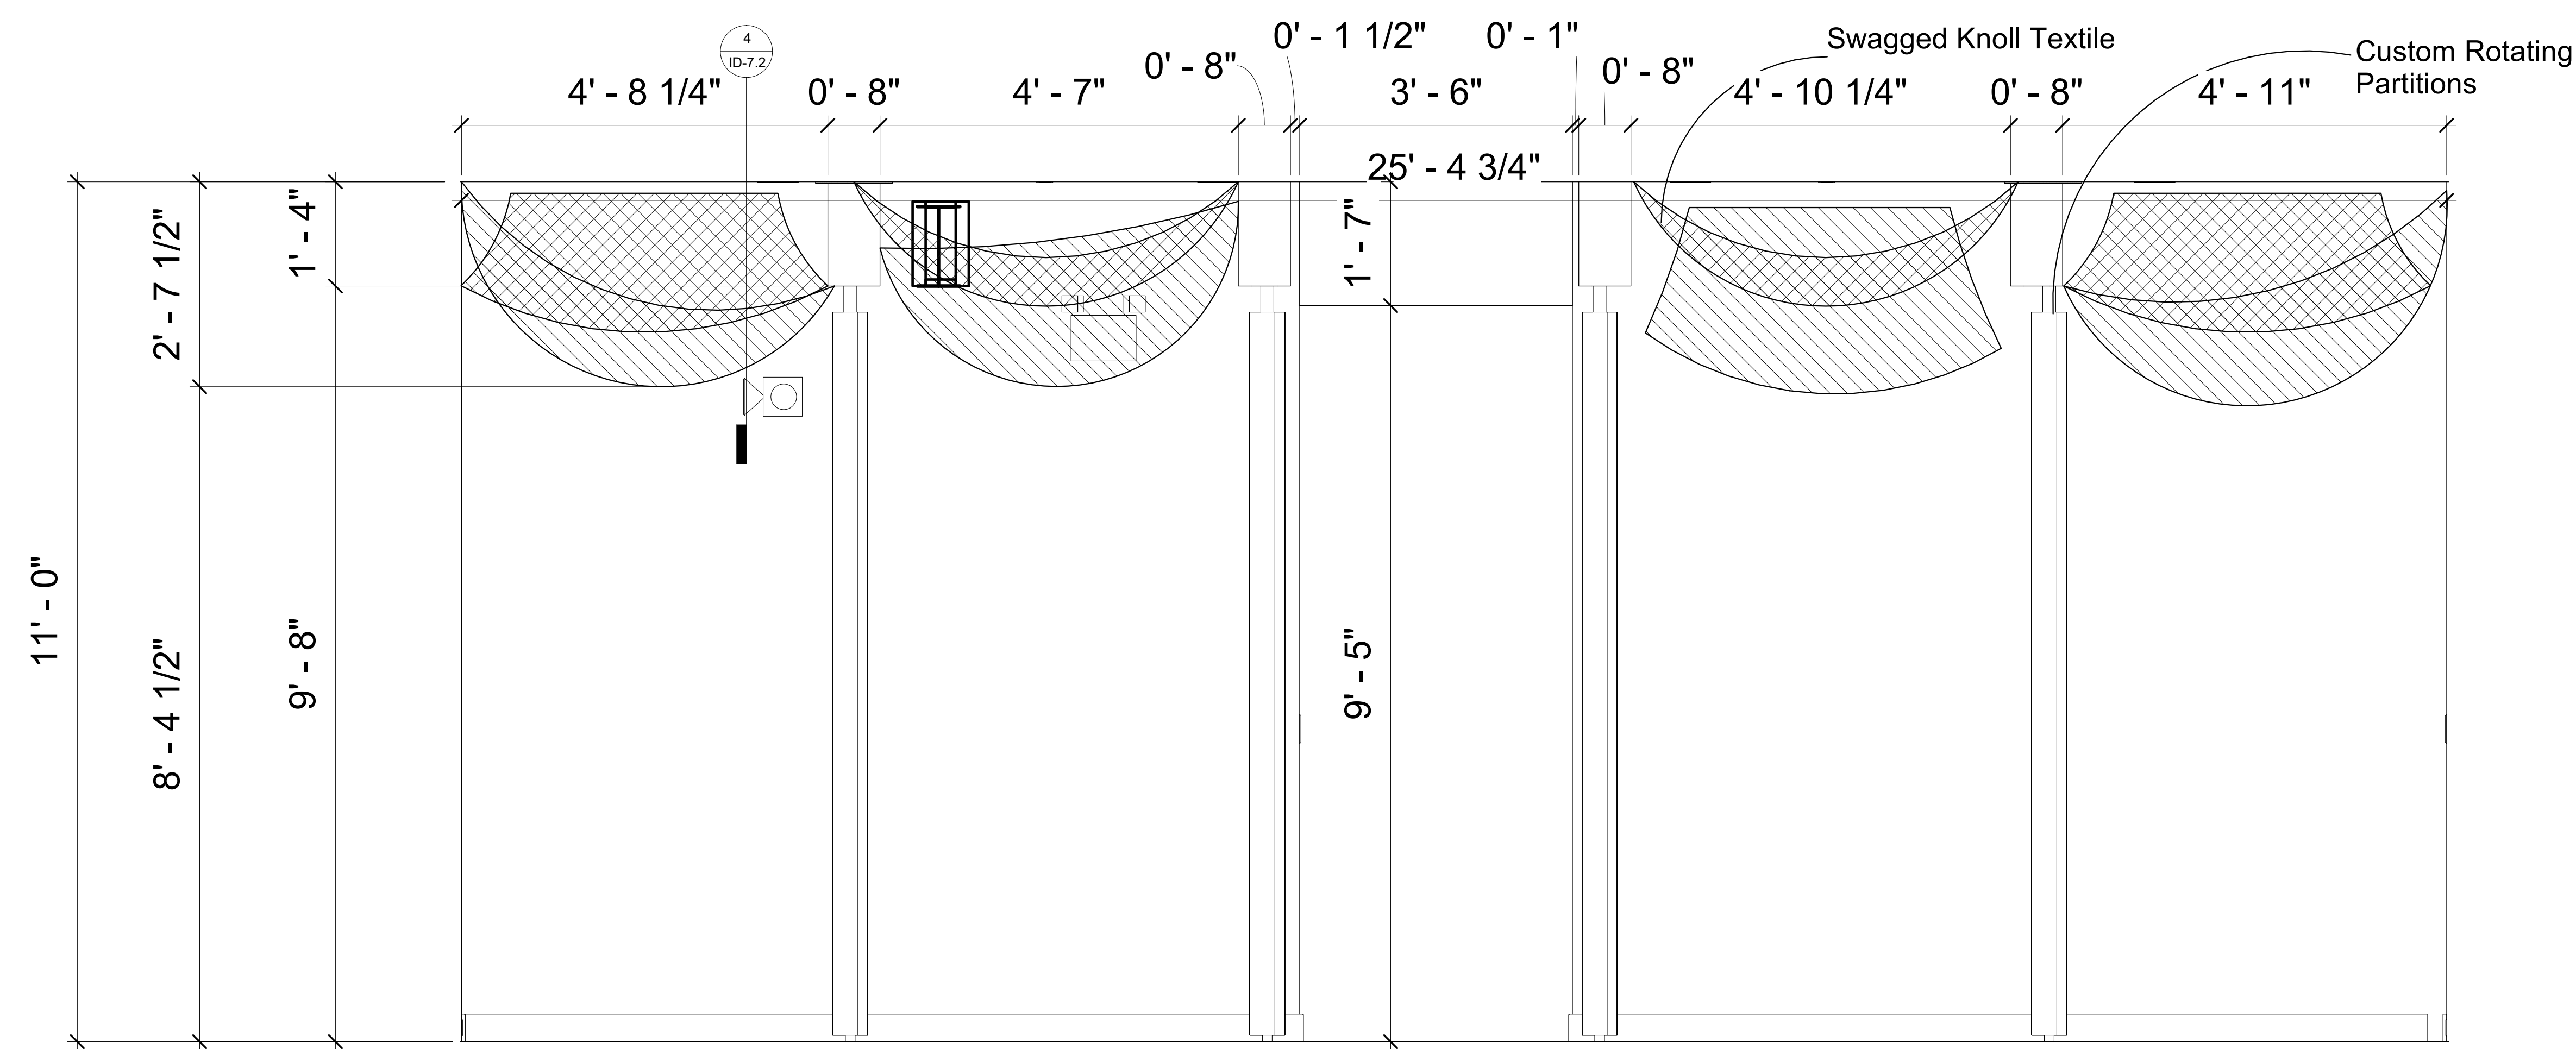

① Decompression Zone- West Wall
3/4" = 1'-0"

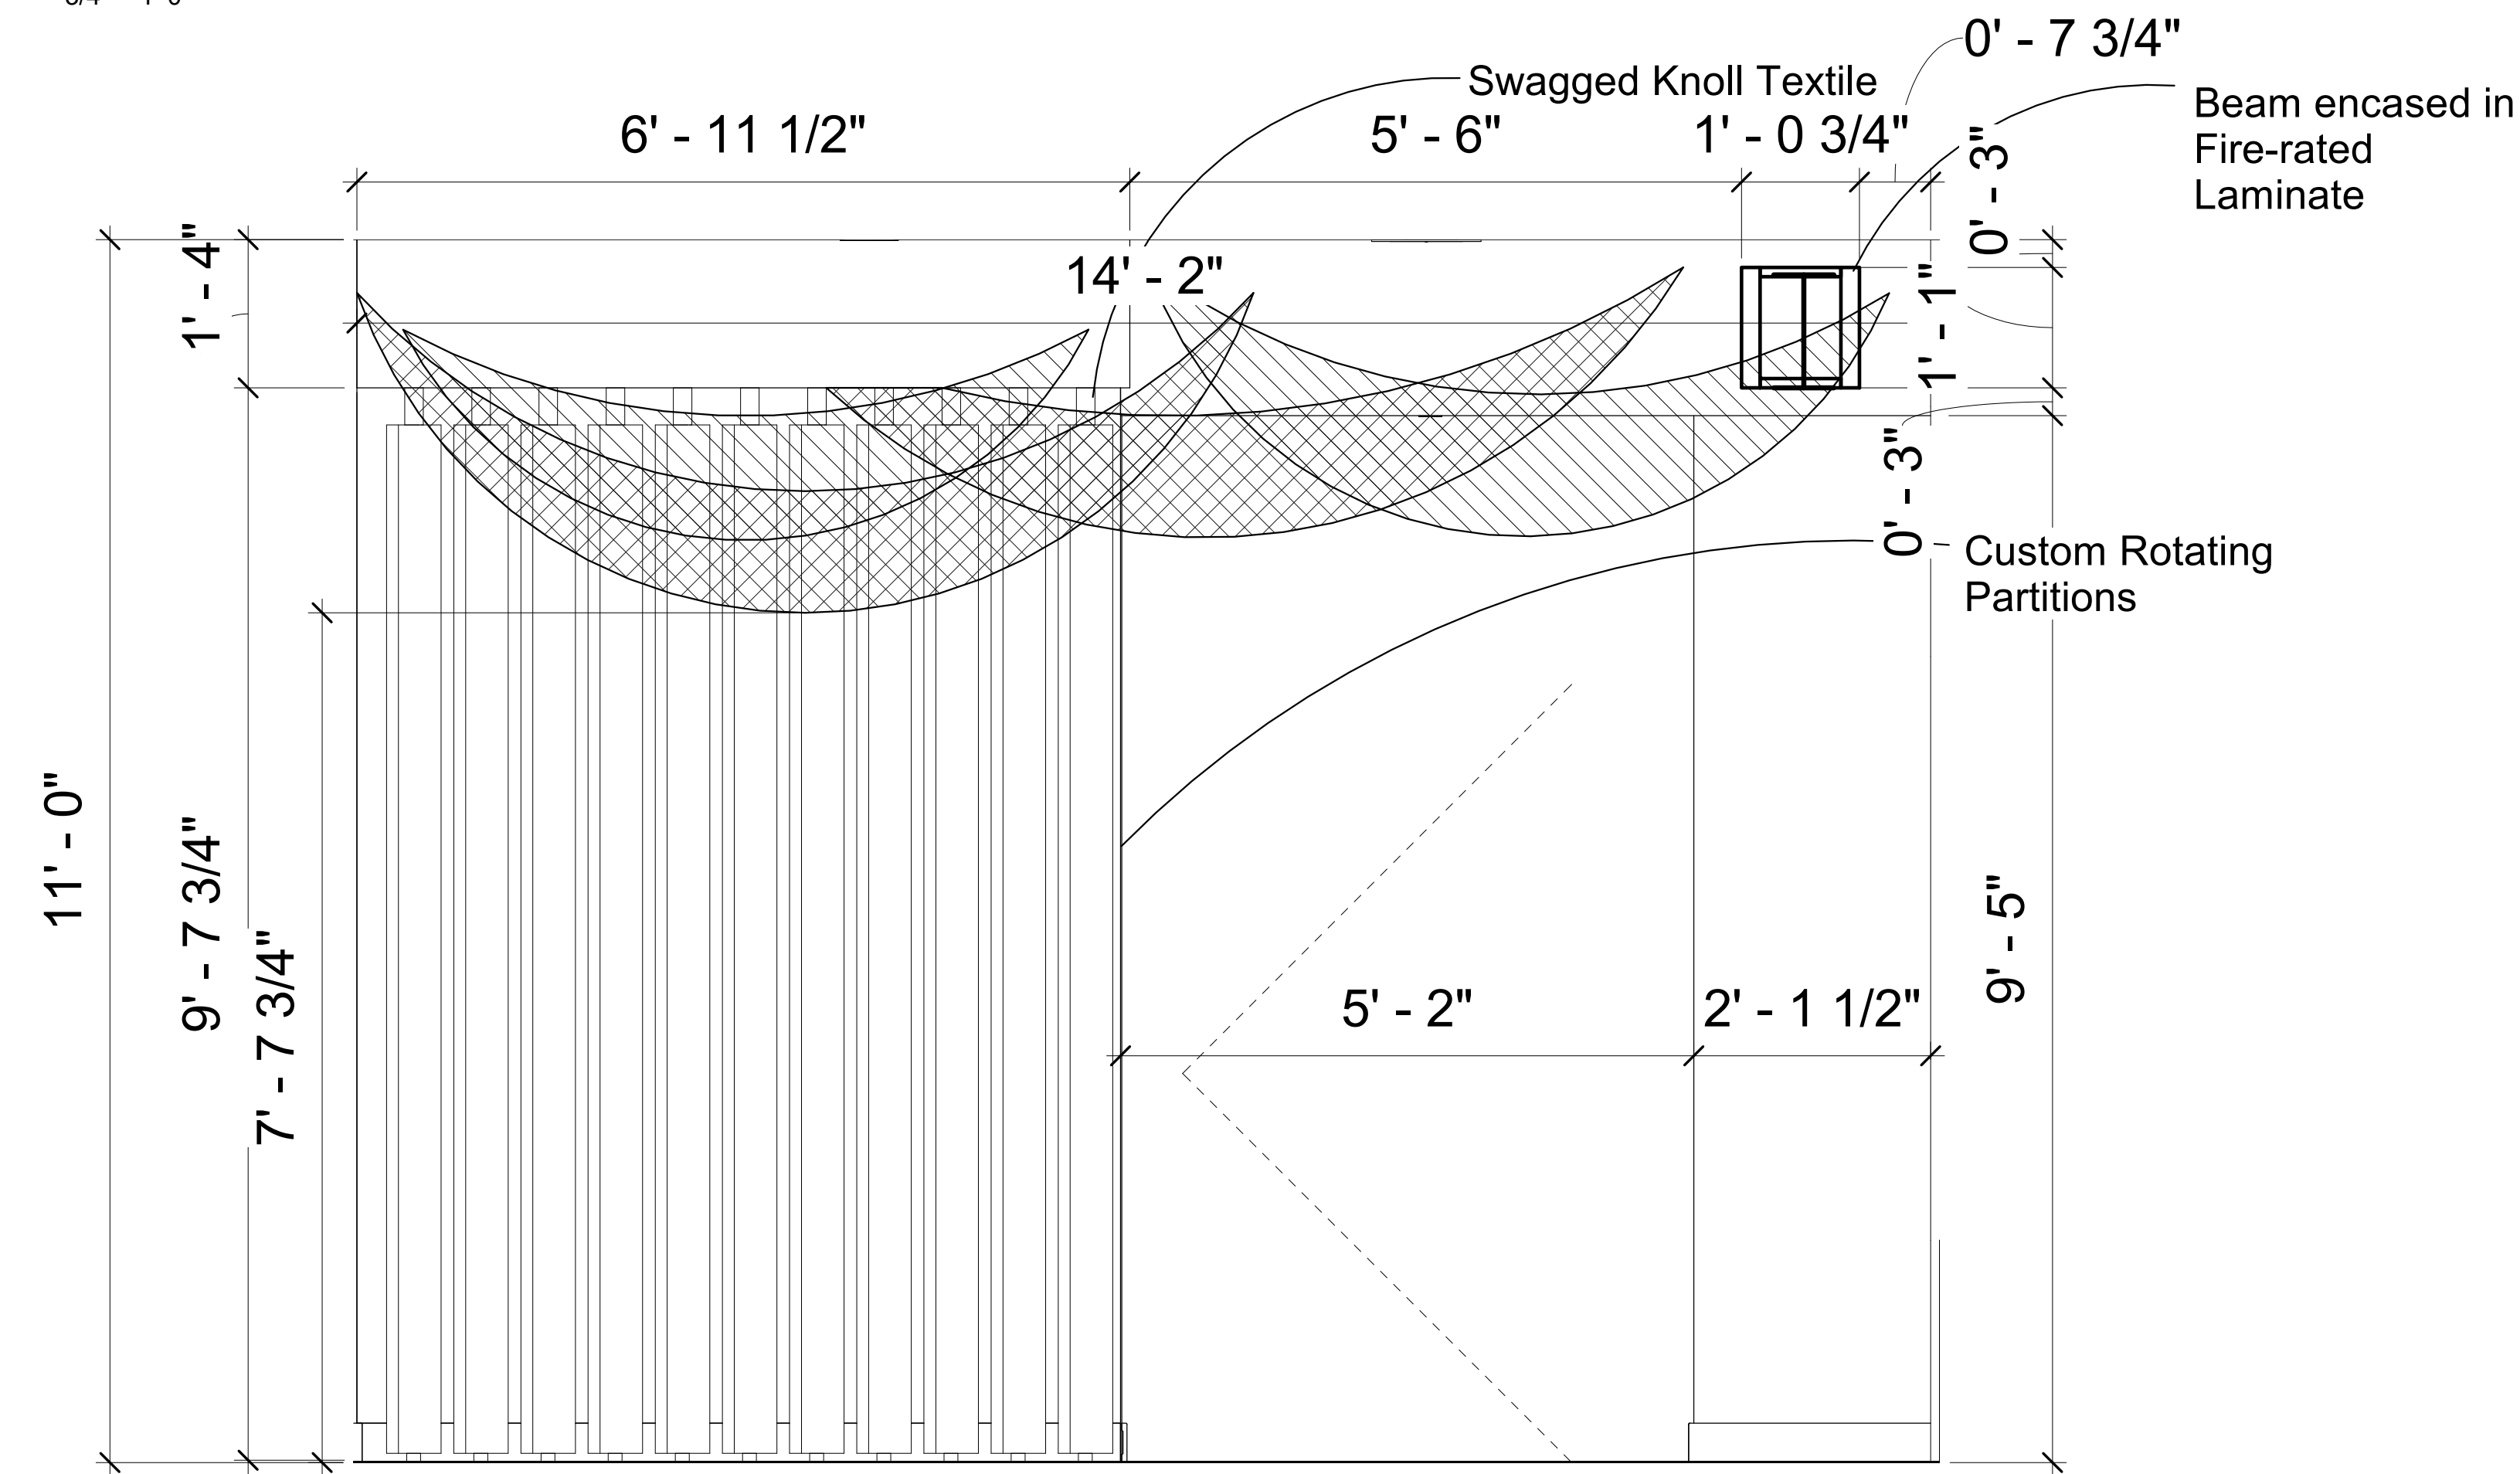

② Decompression Zone- North Wall
3/4" = 1'-0"

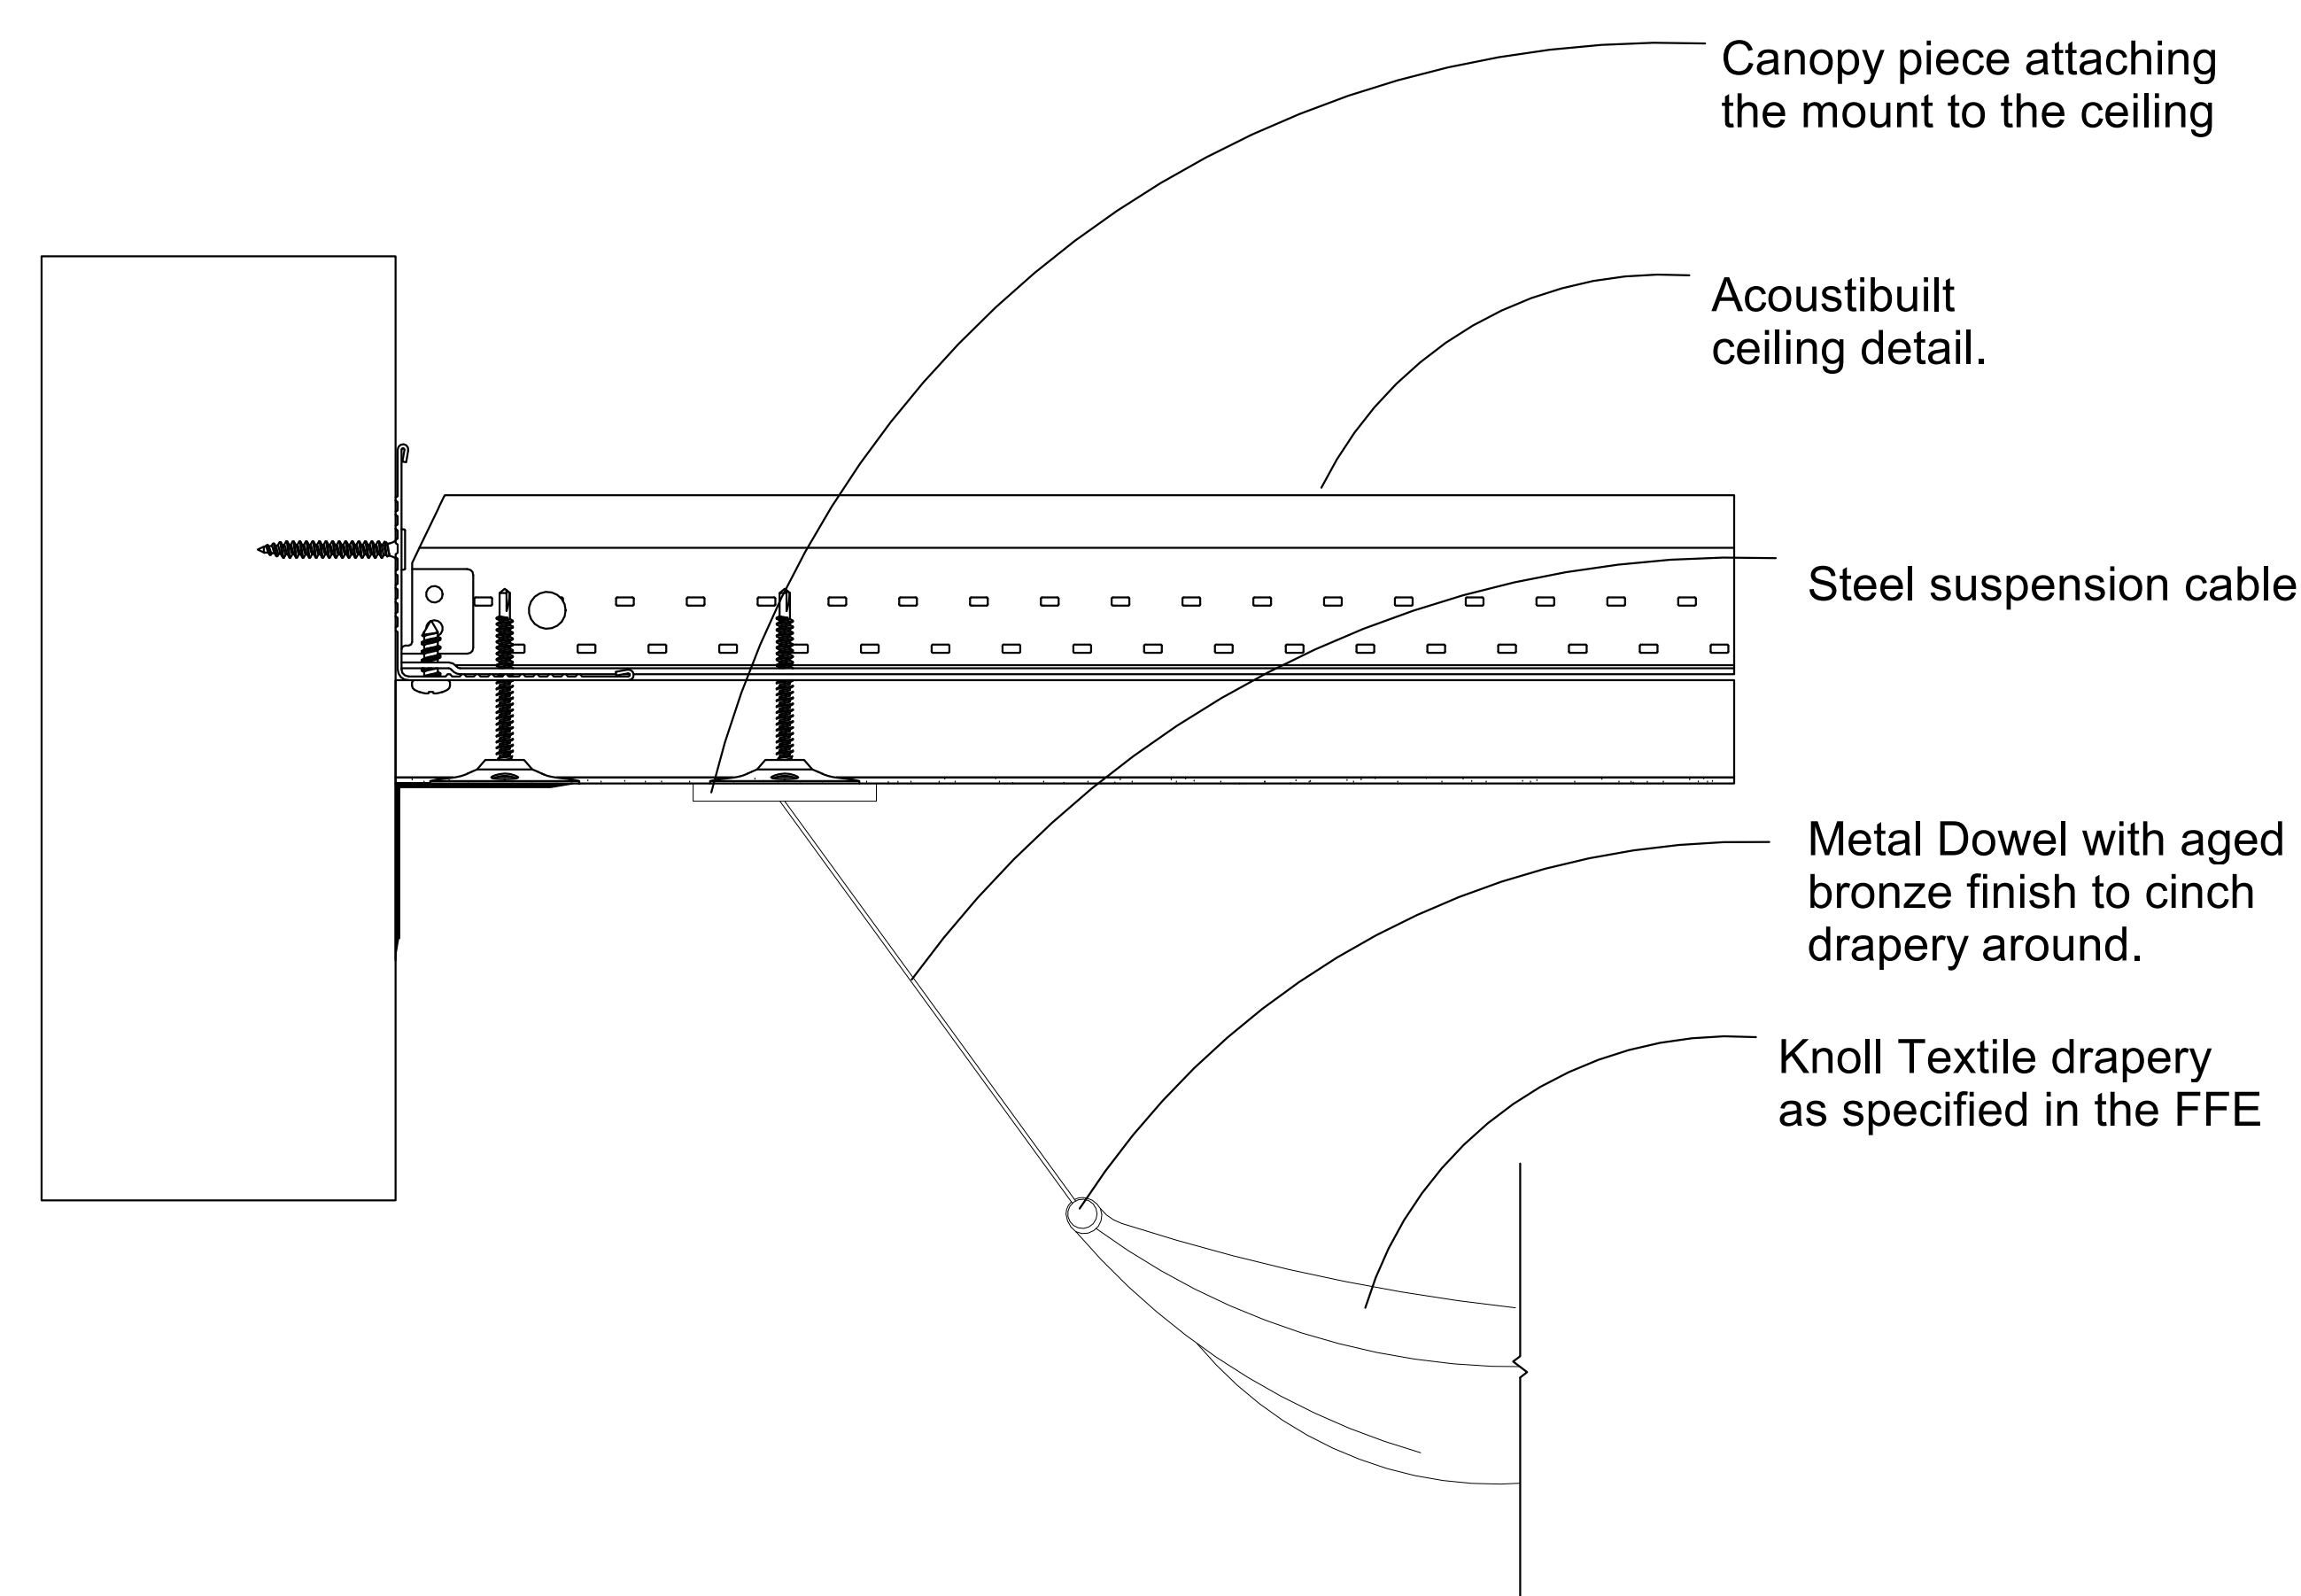

③ Swag Detail
1/2" = 1'-0"

KSU
ID

Kylie Arett

Kylie Arett
ID 645
Spring Semester
kkarett@ksu.edu

The Origins Wellness Center
4TH & PIERRE ST. MANHATTAN,
KS. 66502


Description	Date

Elevations
Decompression
Zone


Date Issue Date
Drawn by
Checked by

ID-7.2


Scale As indicated

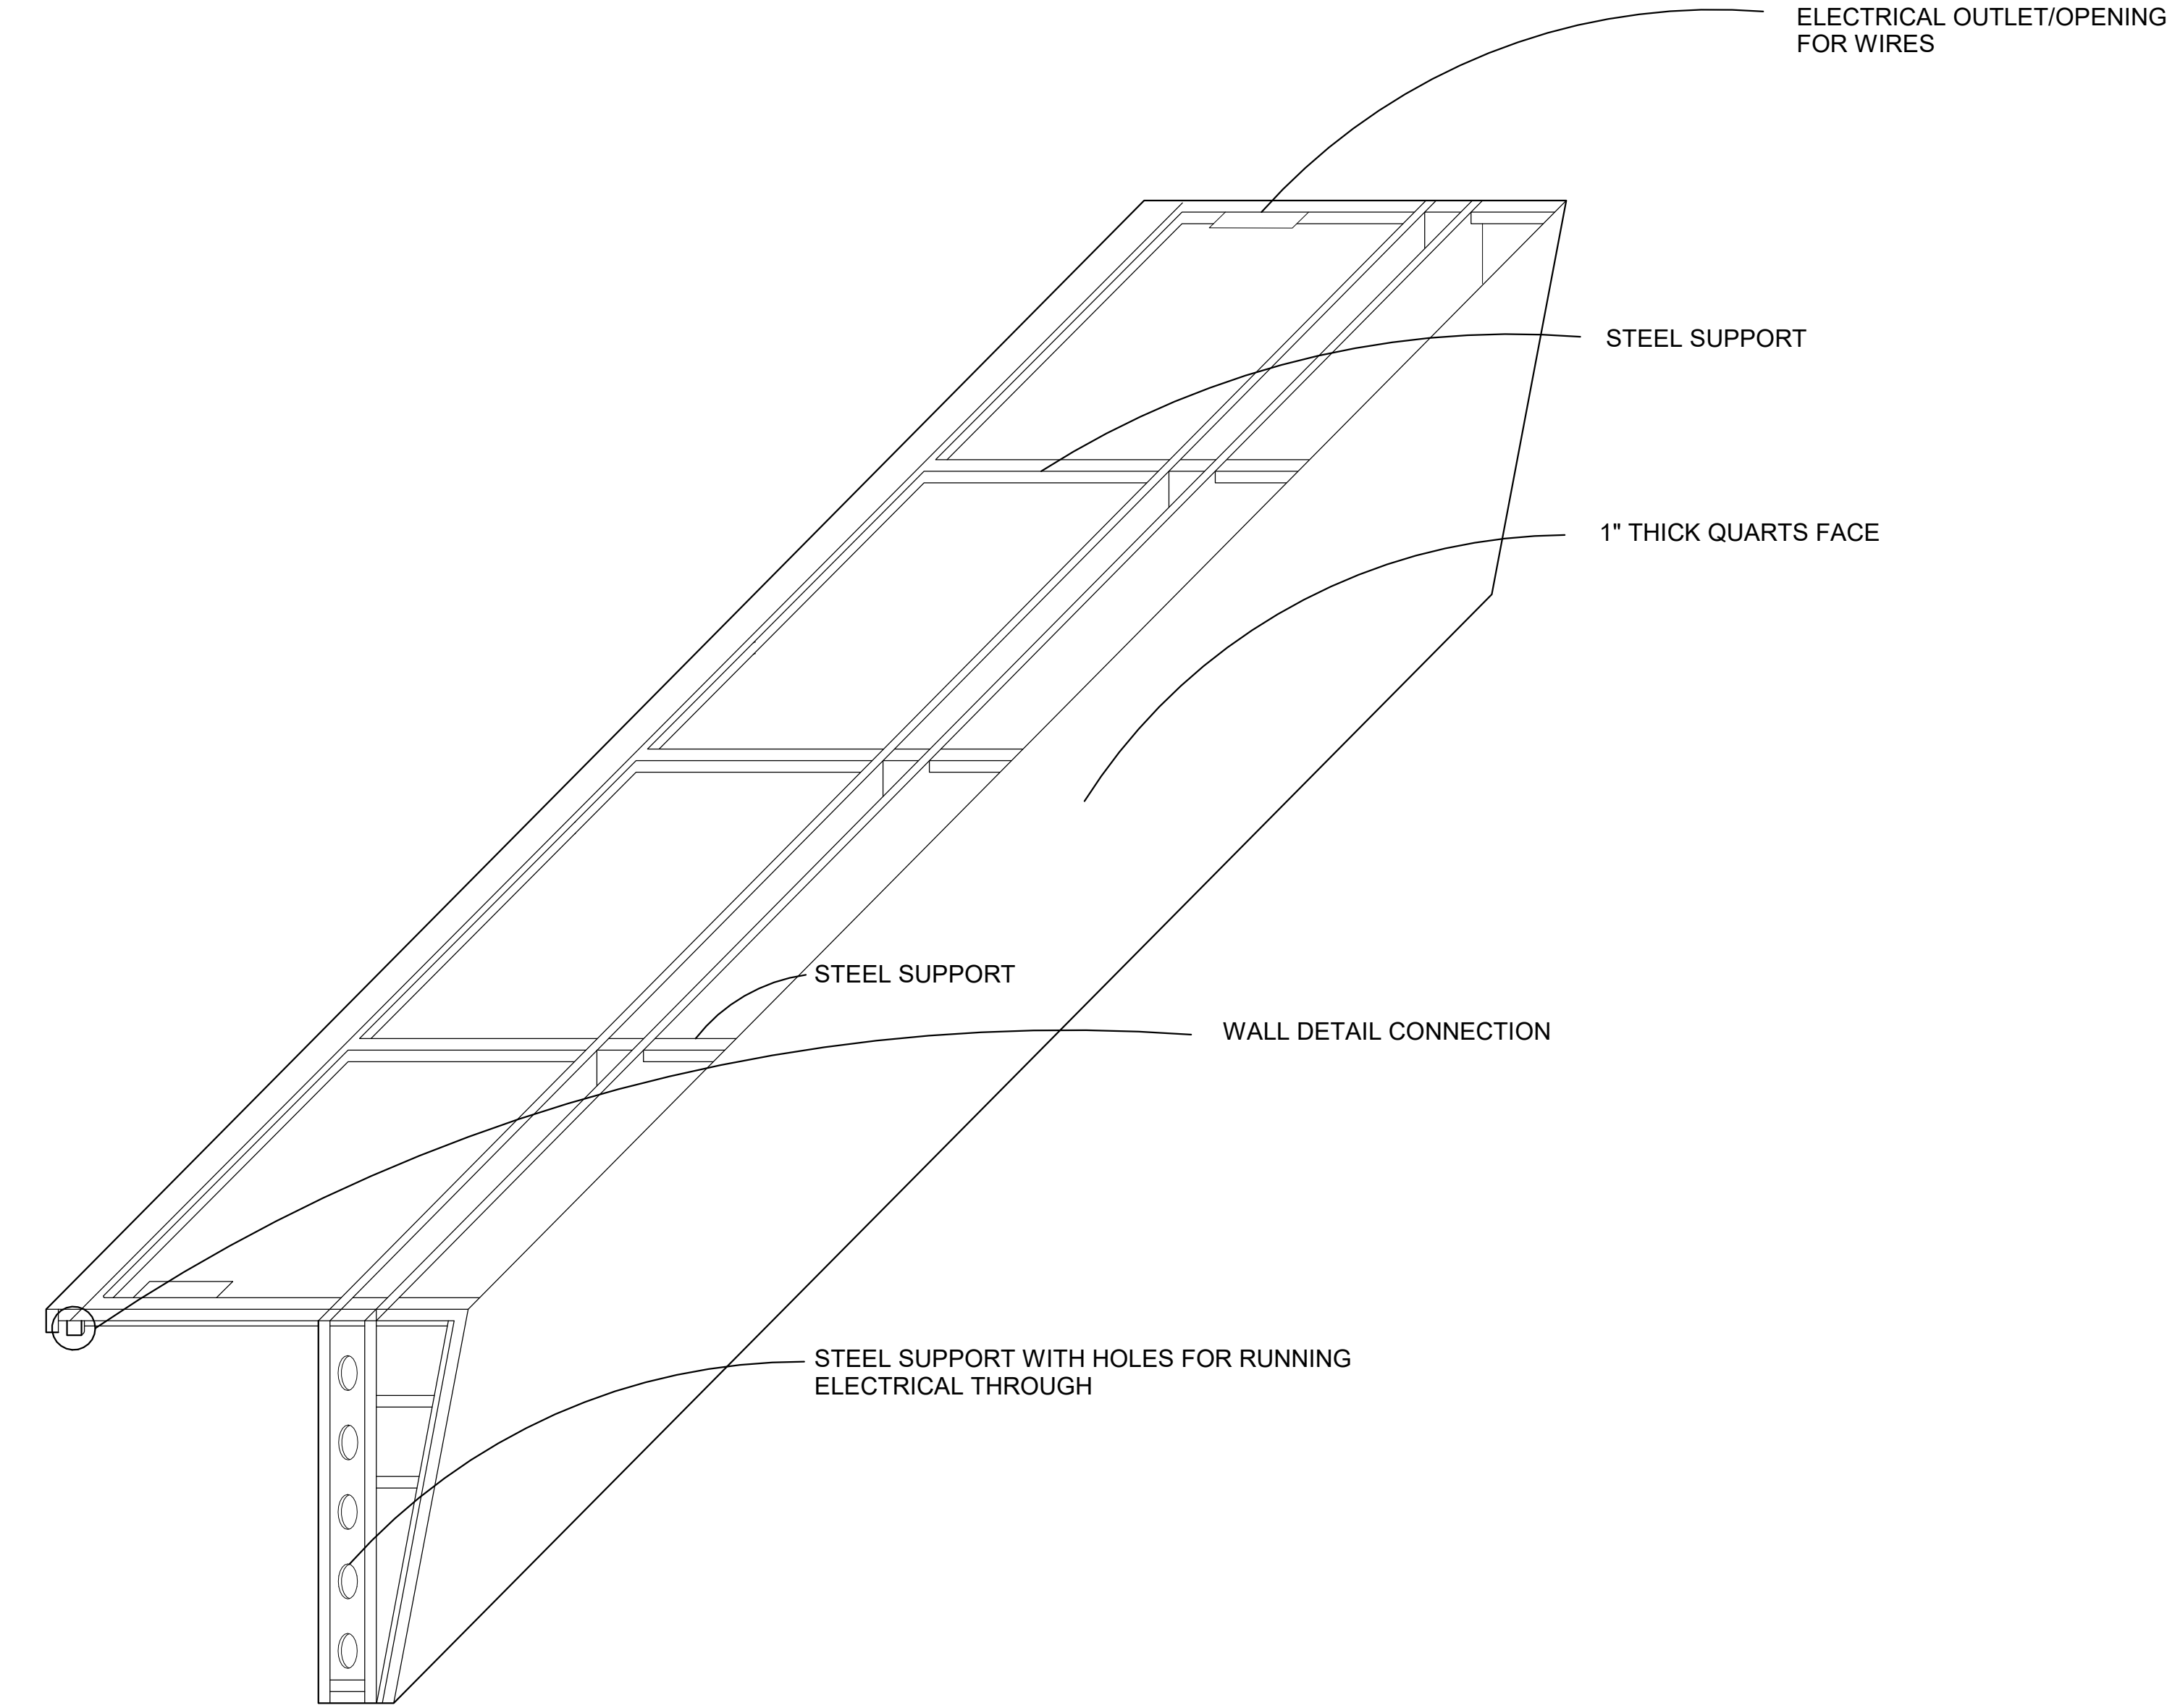

① Reception Desk Structure Detail
1" = 1'-0"

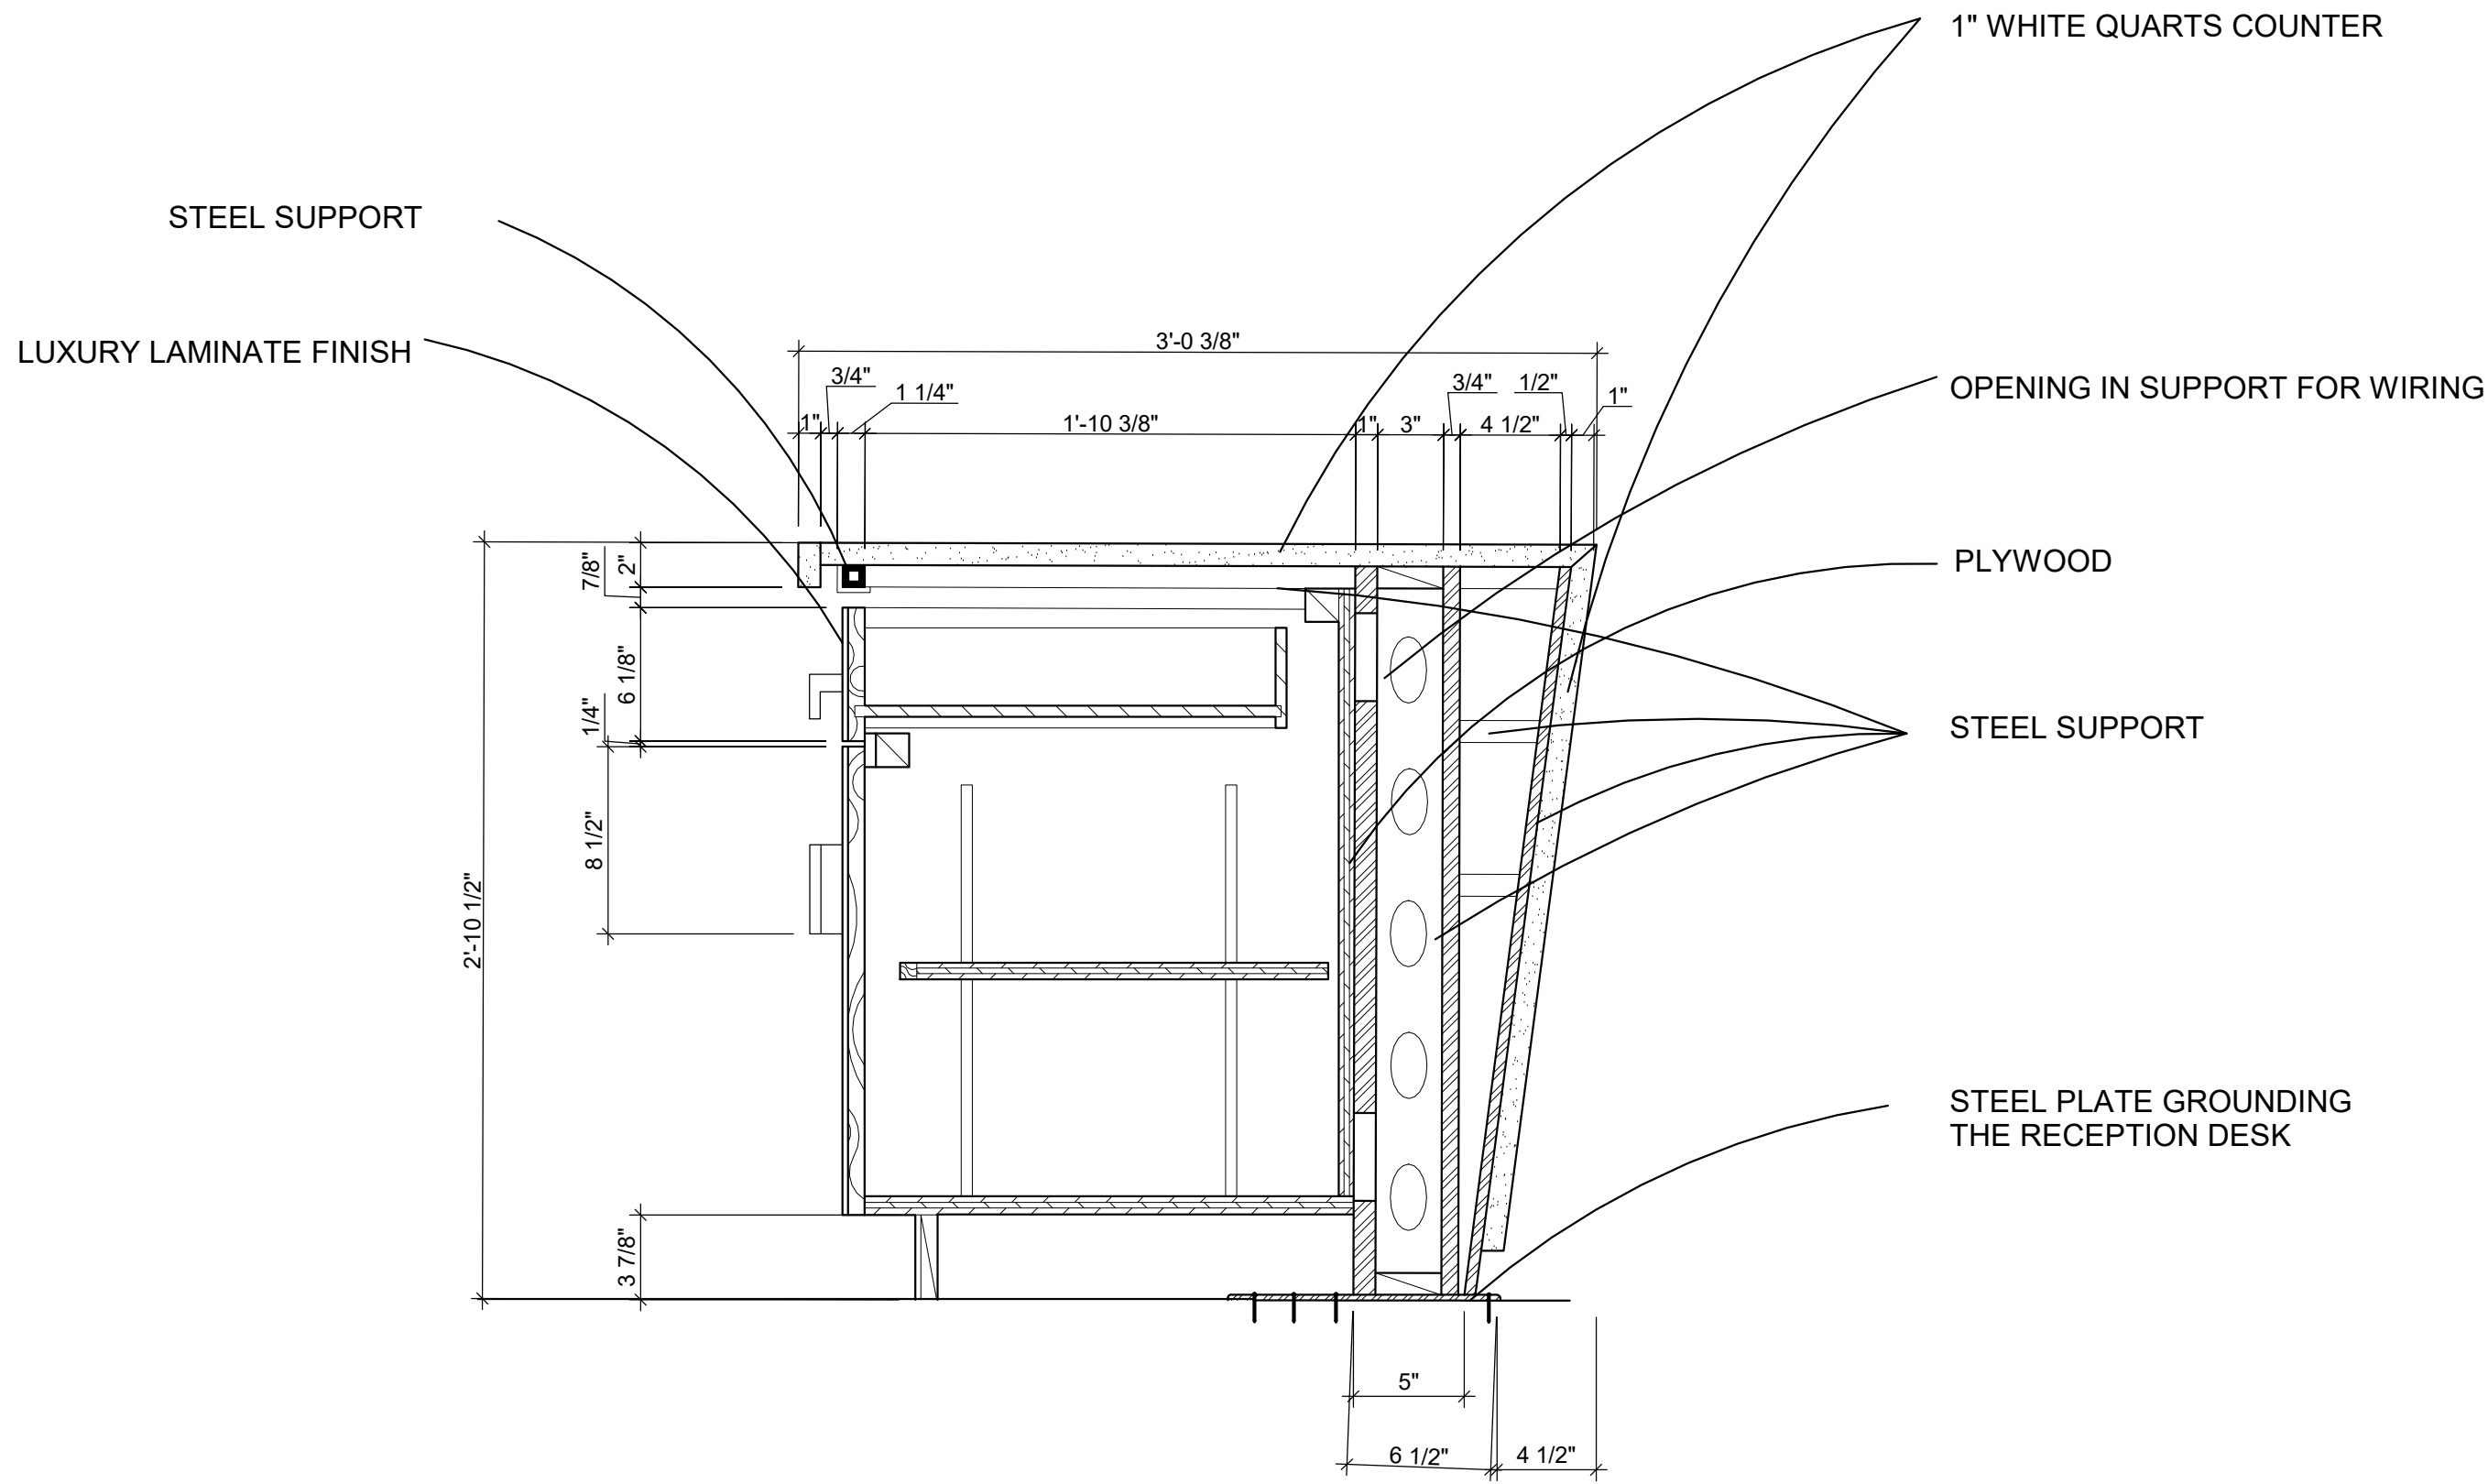

② Reception Casework Detail
1 1/2" = 1'-0"

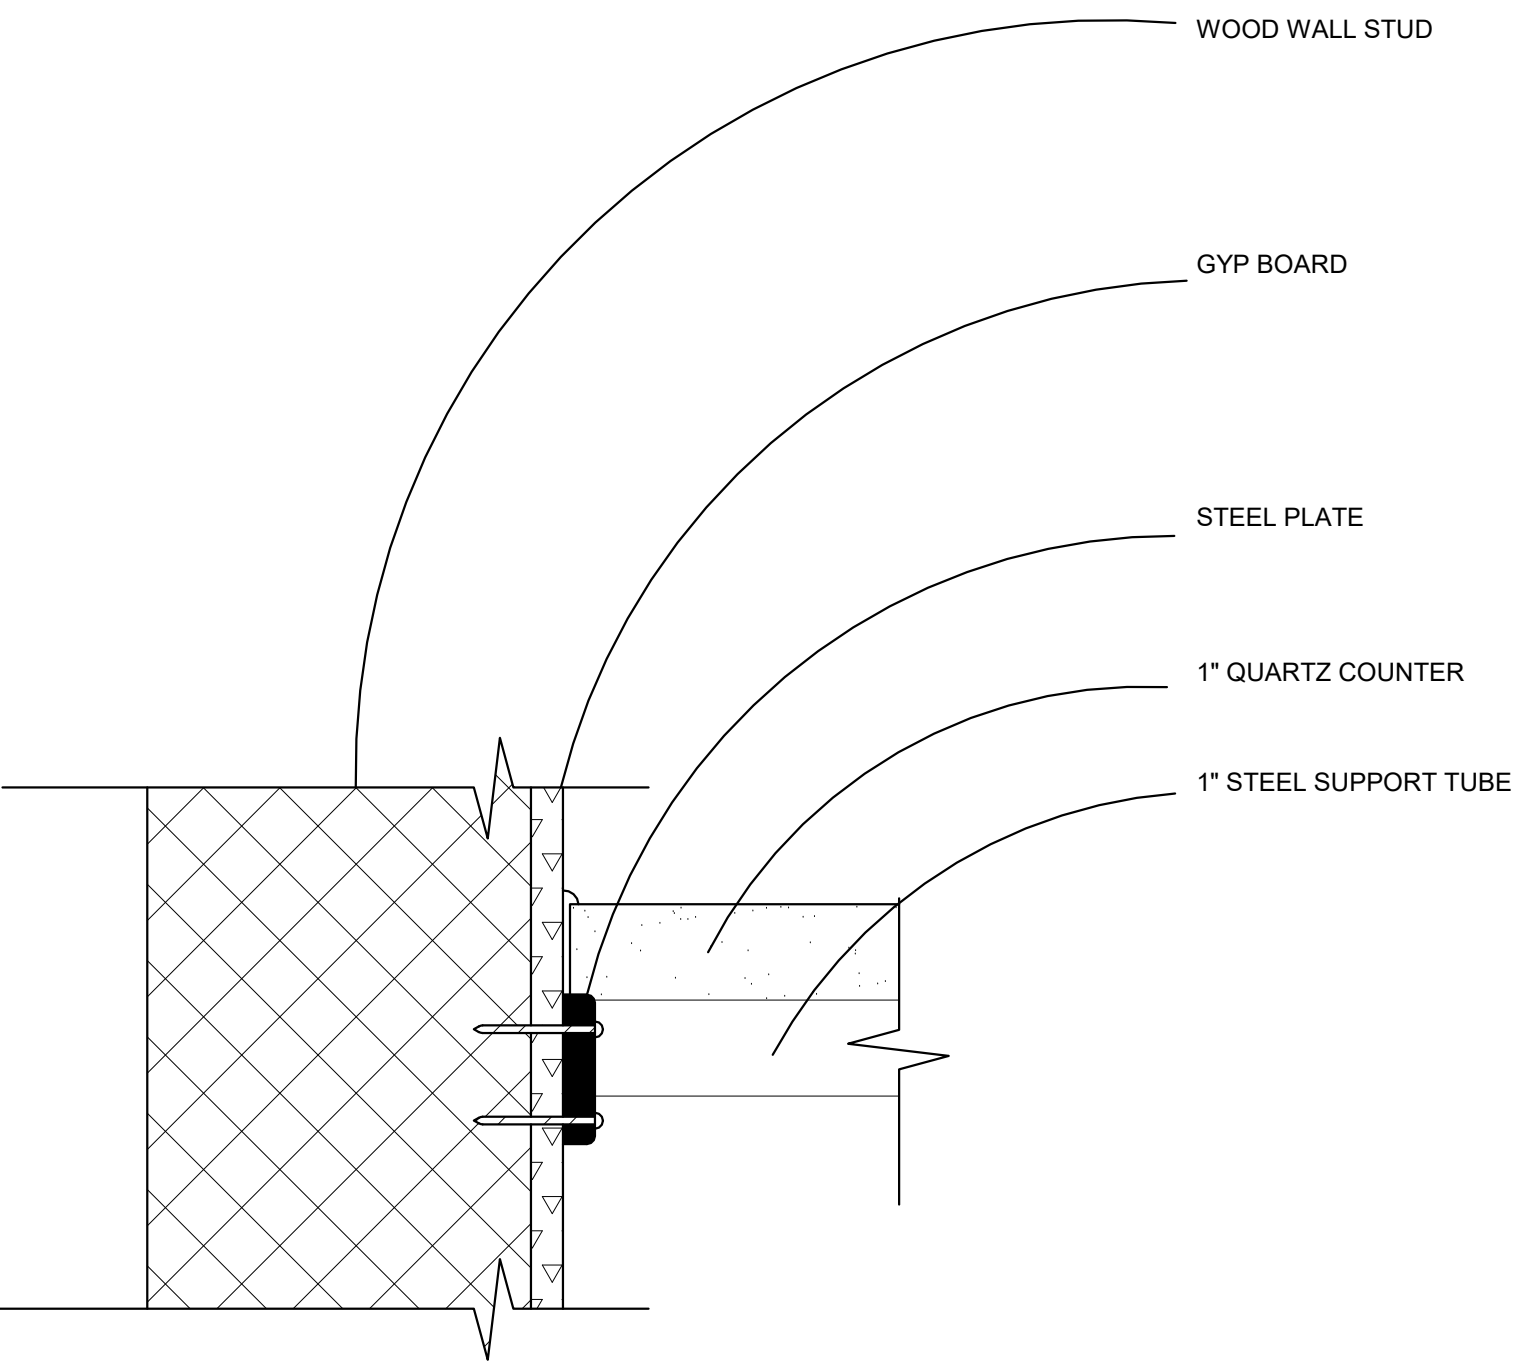

③ Reception Wall Detail
6" = 1'-0"

GENERAL NOTES

1. CHECK WITH STRUCTURAL ENGINEER TO ENSURE THE CONSTRUCTION IS CORRECT.

KSU
ID

Kylie Arett

Kylie Arett
ID 645
Spring Semester
kkarett@ksu.edu

The Origins Wellness Center
4TH & PIERRE ST. MANHATTAN,
KS. 66502

Description	Date

Details
Reception
Desk



Date Issue Date

Drawn by

Checked by


ID-8.1

Scale As indicated

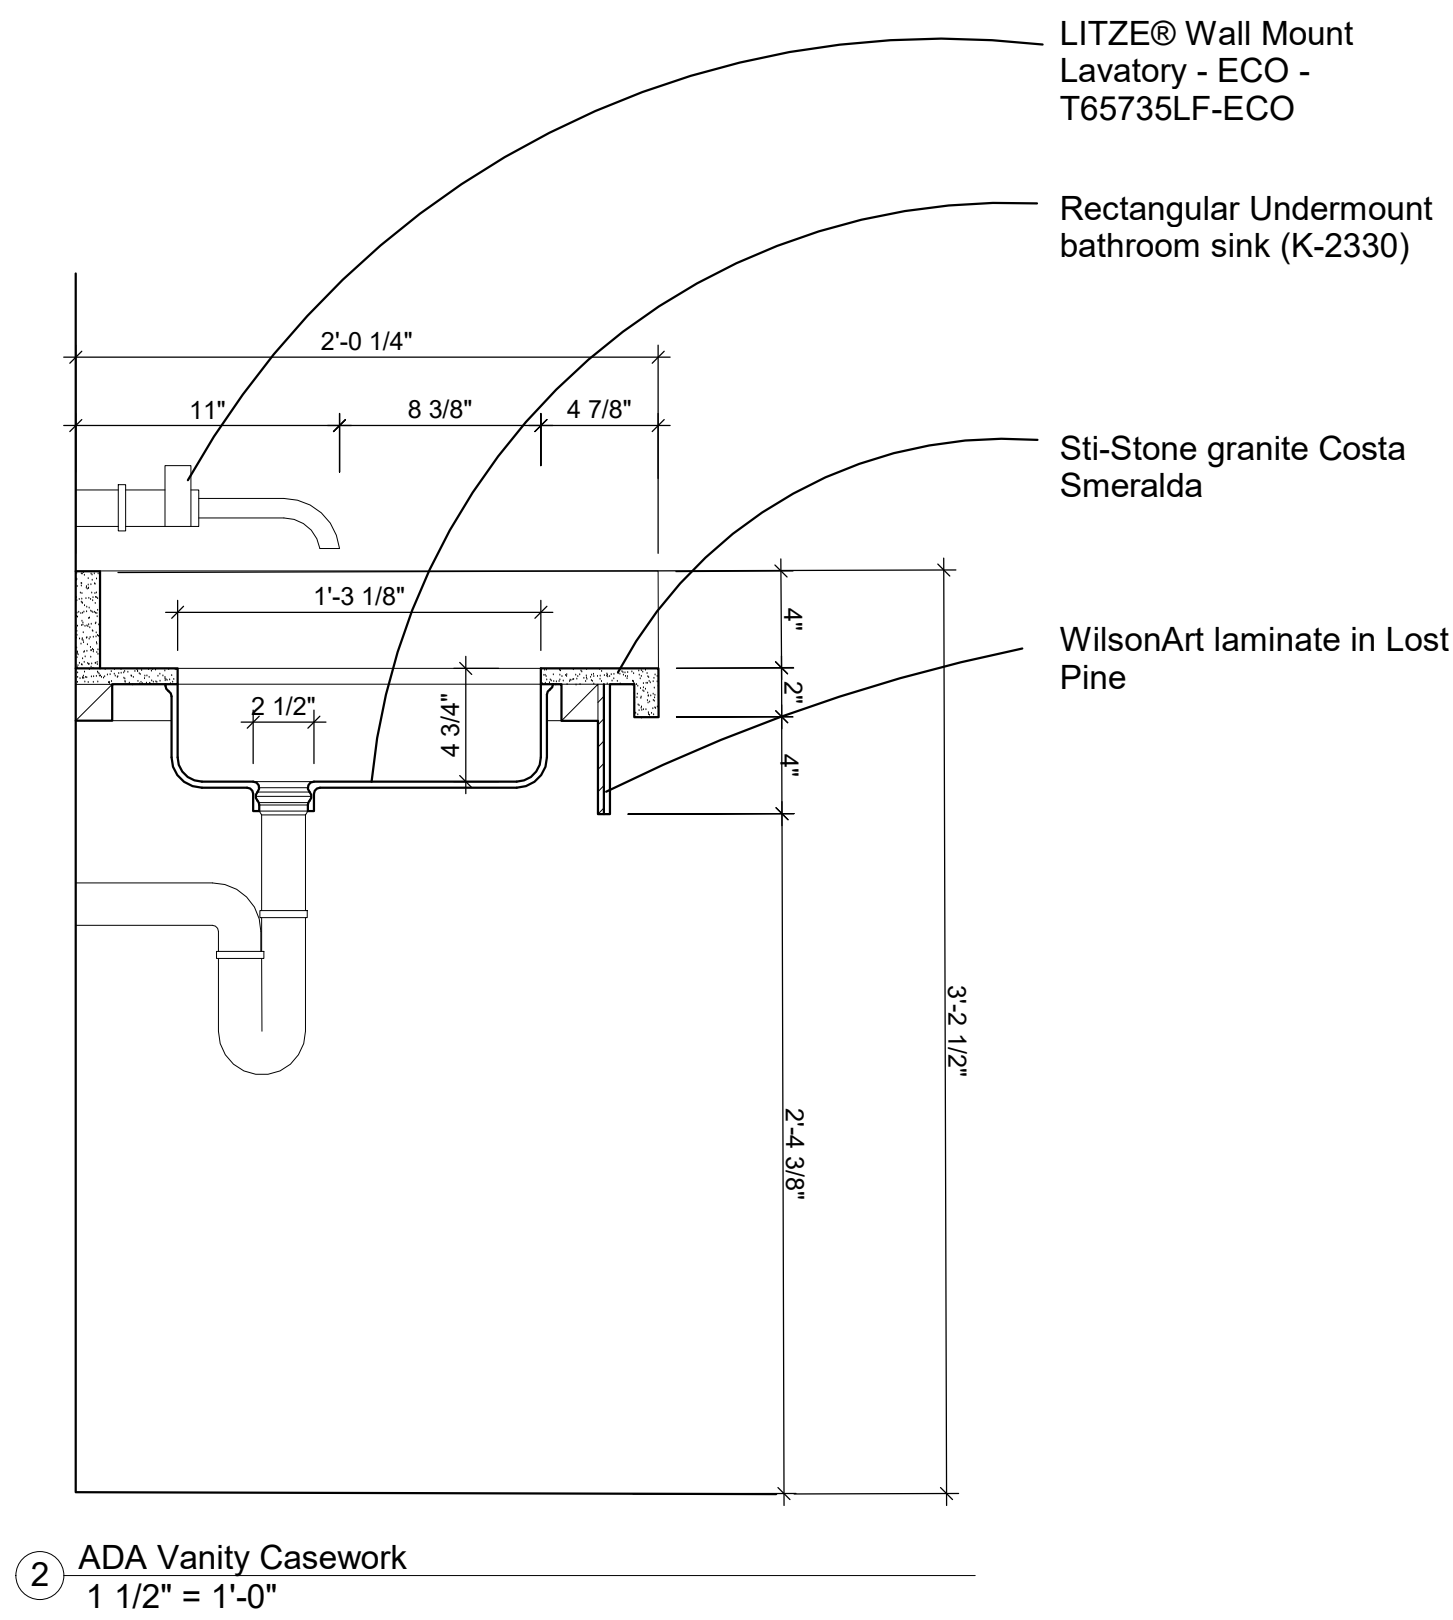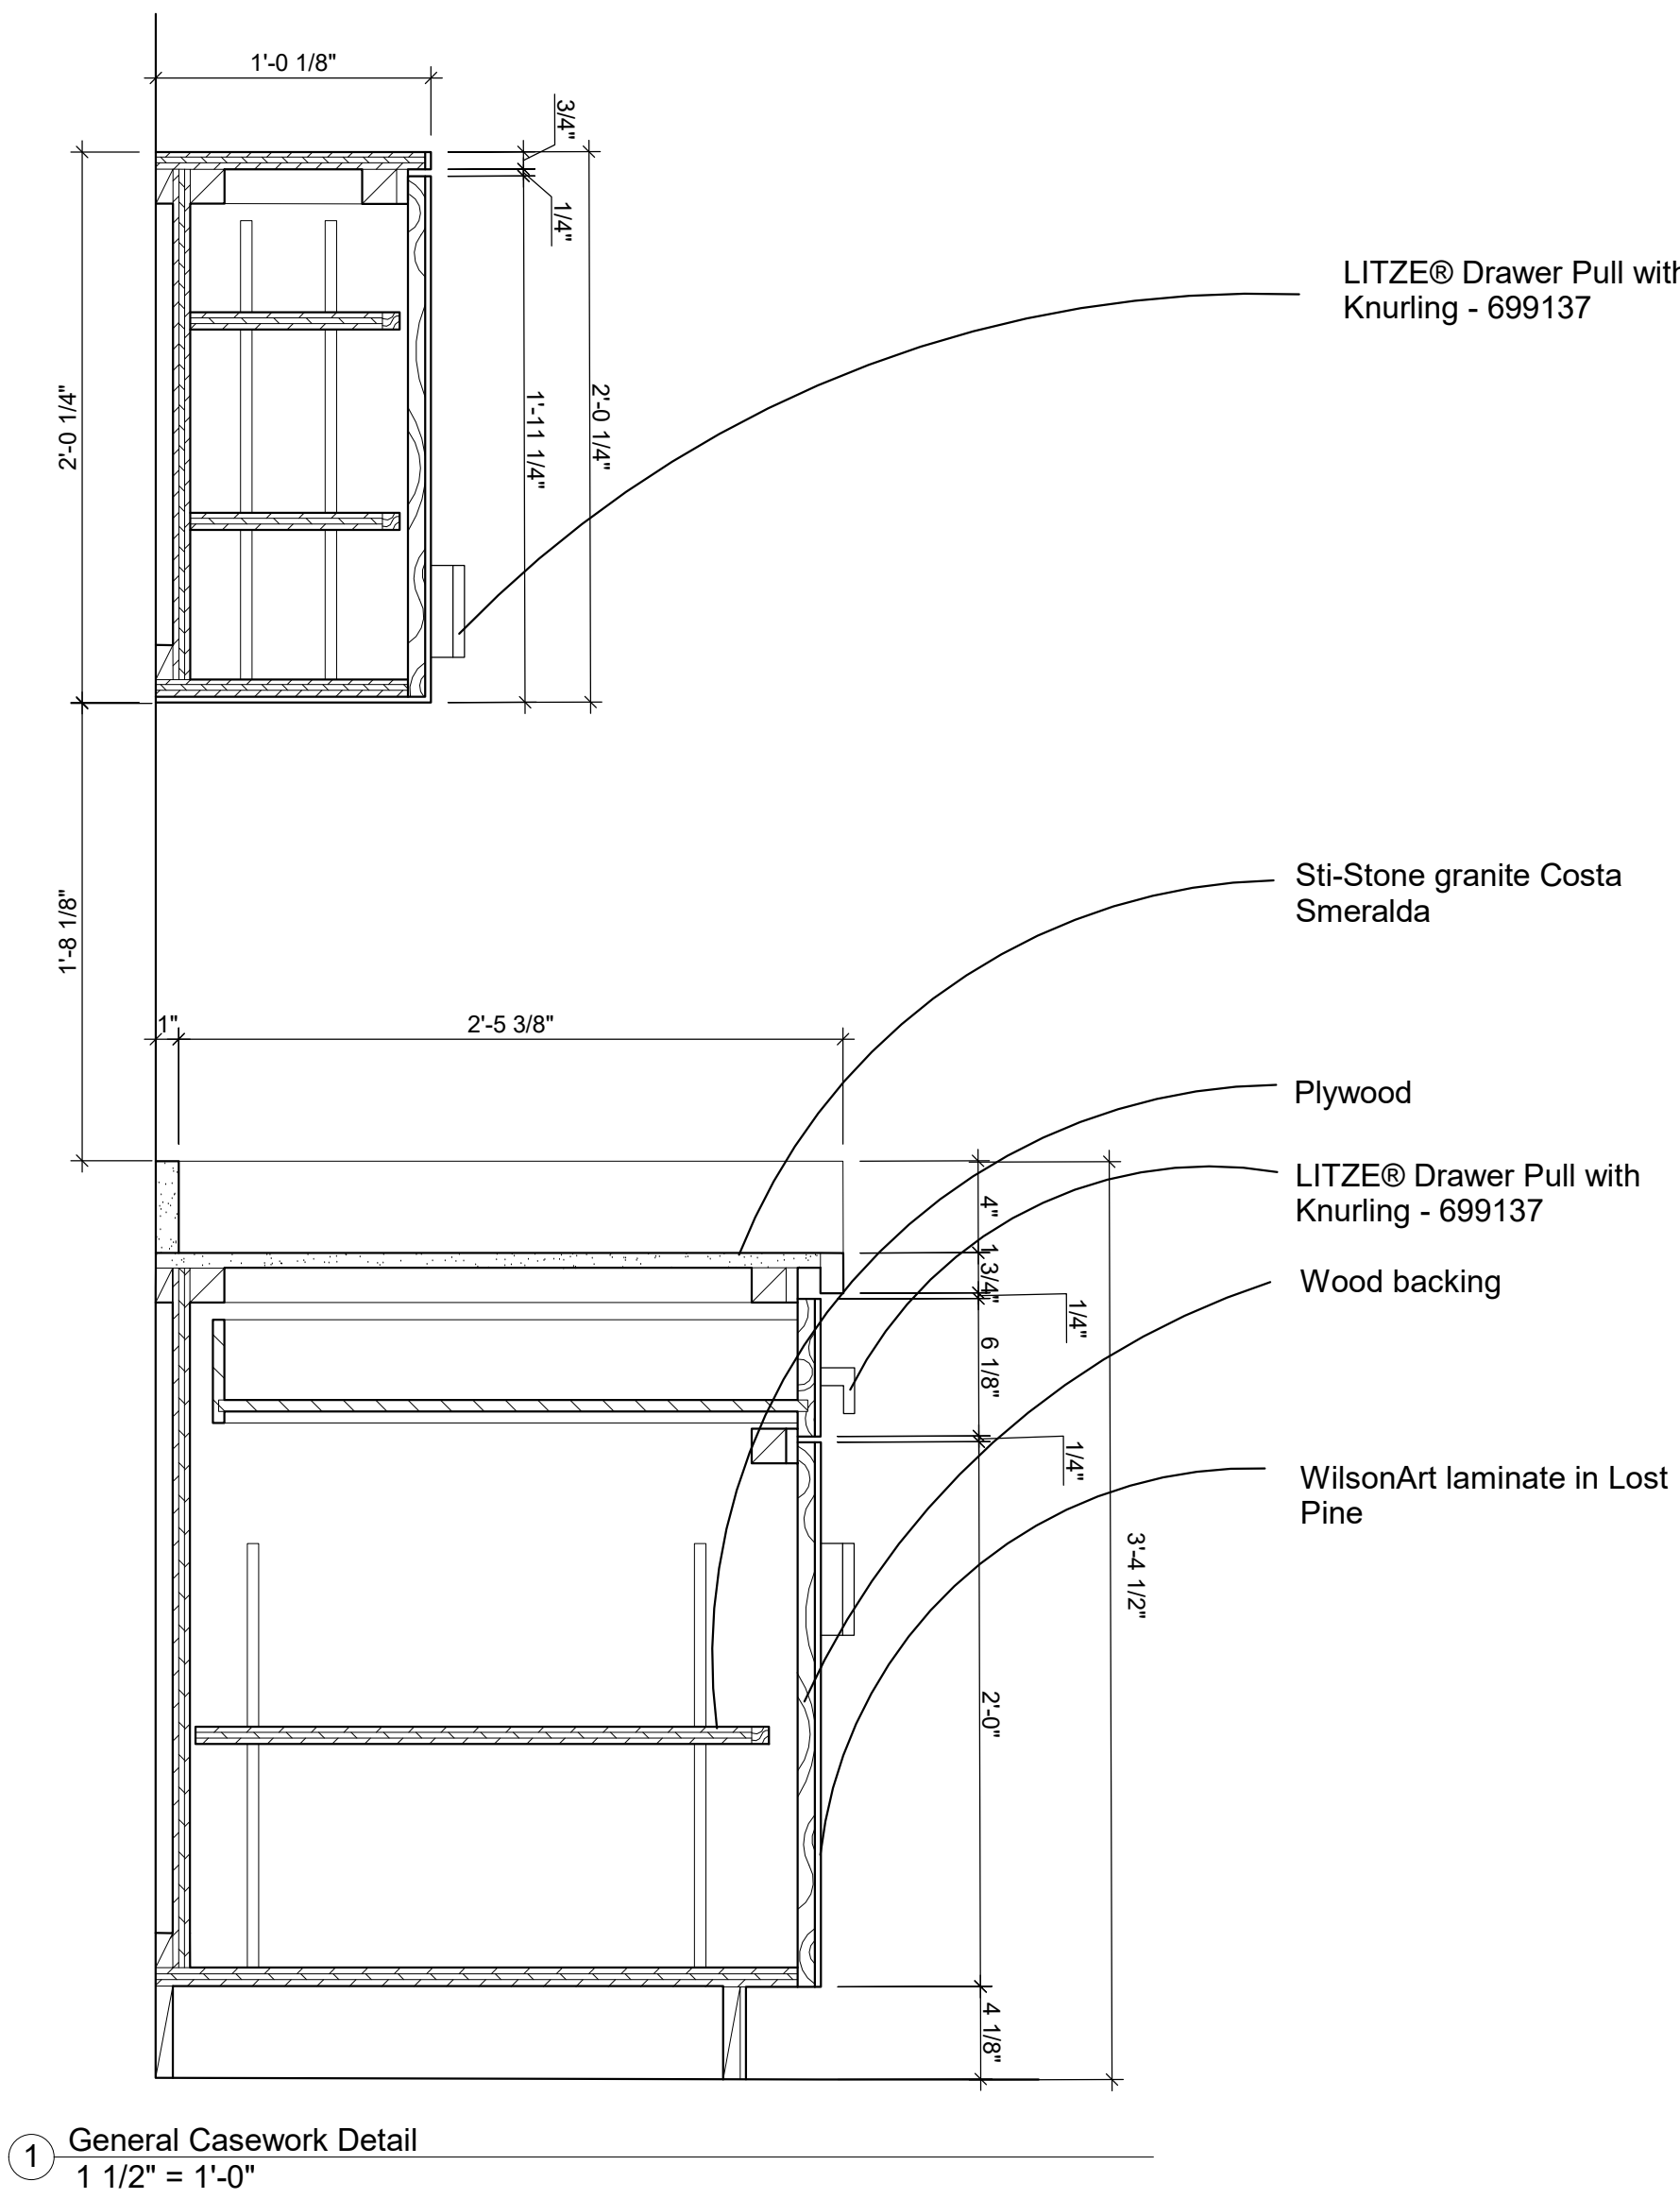

Description	Date

Details Casework	
Date	Issue Date
Drawn by	
Checked by	
ID-8.2	
Scale	1 1/2" = 1'-0"

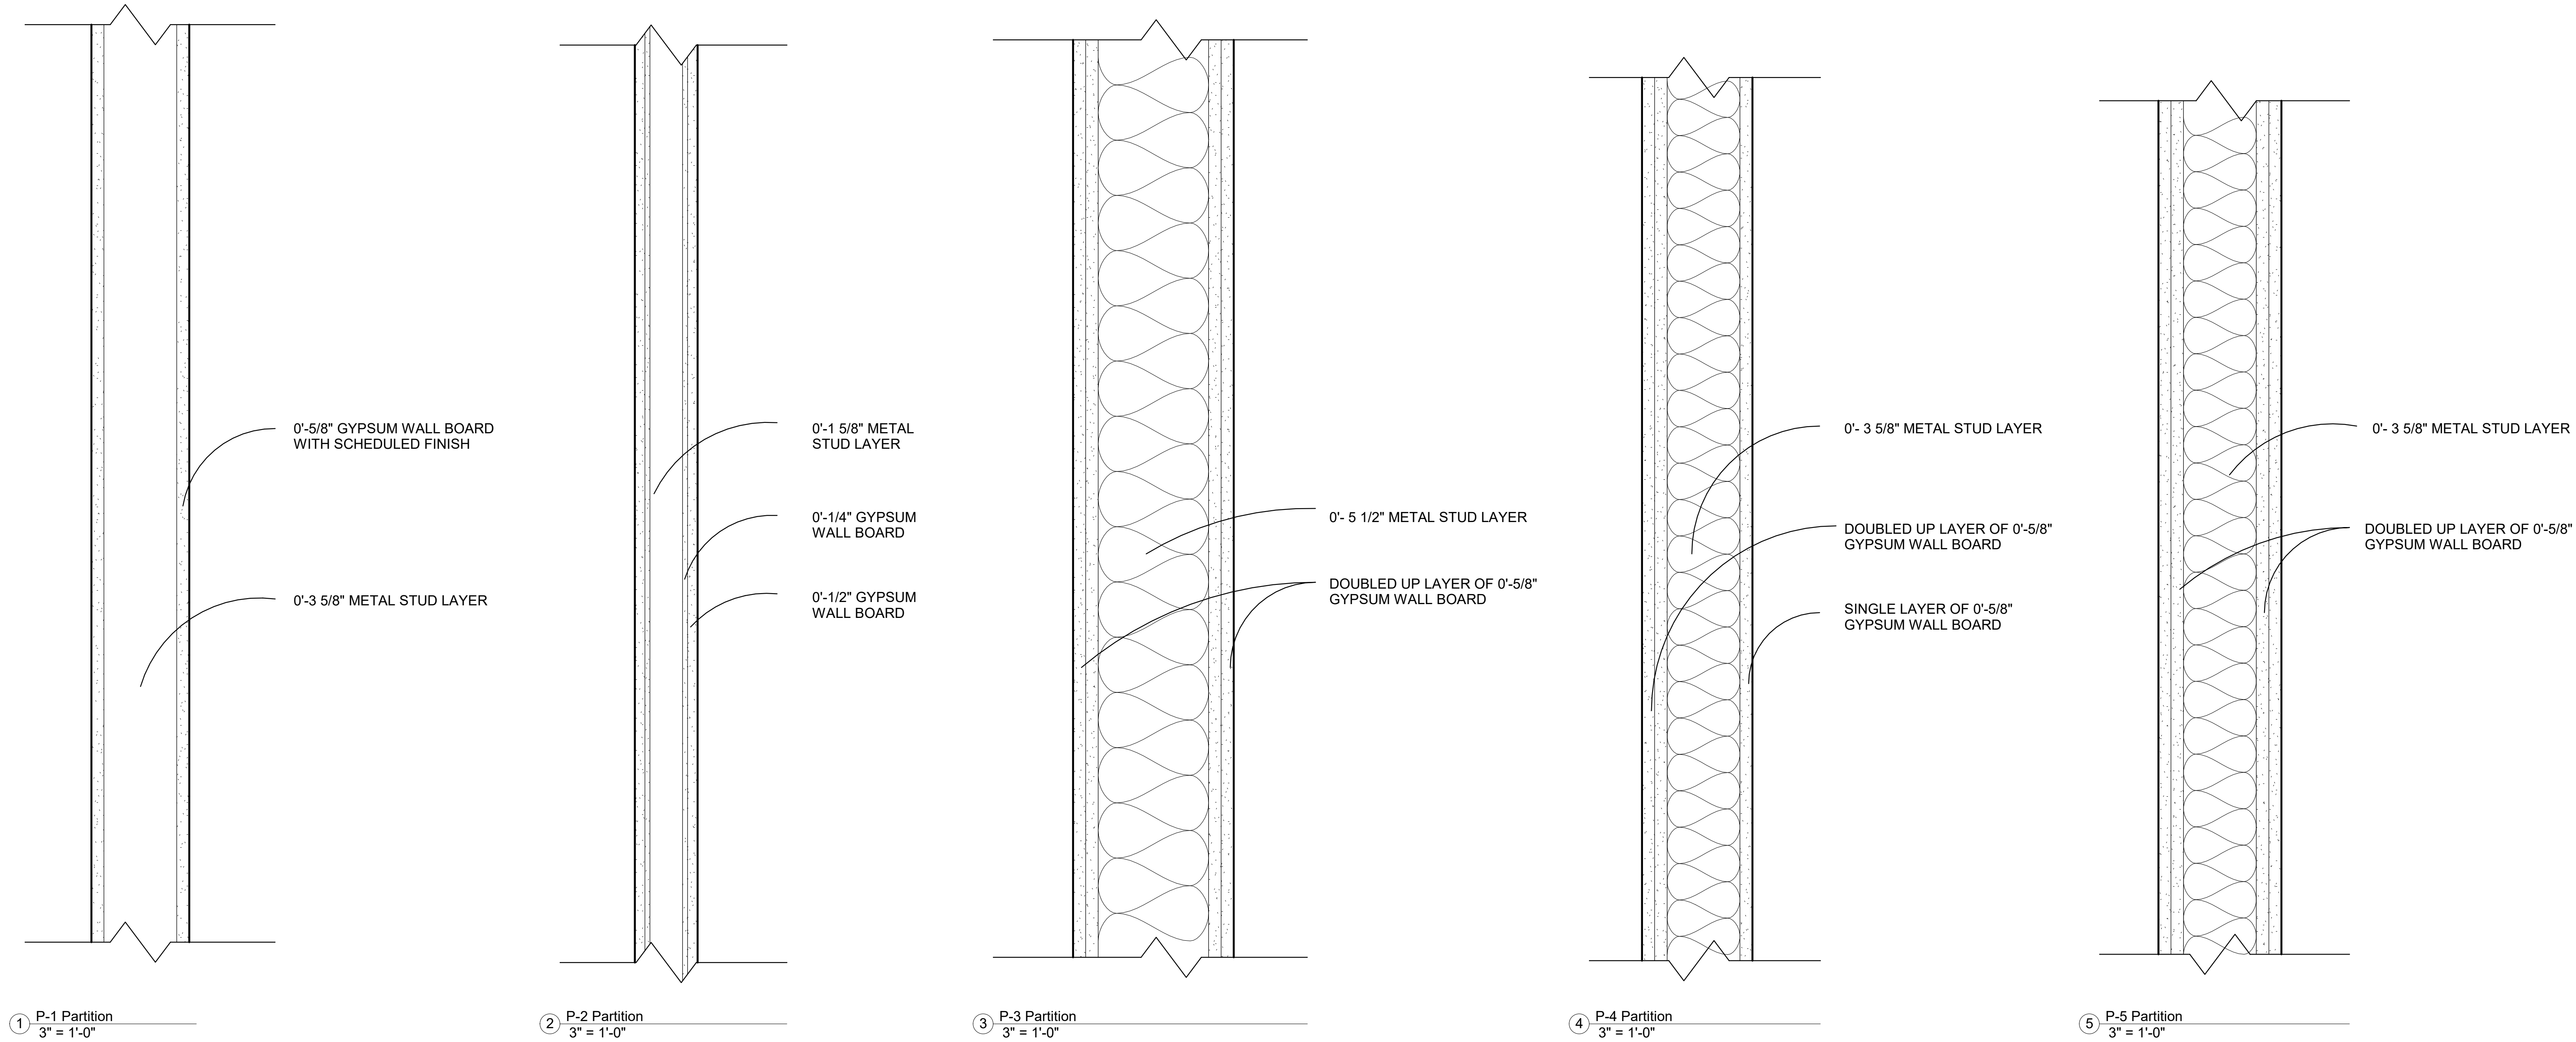

① P-1 Partition 3" = 1'-0"

② P-2 Partition 3" = 1'-0"

③ P-3 Partition 3" = 1'-0"

④ P-4 Partition 3" = 1'-0"

⑤ P-5 Partition 3" = 1'-0"


FOR TYPICAL PARTITIONS AND SPACES THAT DO NOT NEED A LOT OF ACOUSTIC CONSIDERATION

FOR TYPICAL PARTITIONS AND SPACES THAT DO NOT NEED A LOT OF ACOUSTIC CONSIDERATION. NON-FIRE RATED


FOR PLUMBING WALLS AND FOR 2 HR FIRE PROTECTION. GOOD ACOUSTIC INSULATION AS WELL.

FOR 1 HR FIRE RATING AND FOR ACOUSTIC INSULATION.

FOR 2 HR FIRE RATING AND ACOUSTIC INSULATION IN NON-PLUMBING APPLICATIONS.

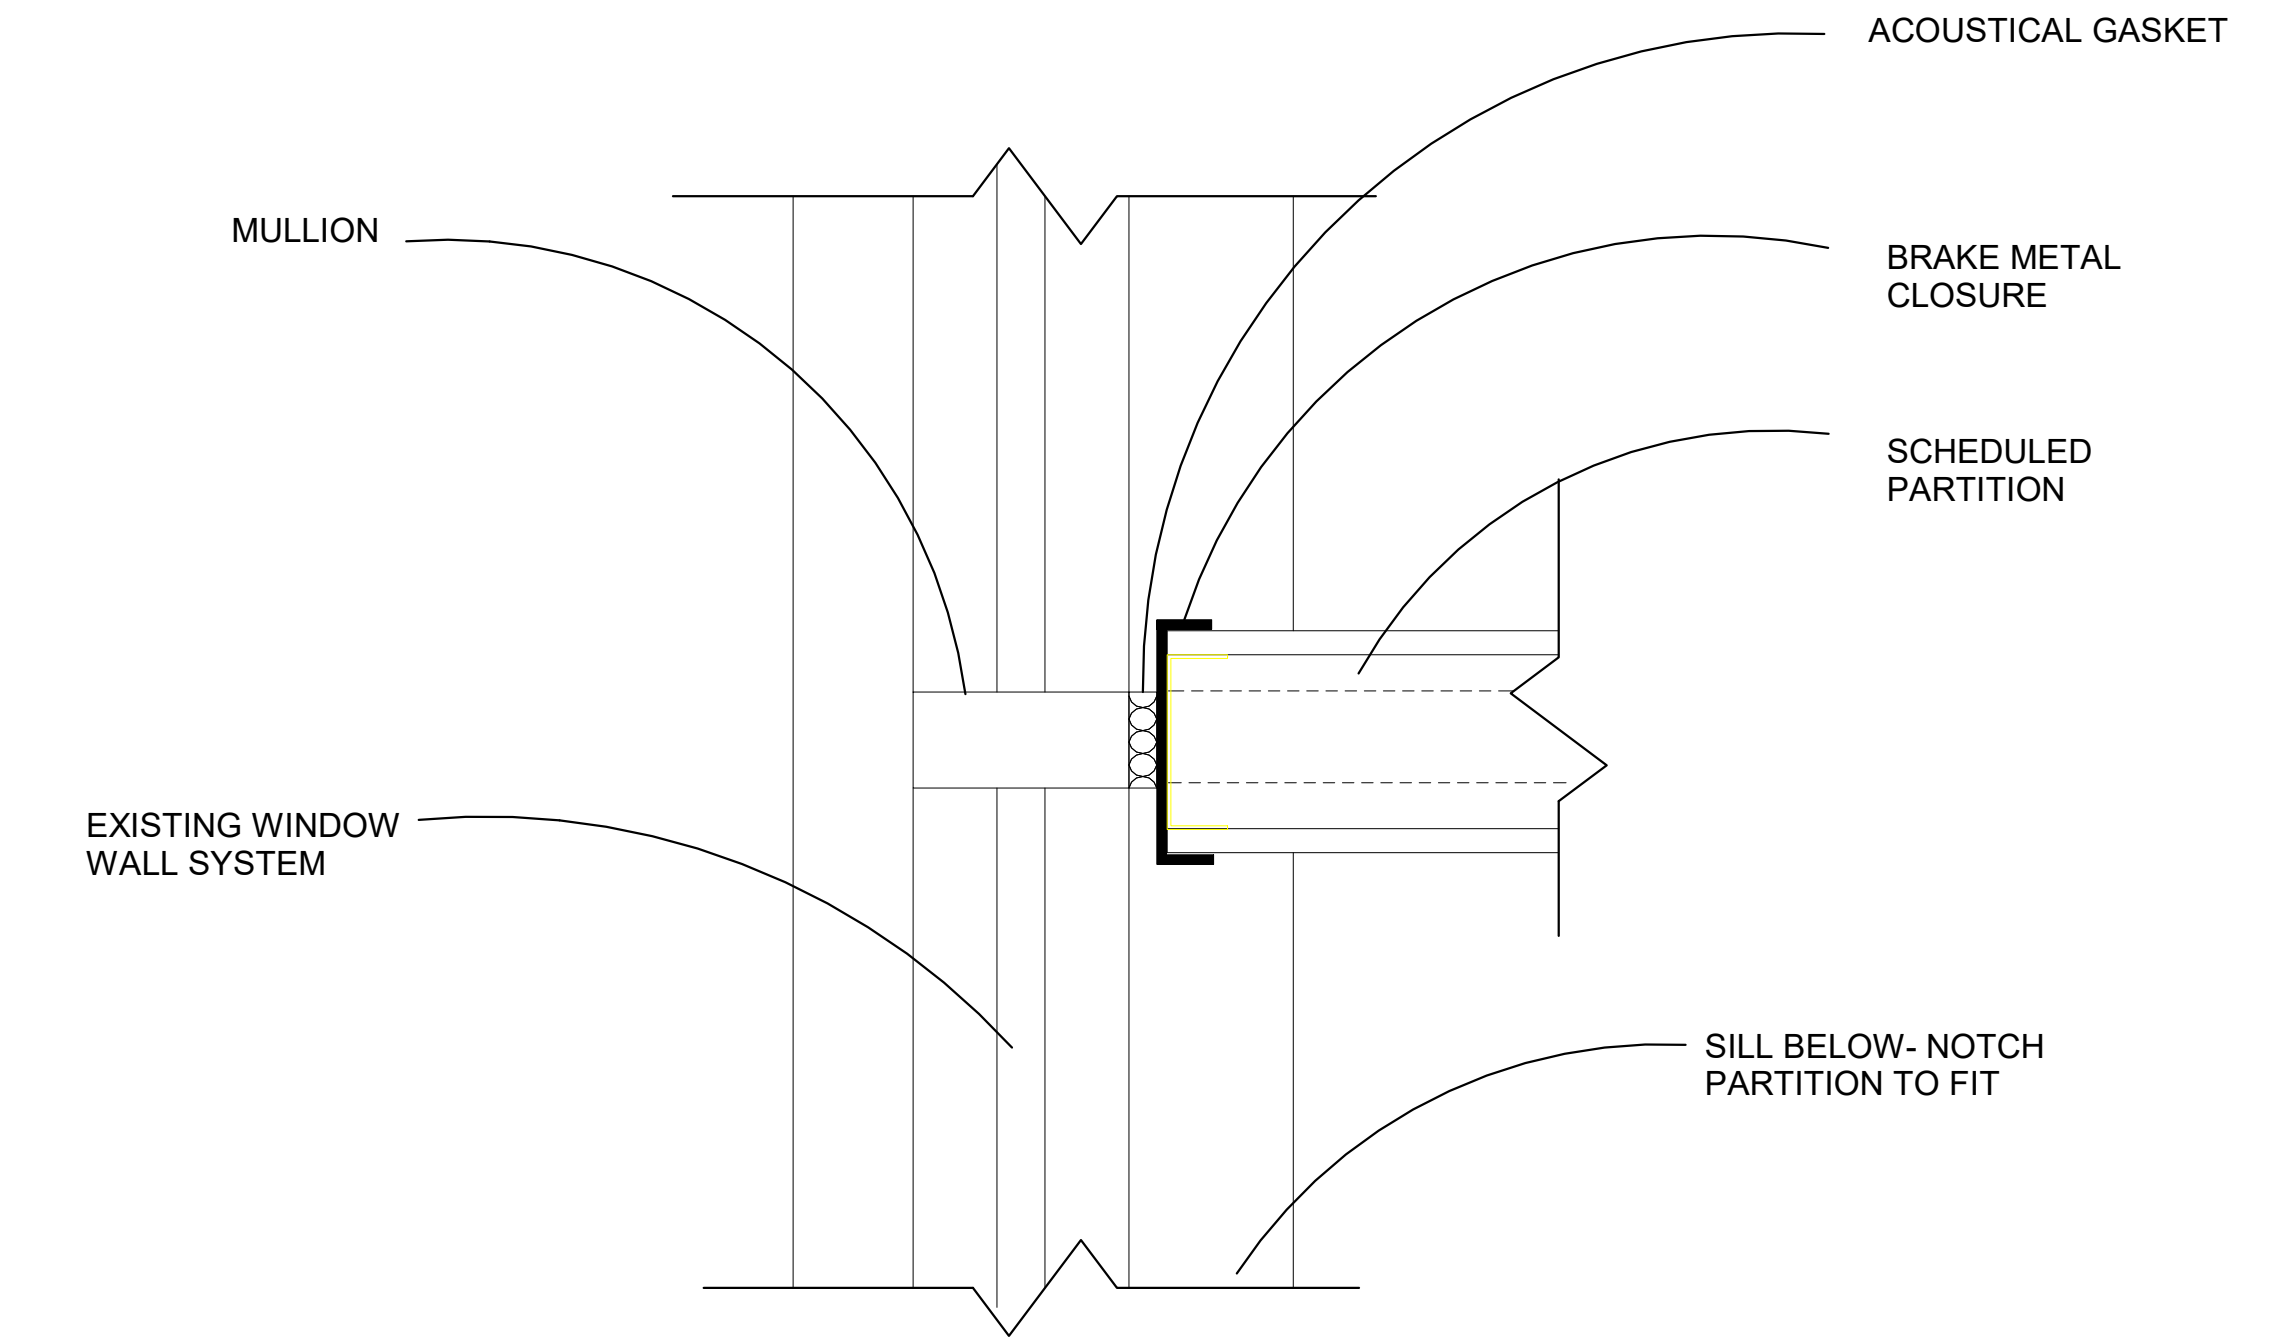

⑥ Wall-Mullion Detail 3" = 1'-0"

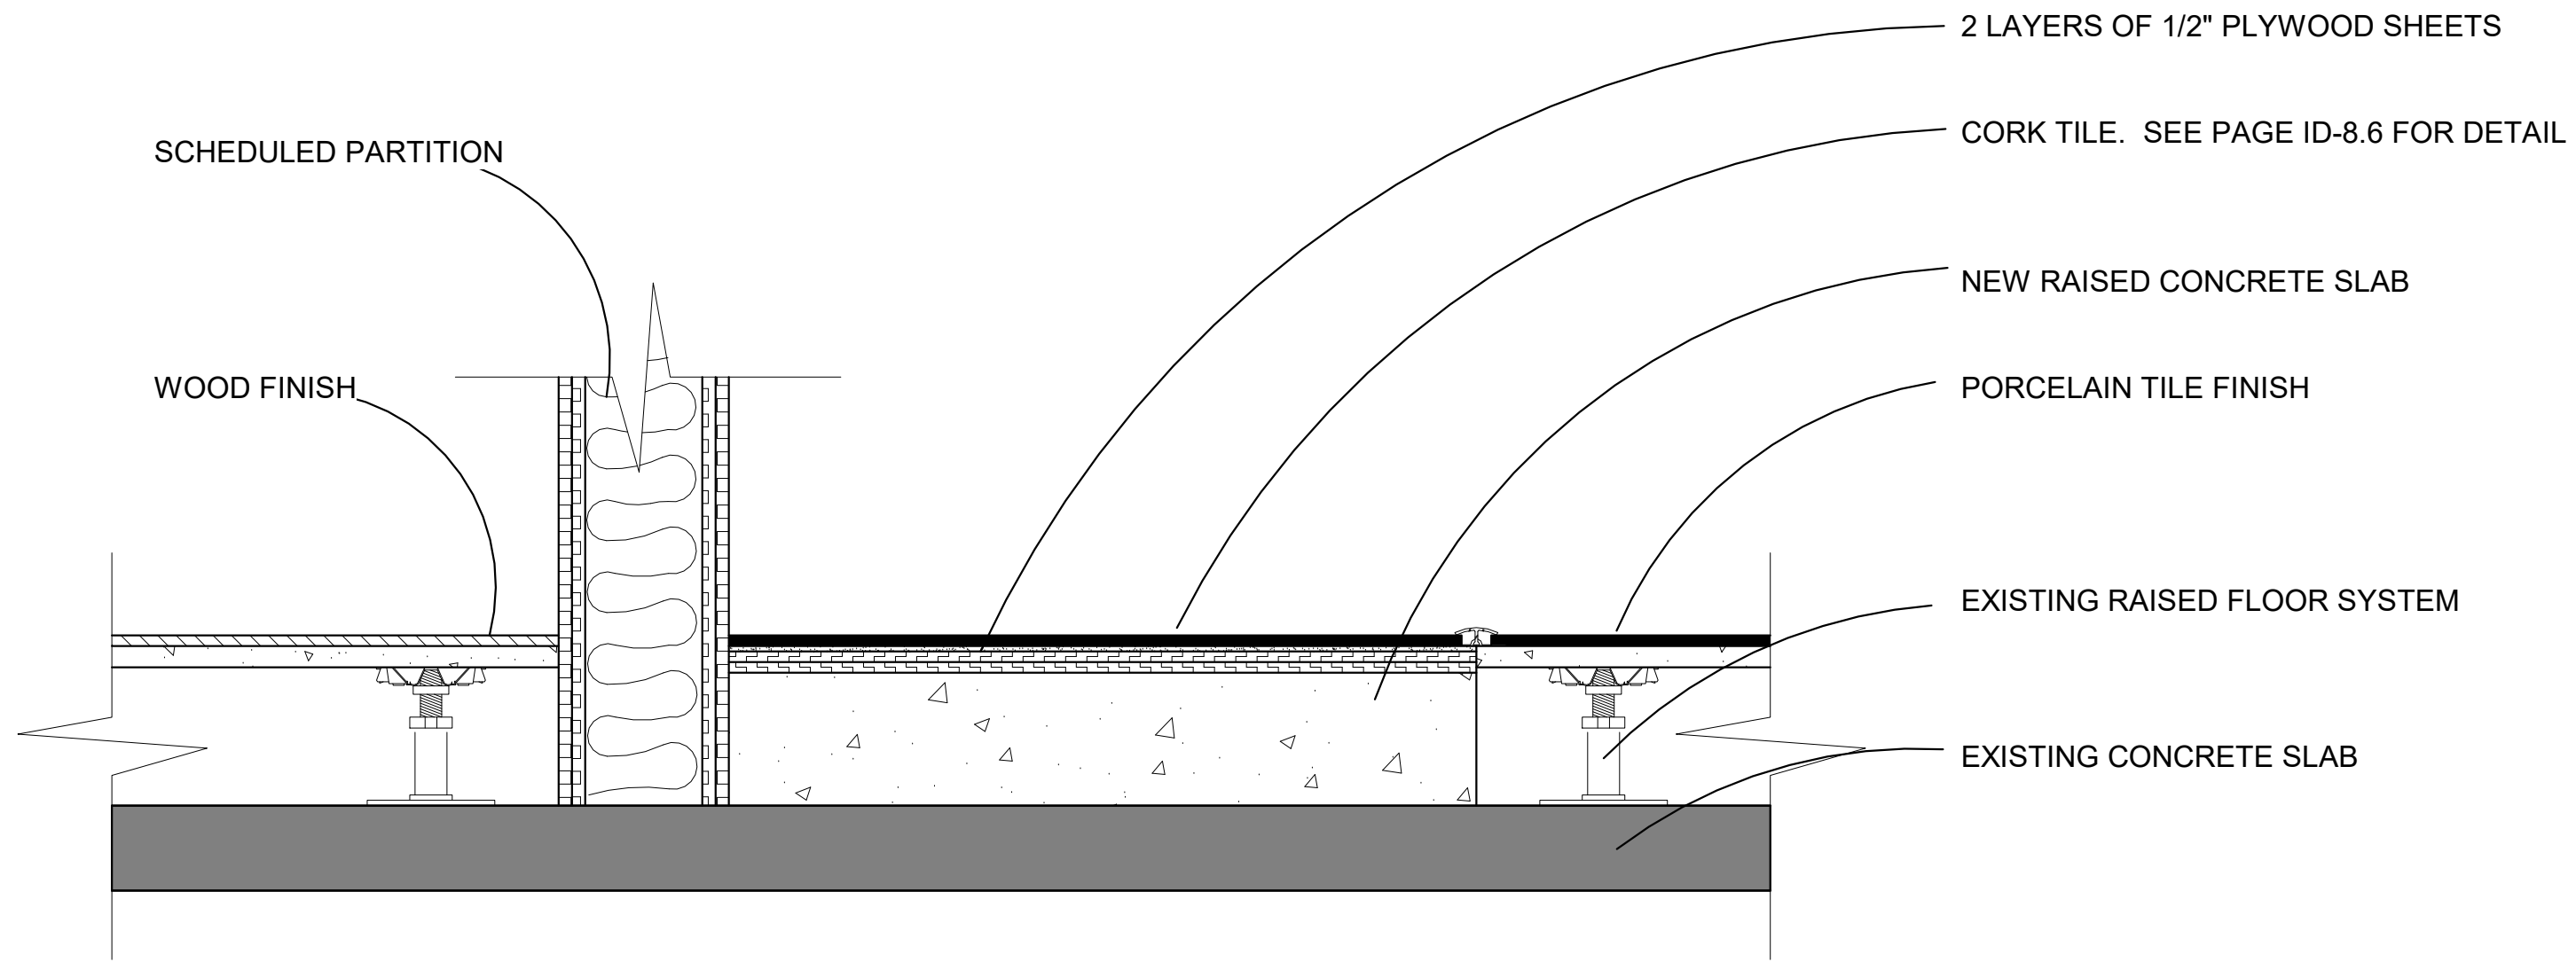

⑦ New Floor Detail 1 1/2" = 1'-0"

KSU
ID

Kylie Arett

Kylie Arett
ID 645
Spring Semester
kkarett@ksu.edu

The Origins Wellness Center
4TH & PIERRE ST. MANHATTAN,
KS. 66502

Description	Date

Partition
Types

Date

Issue Date

Drawn by



Checked by

ID-8.3


Scale

As indicated


4/30/2021 11:21:14 AM

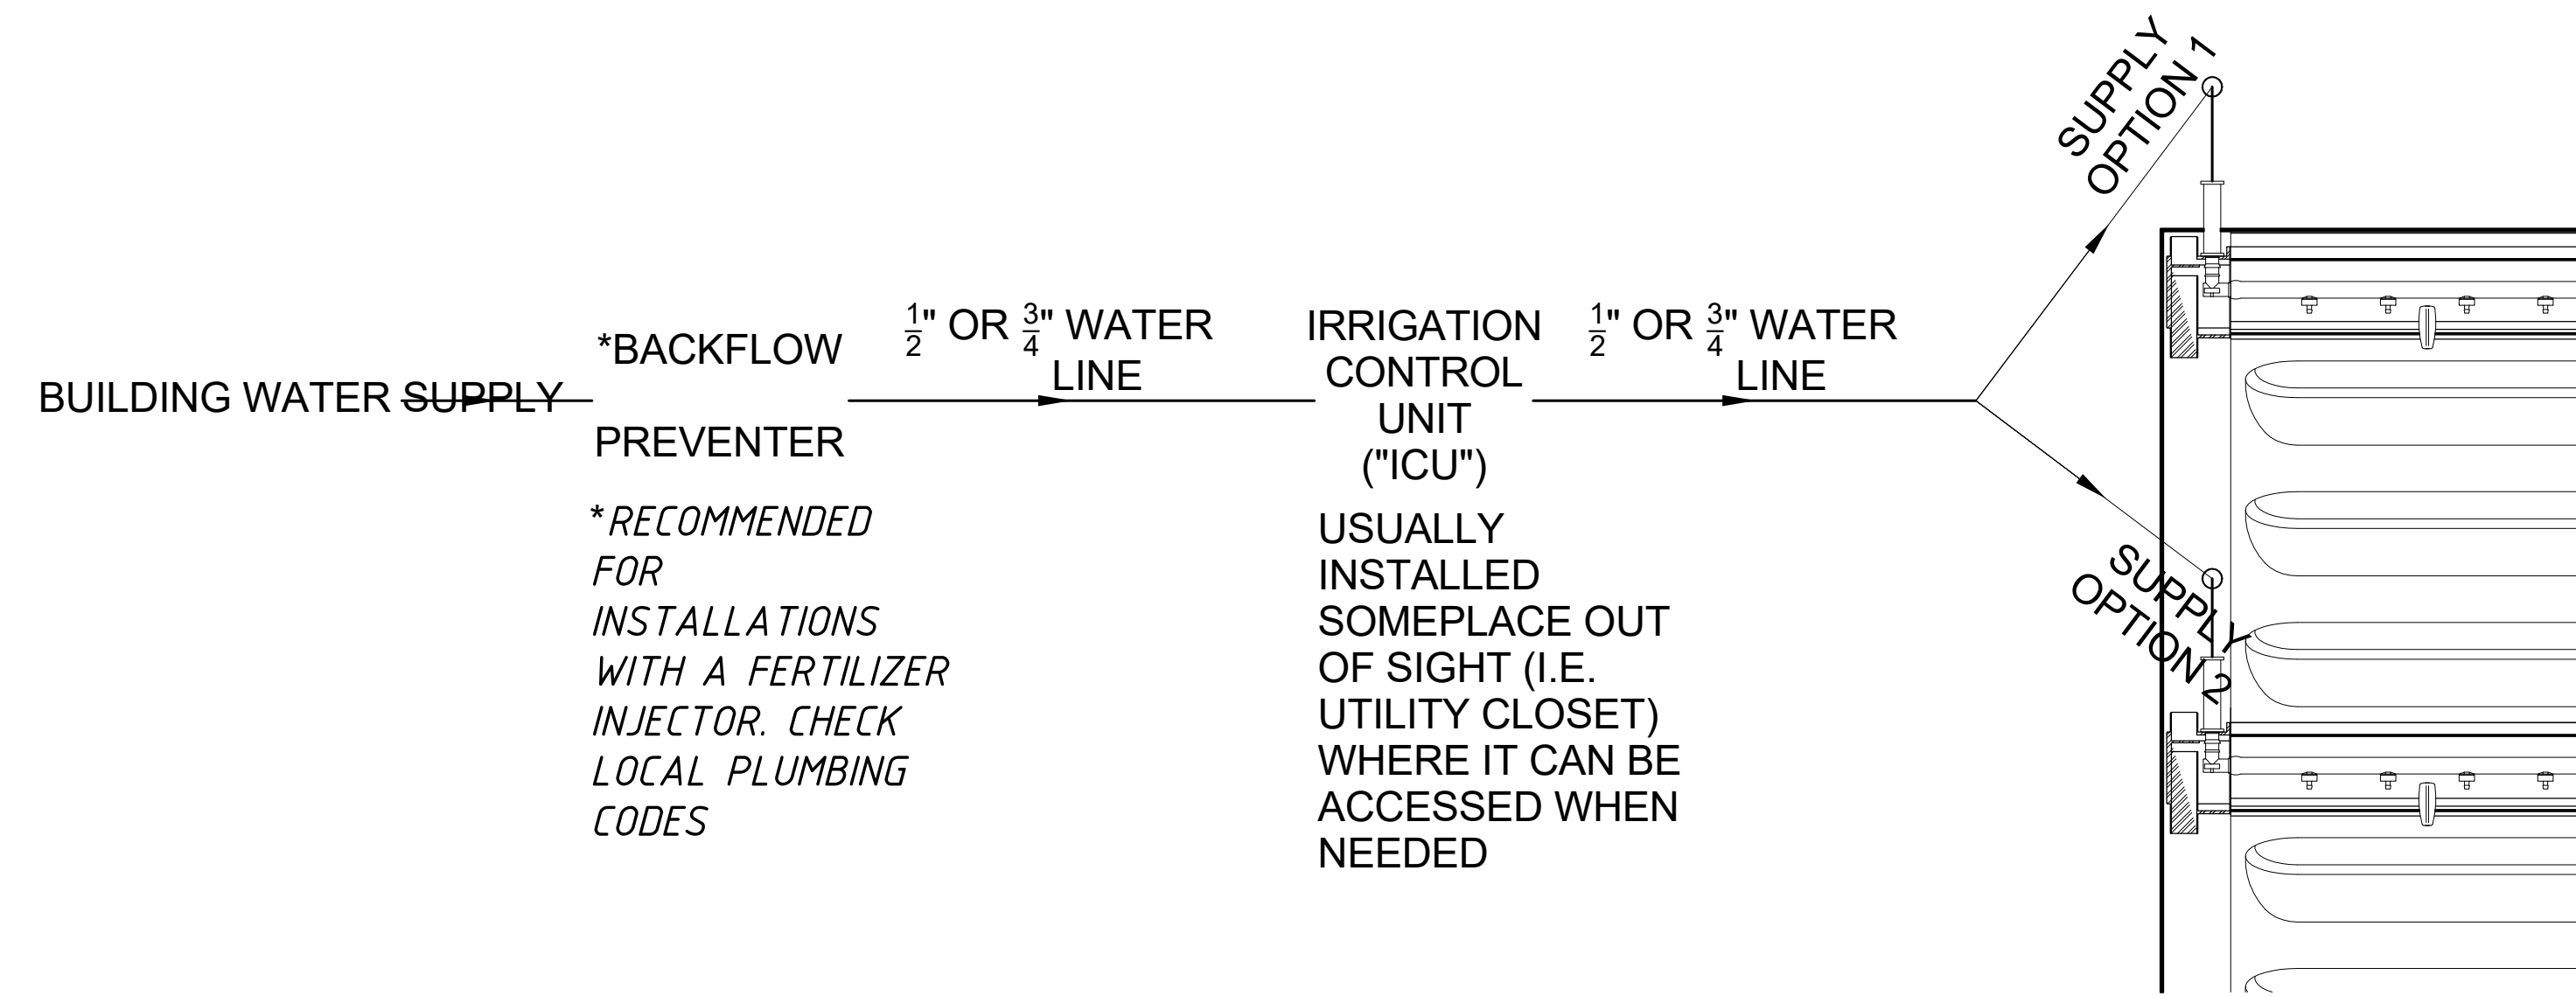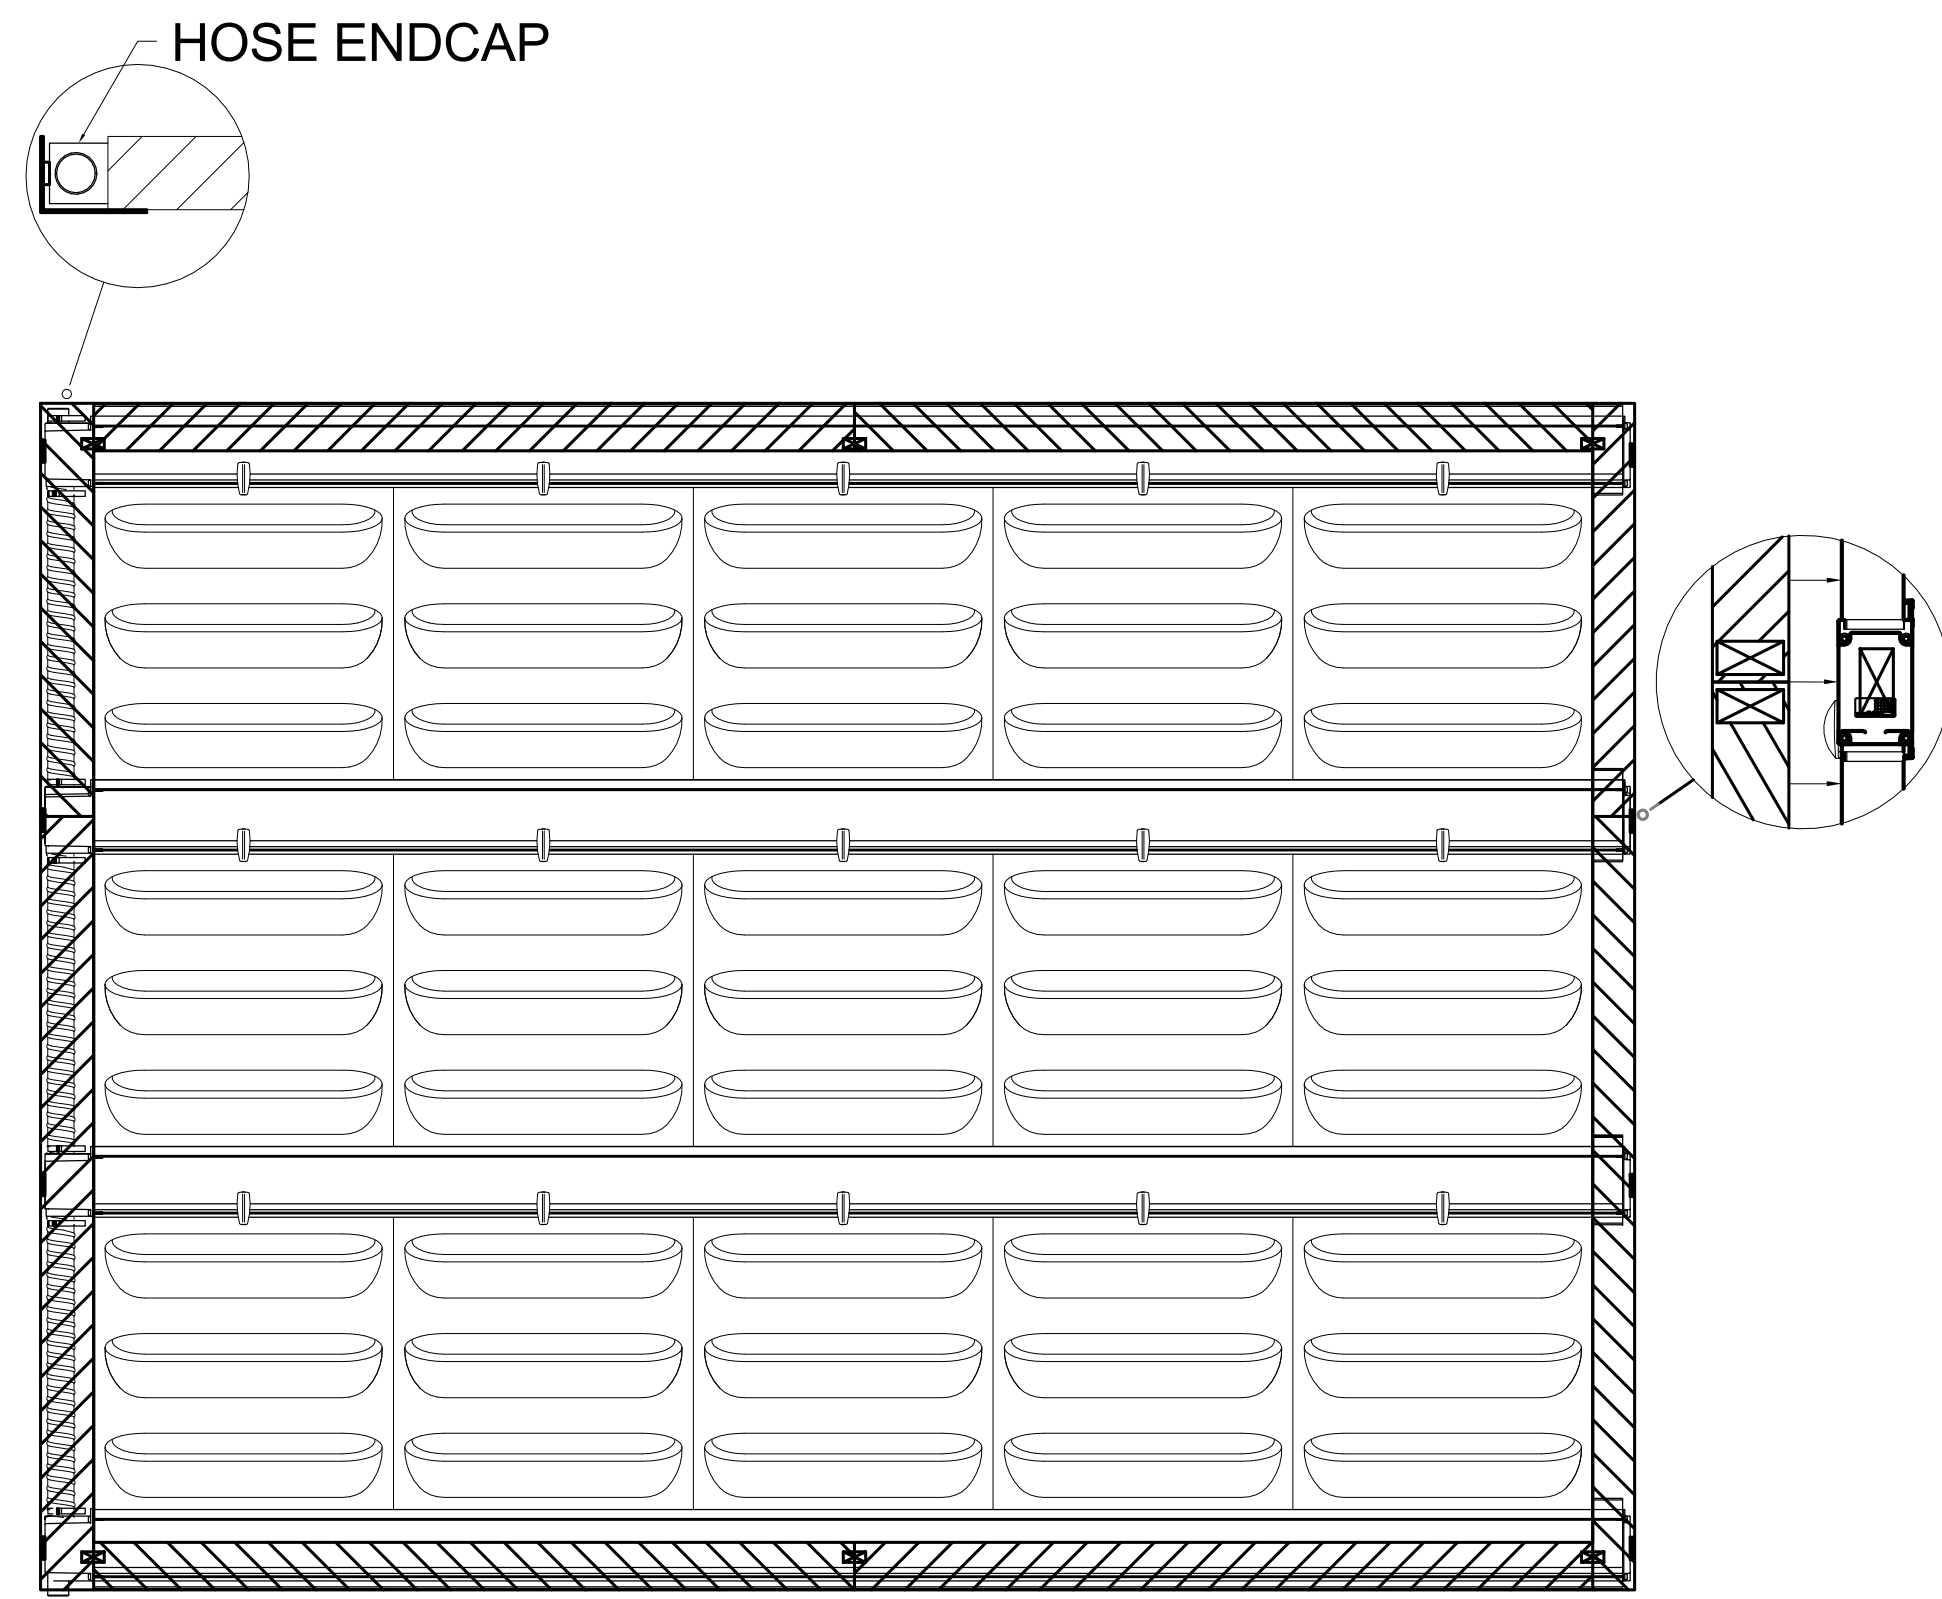


ICU SUPPLY OPTION 1

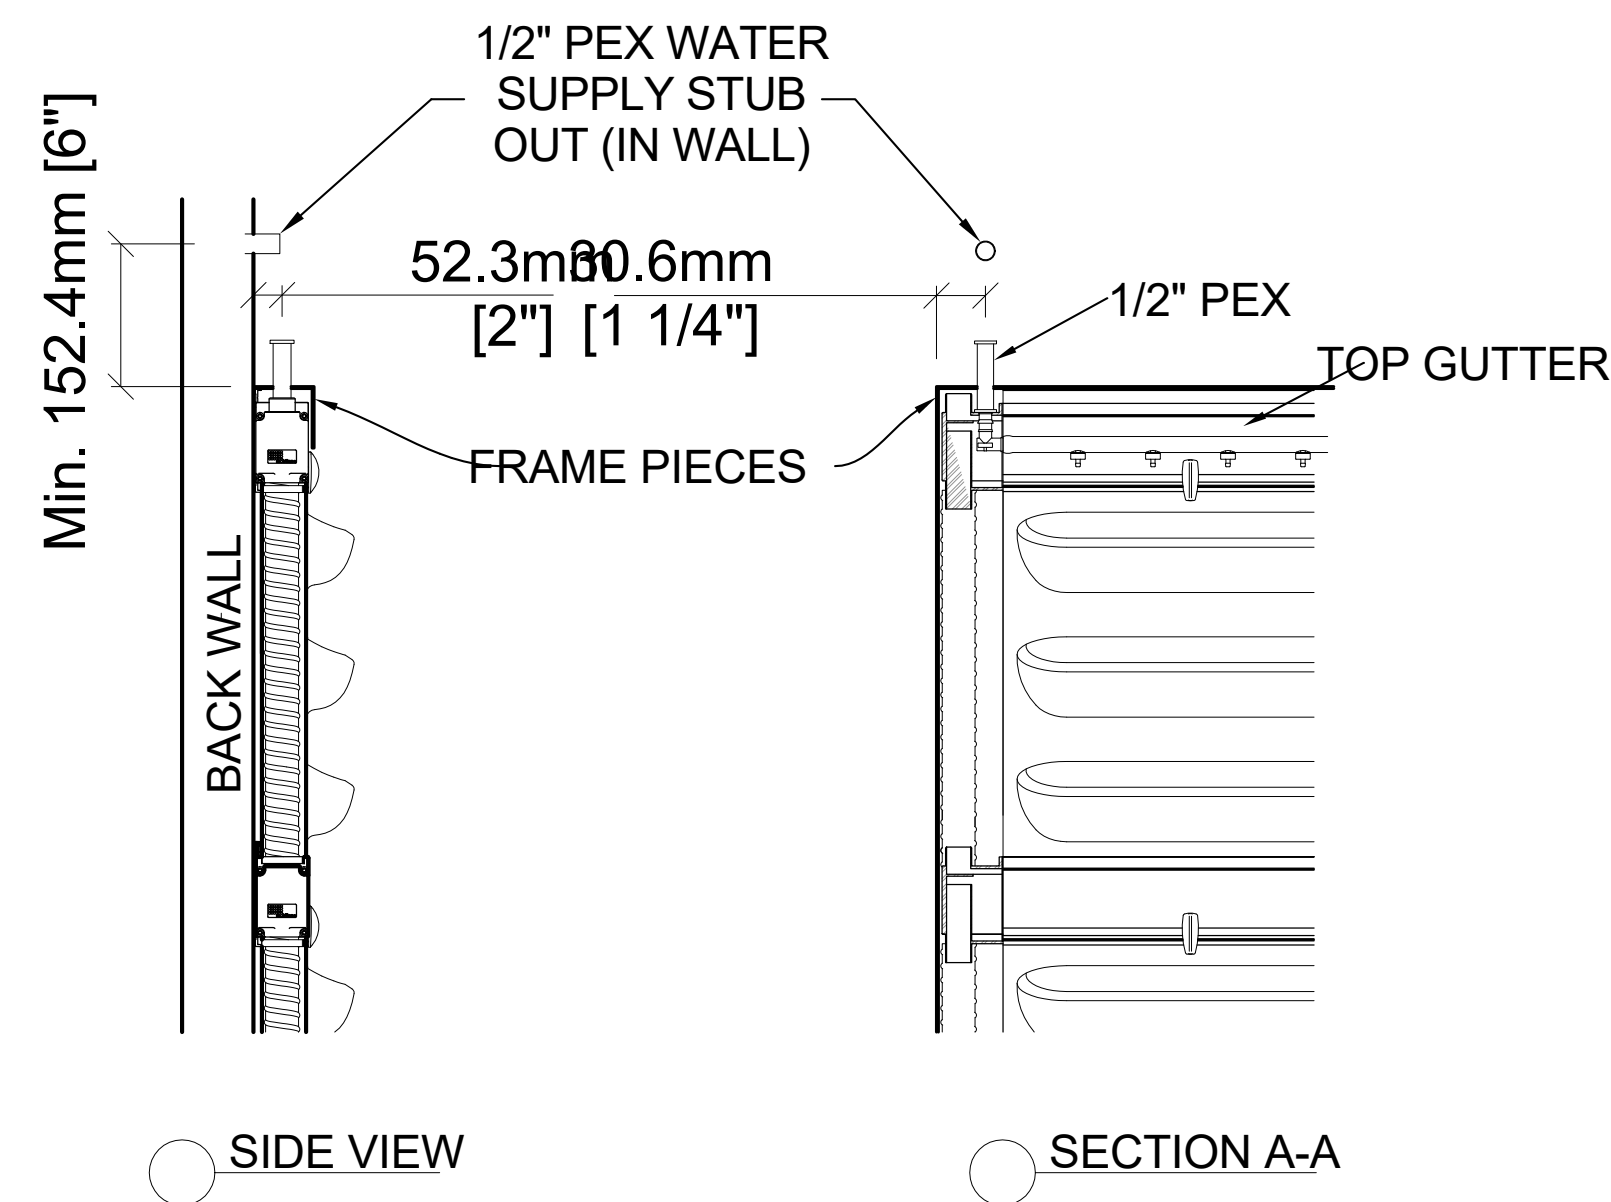


ICU DRAIN

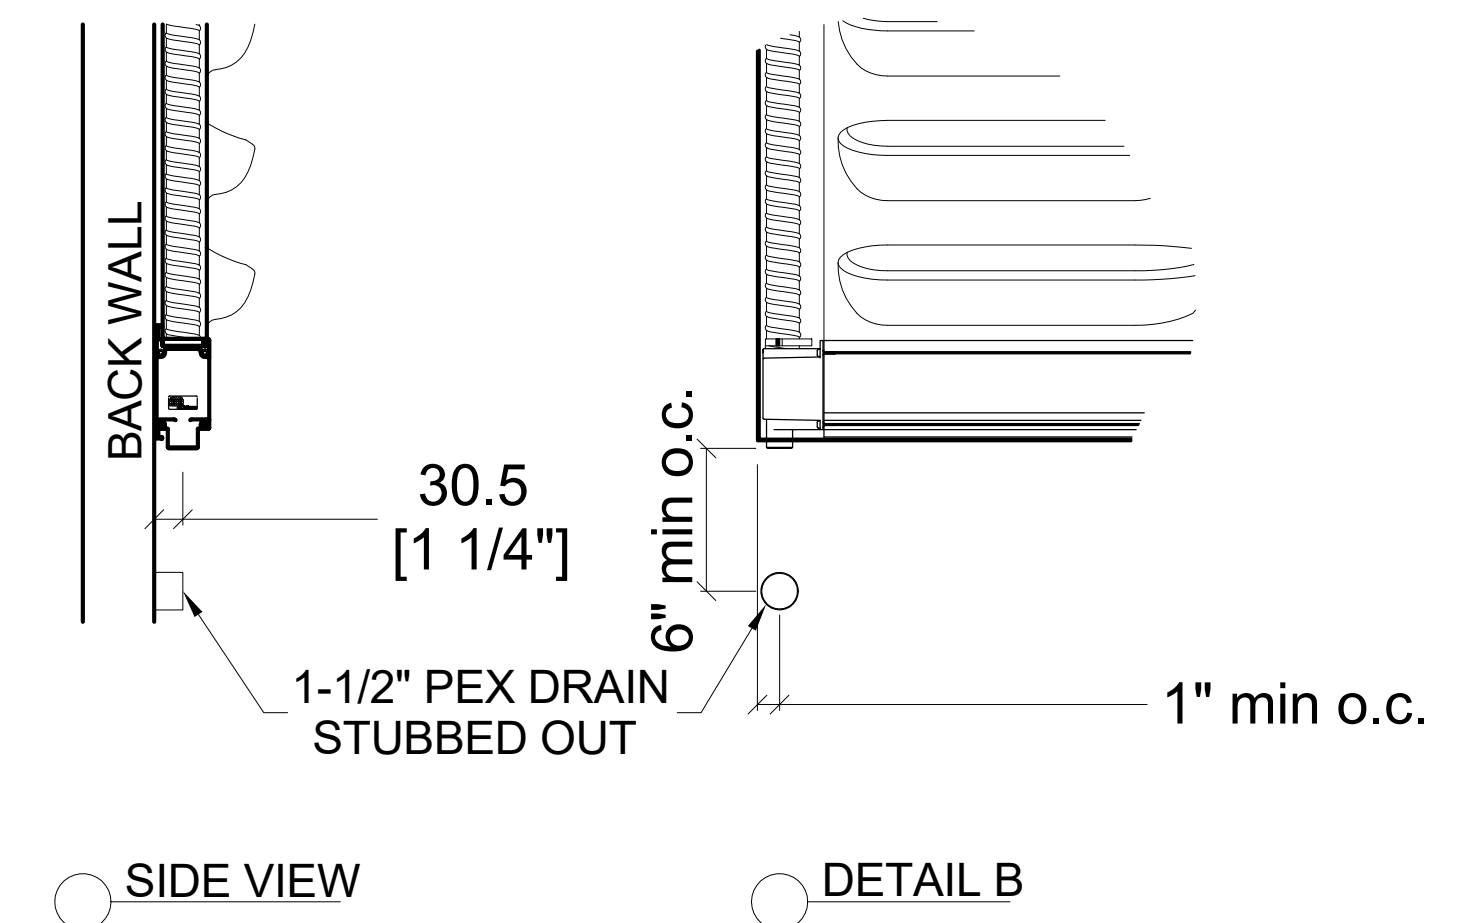

ICU SUPPLY OPTION 2

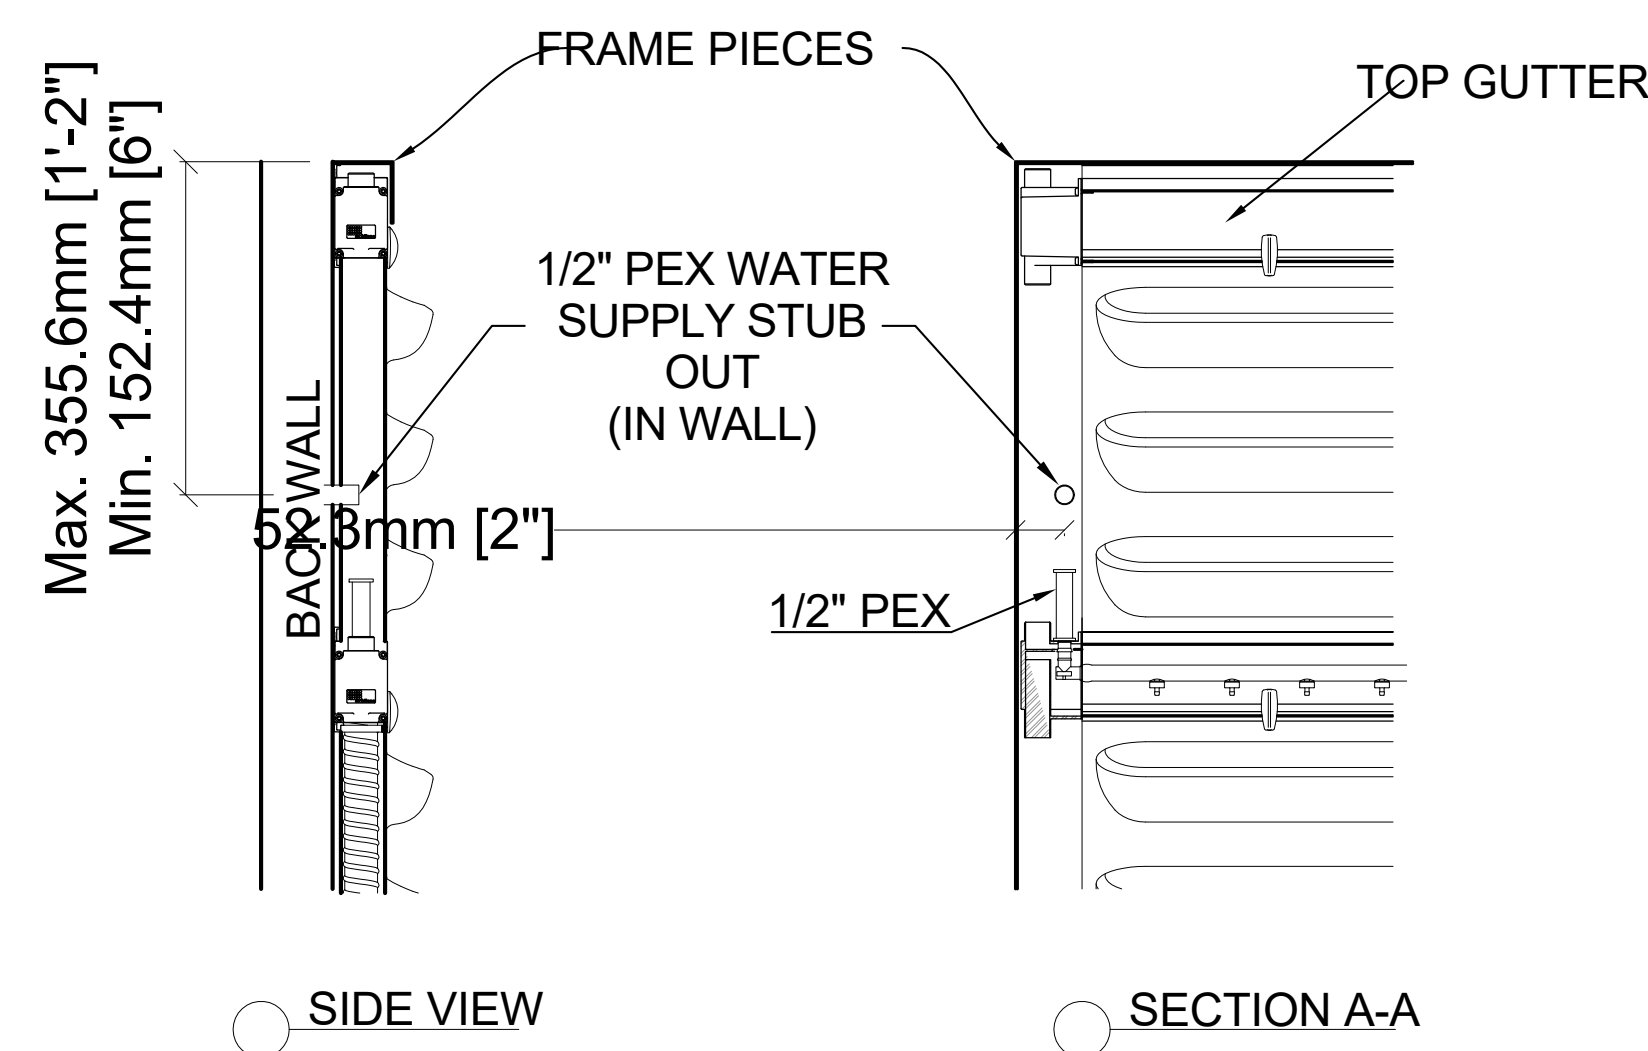

NOTE:
DIMENSIONS ARE TAKEN FROM TOP OF GREEN WALL

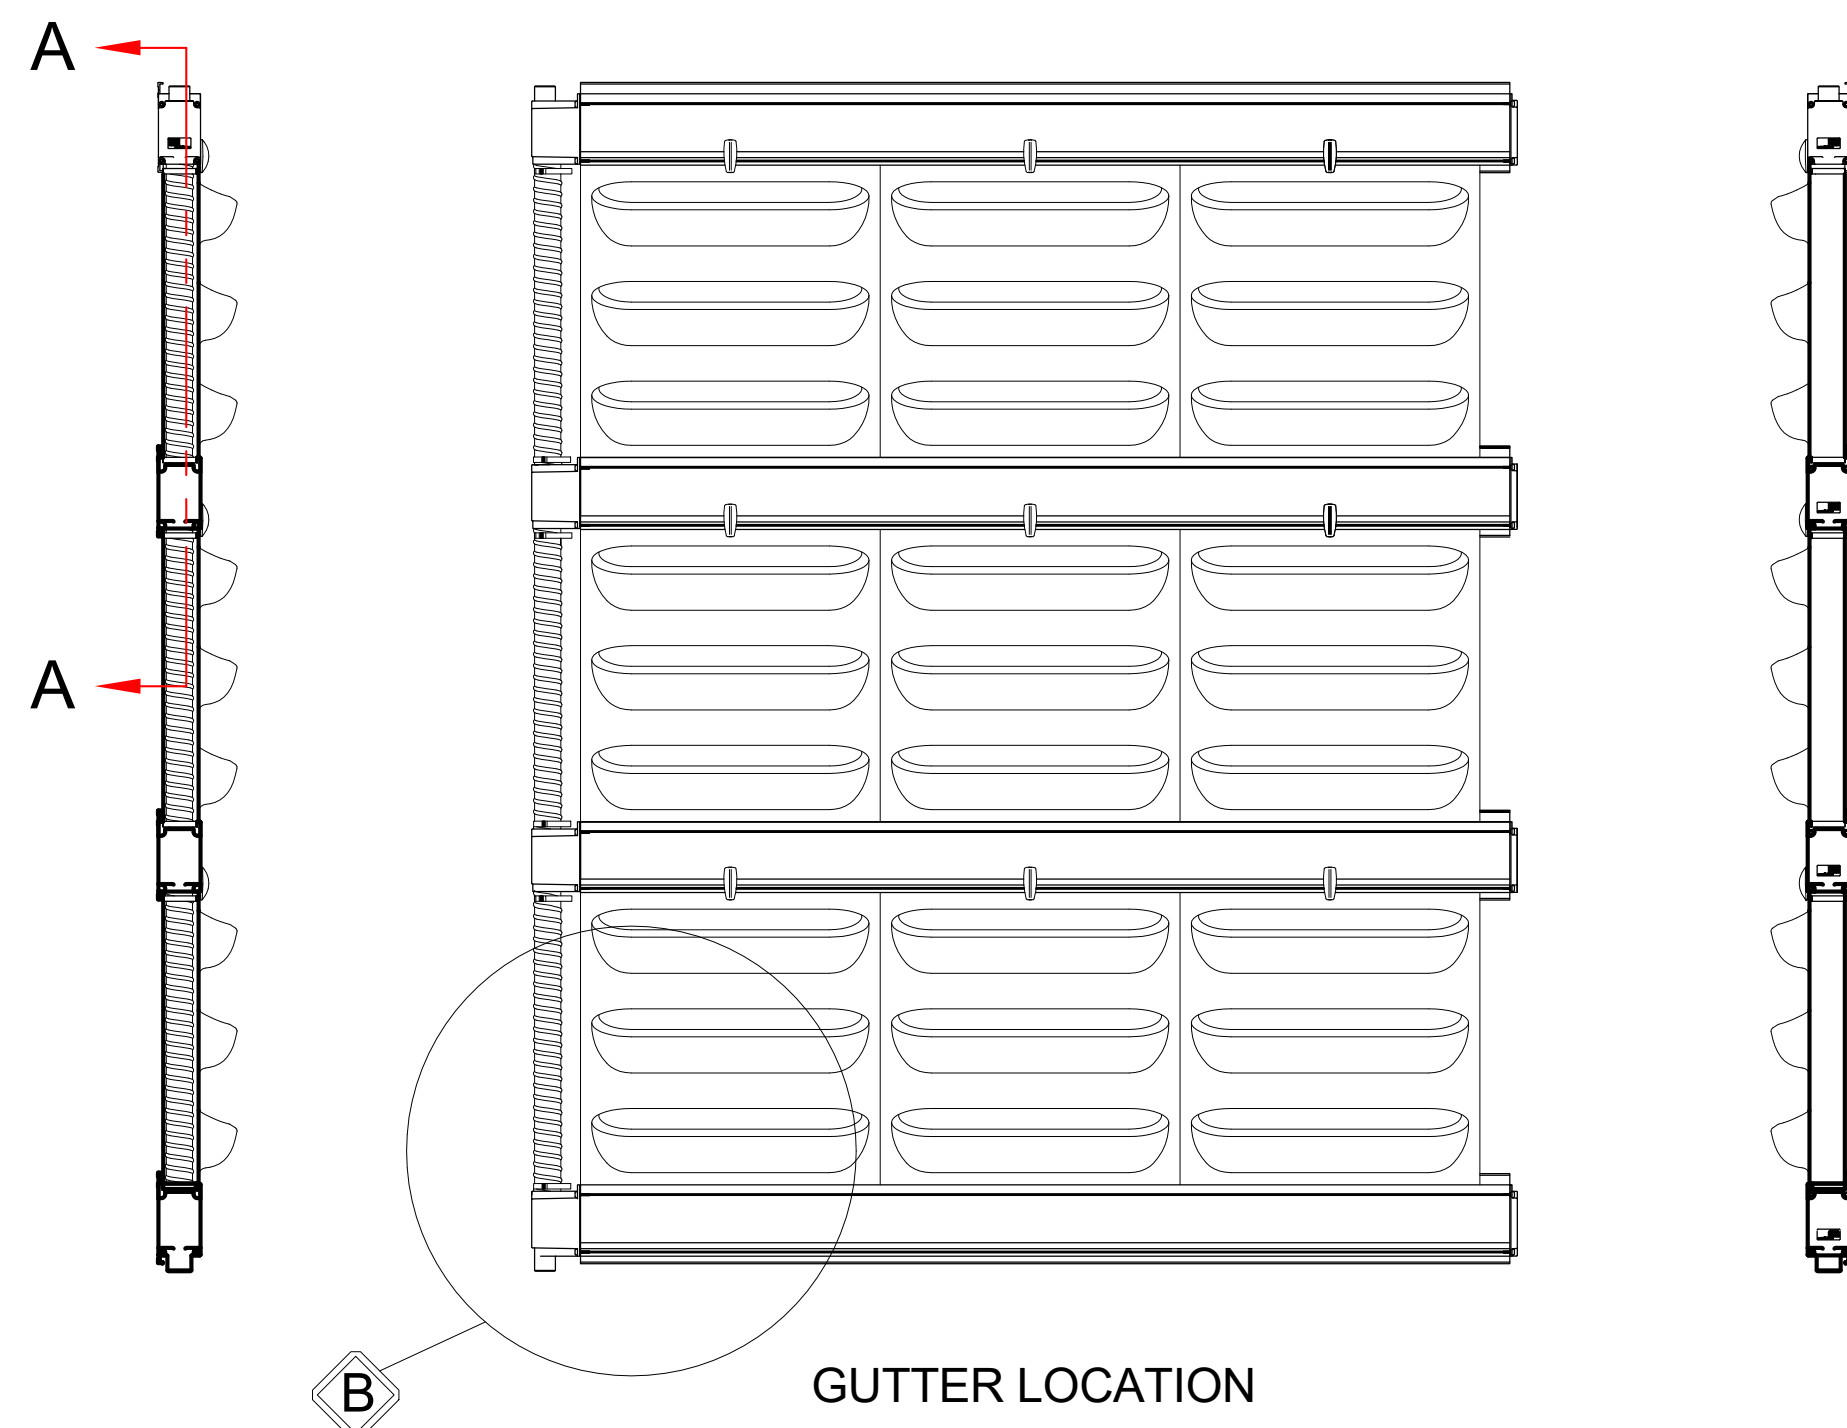

KSU
ID

Kylie Arett

Kylie Arett
ID 645
Spring Semester
kkarett@ksu.edu

The Origins Wellness Center
4TH & PIERRE ST. MANHATTAN,
KS. 66502


Description	Date

GreenWall
Details


Date Issue Date
Drawn by
Checked by

ID-8.4


Scale 3/16" = 1'-0"

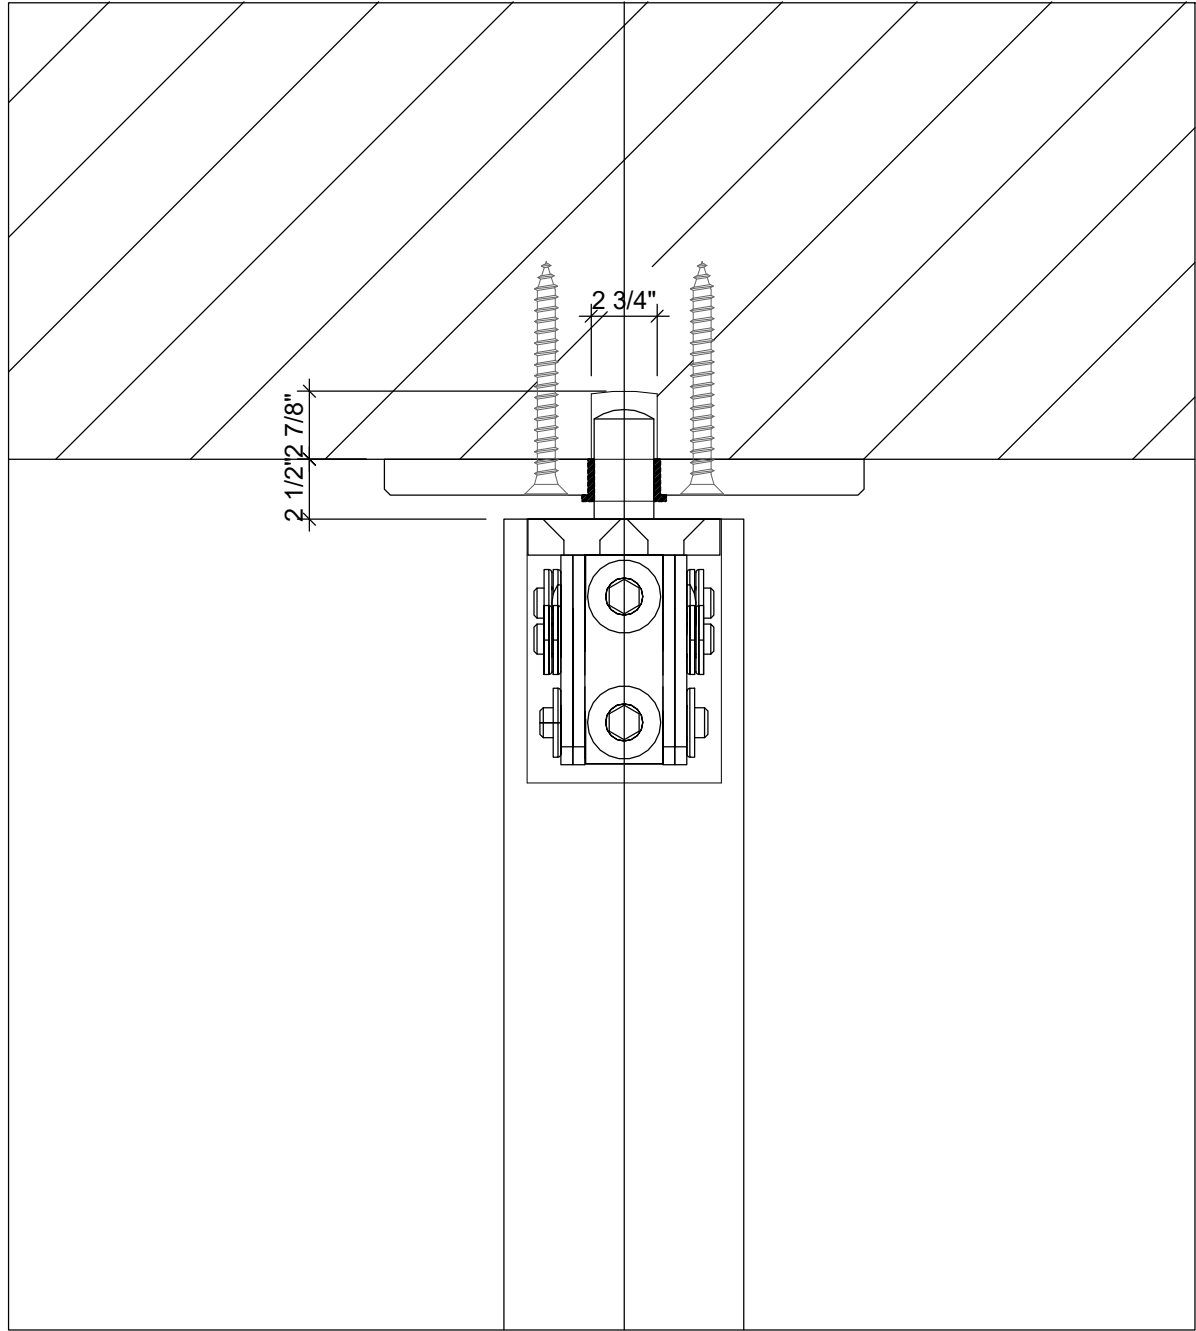


Ceiling Plate 30035X

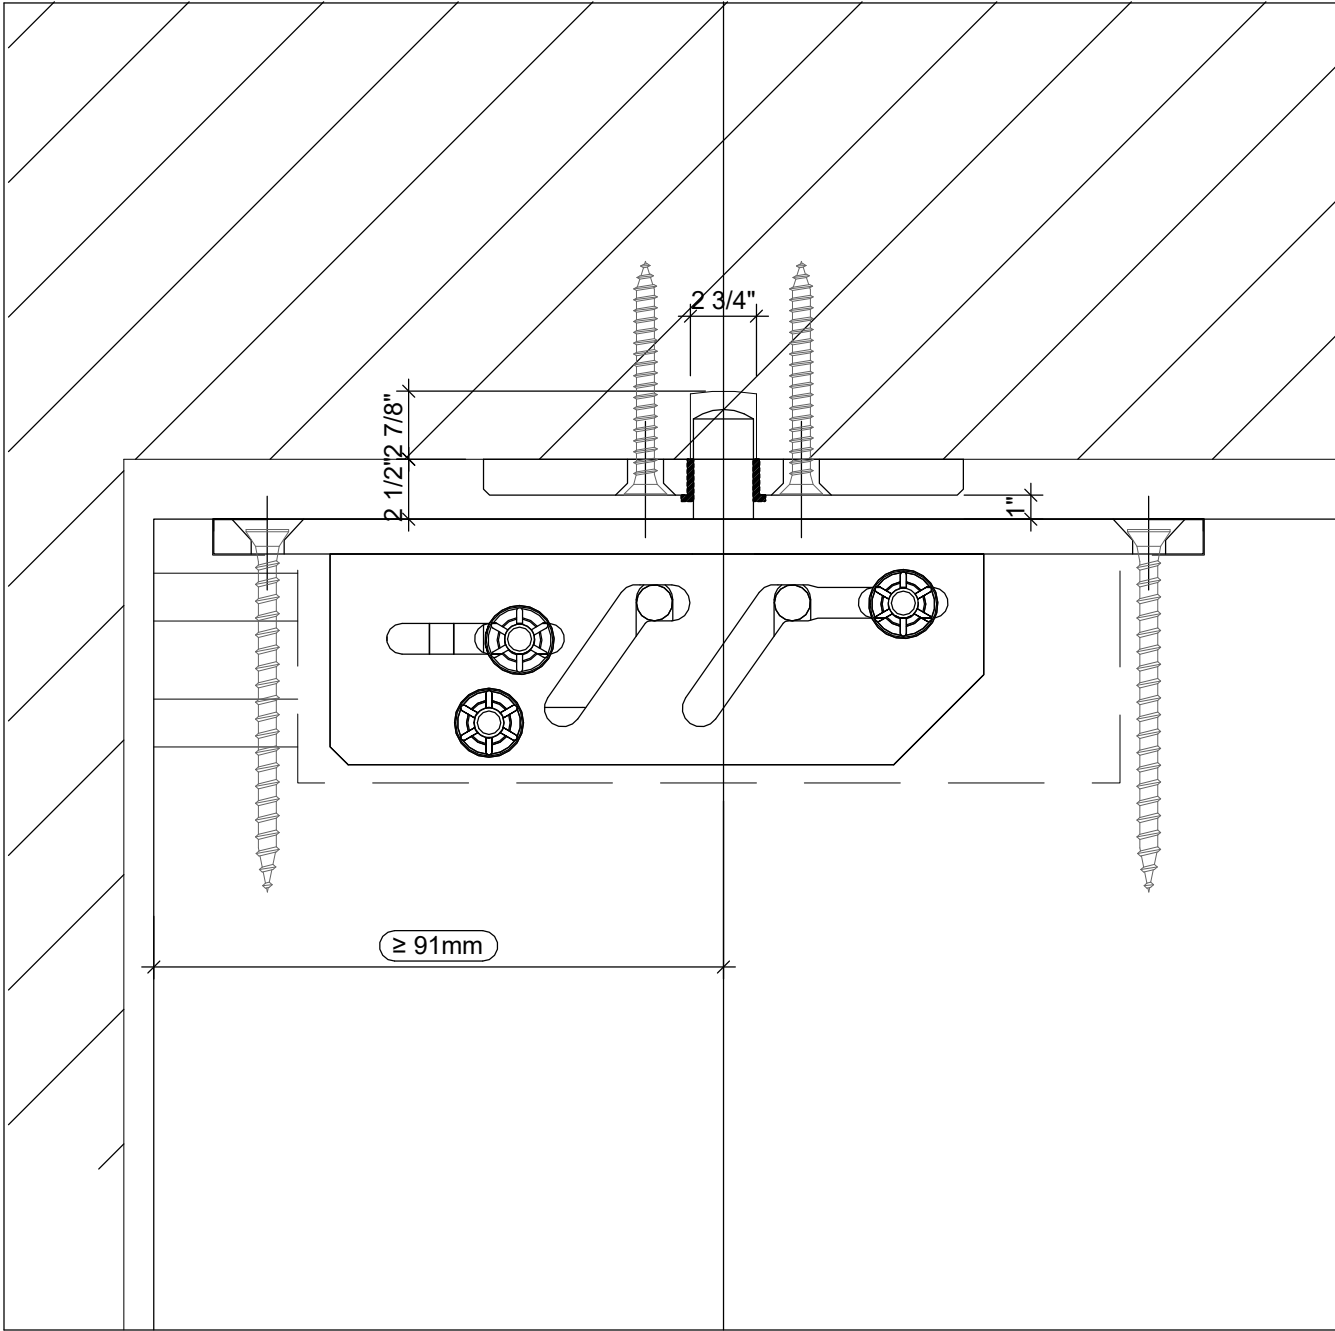

Ceiling Plate 30035X

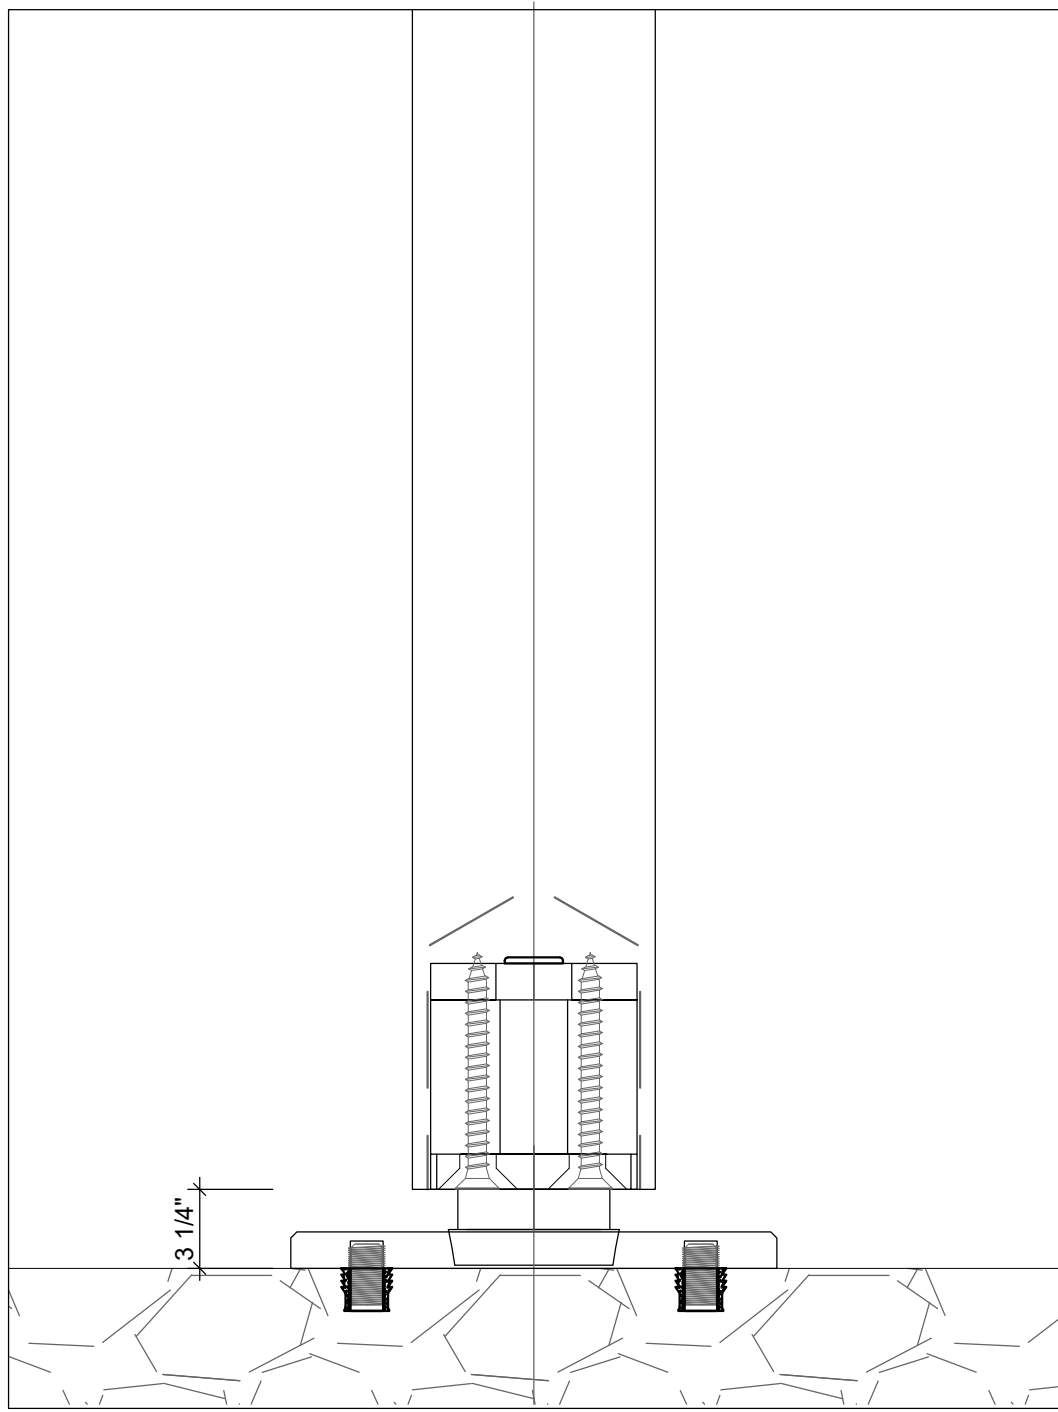


Floor Plate 400401

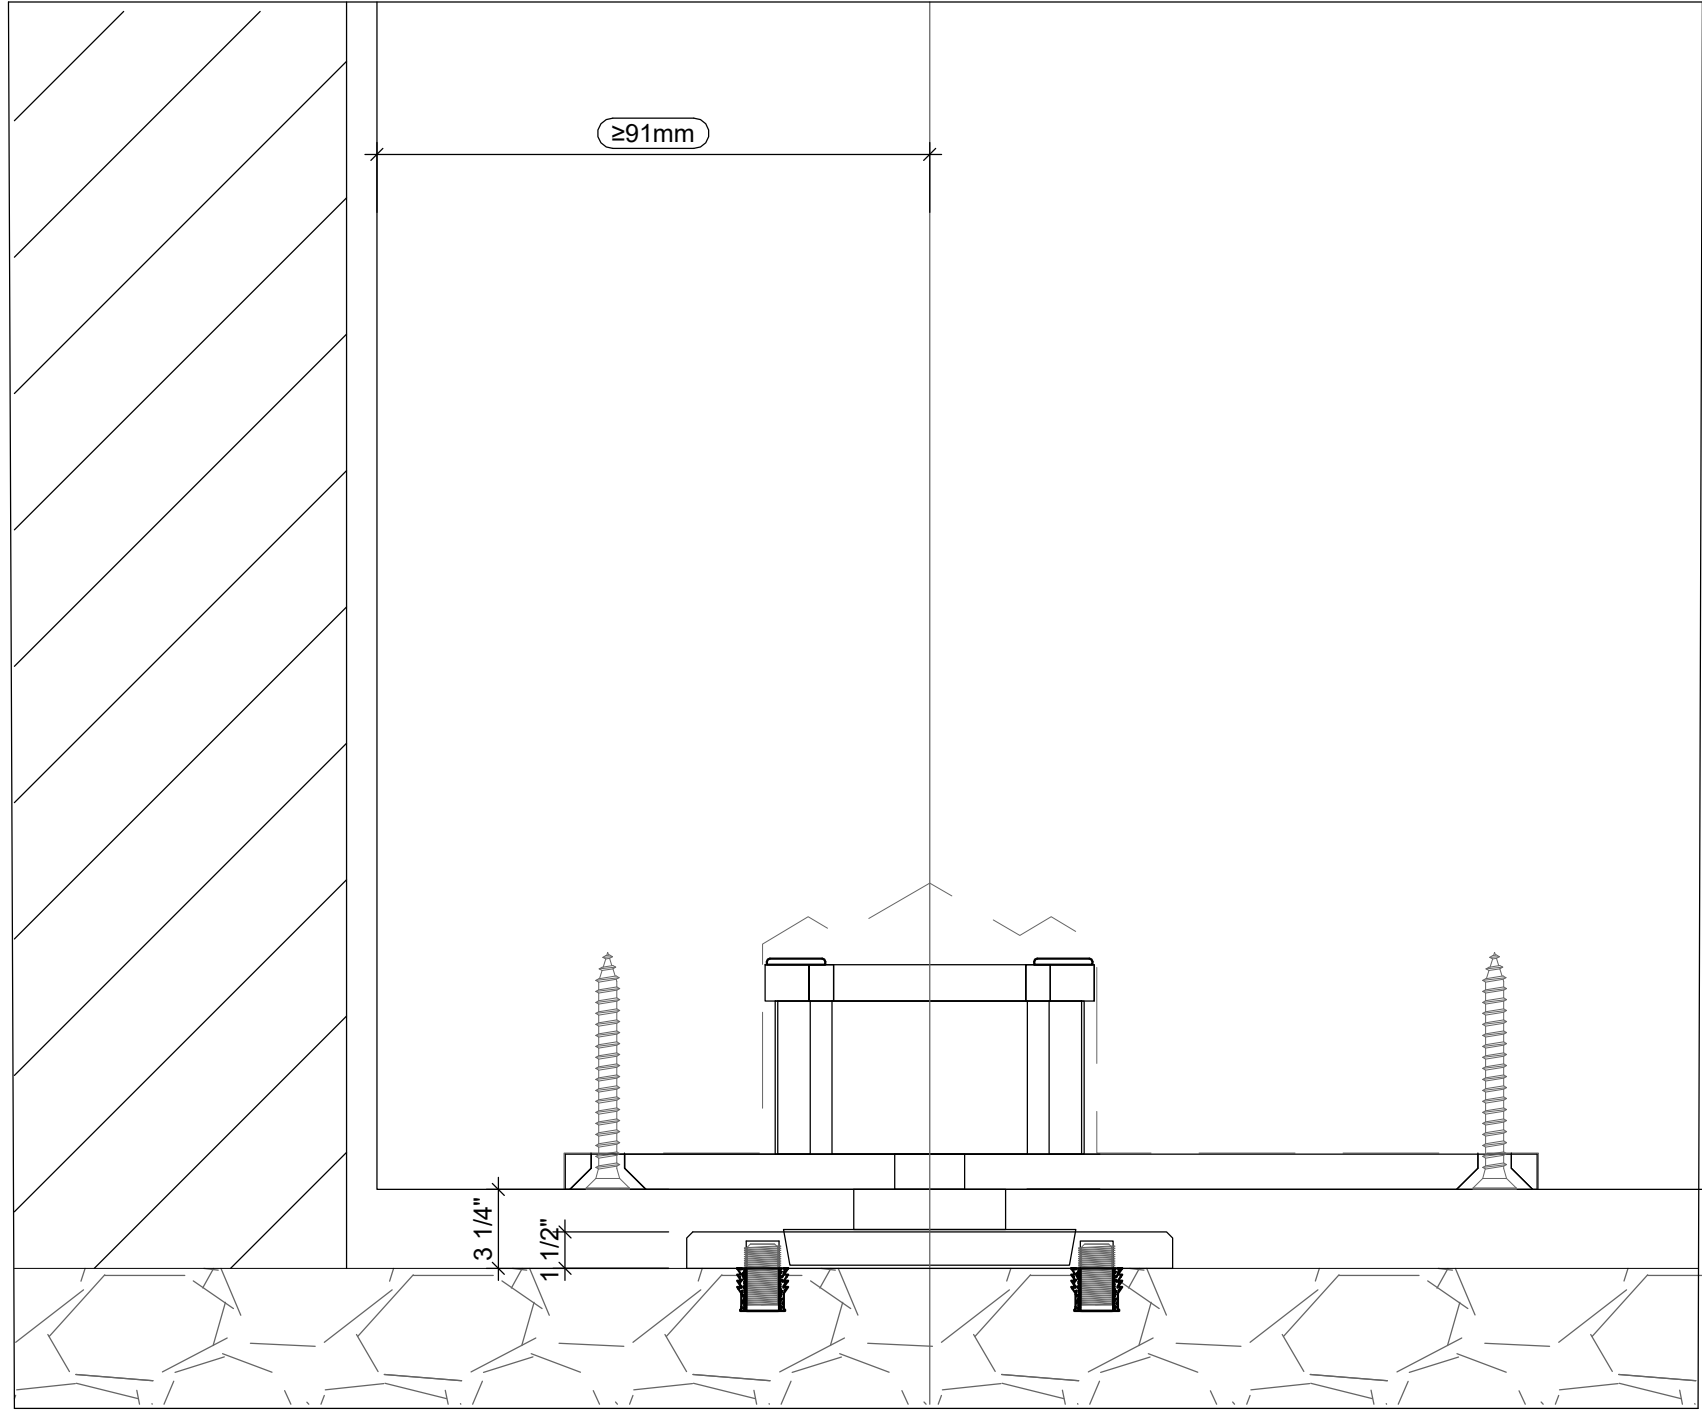


Floor Plate 400401

1 Rotating Partition Details: SystemOne
1 1/2" = 1'-0"


Description	Date

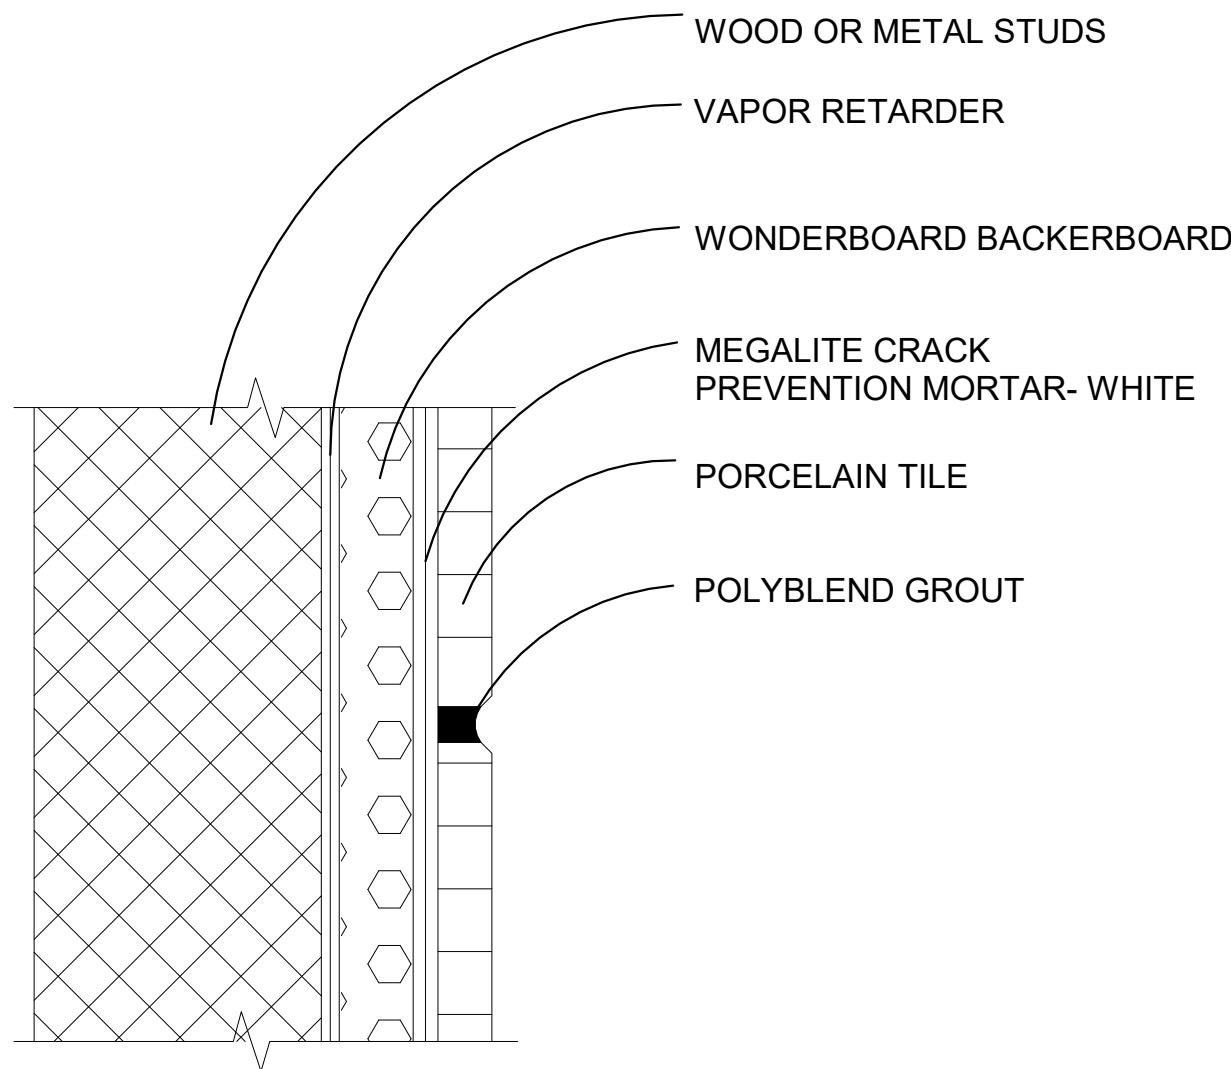


1 Wall Tile Detail
1" = 1'-0"

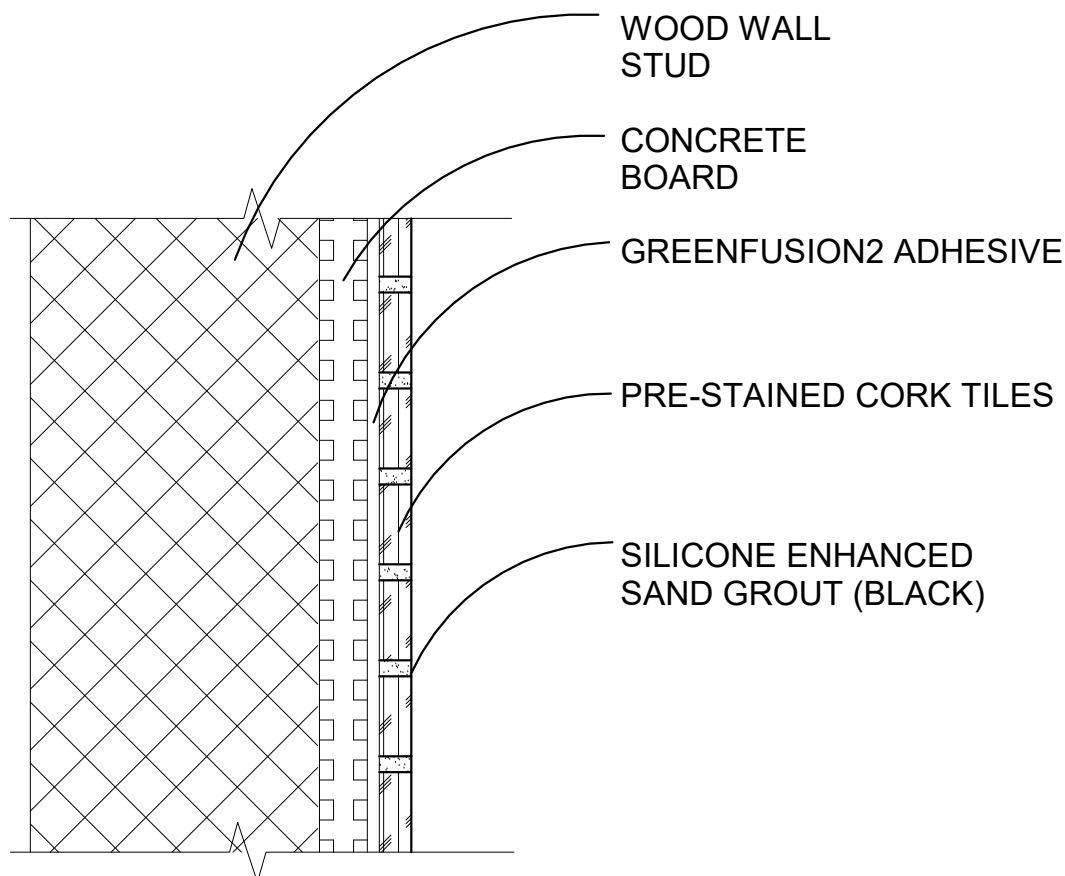


2 Cork Tile Wall Detail
1" = 1'-0"

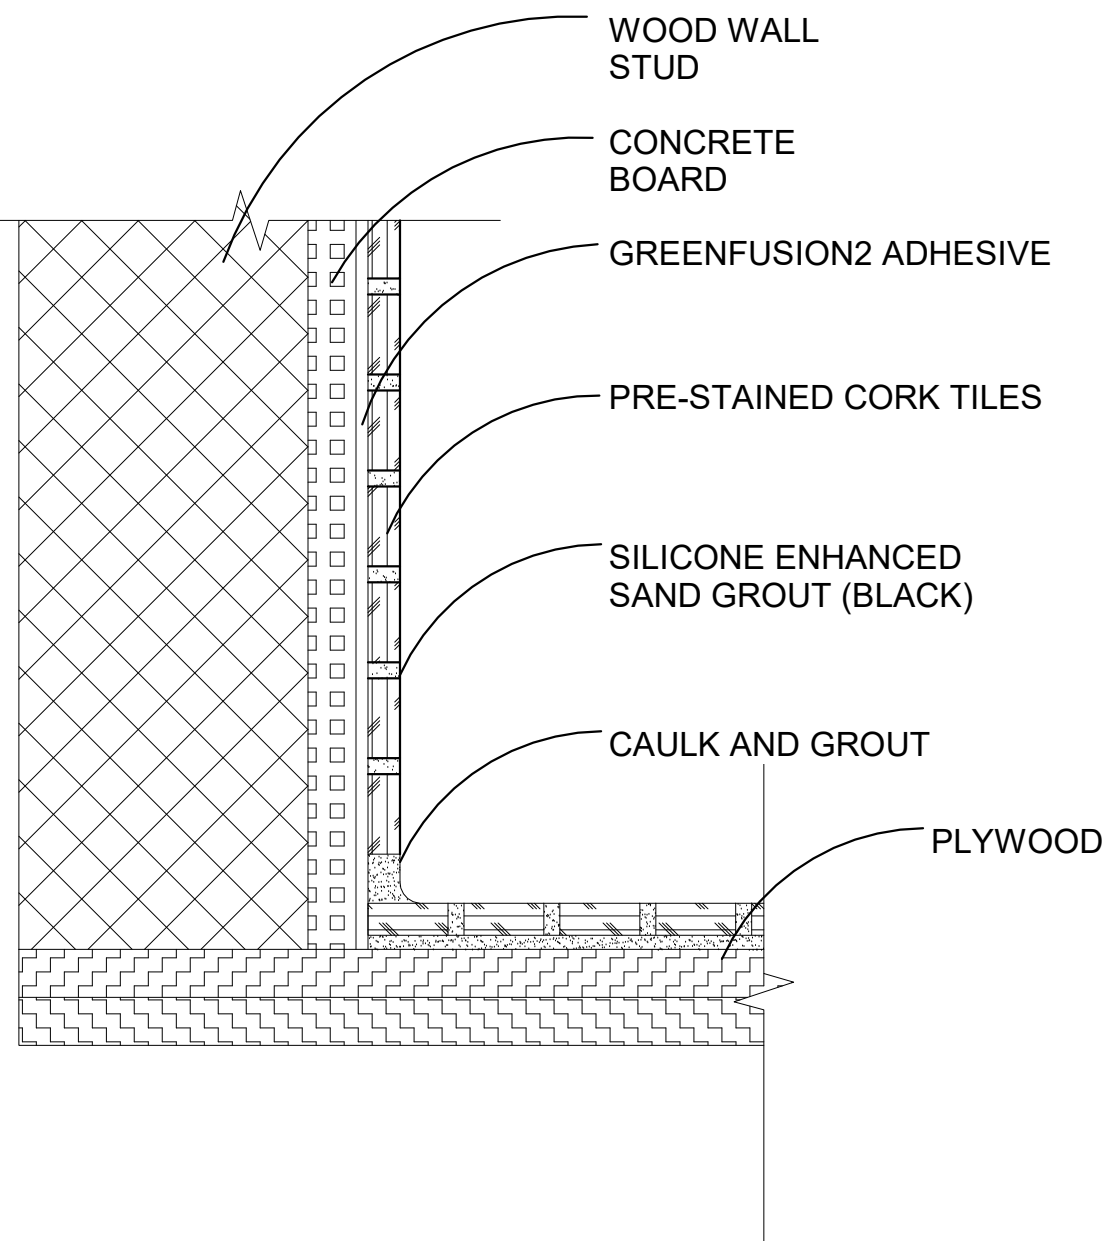


3 Cork Wall - Cork Floor Detail
1" = 1'-0"

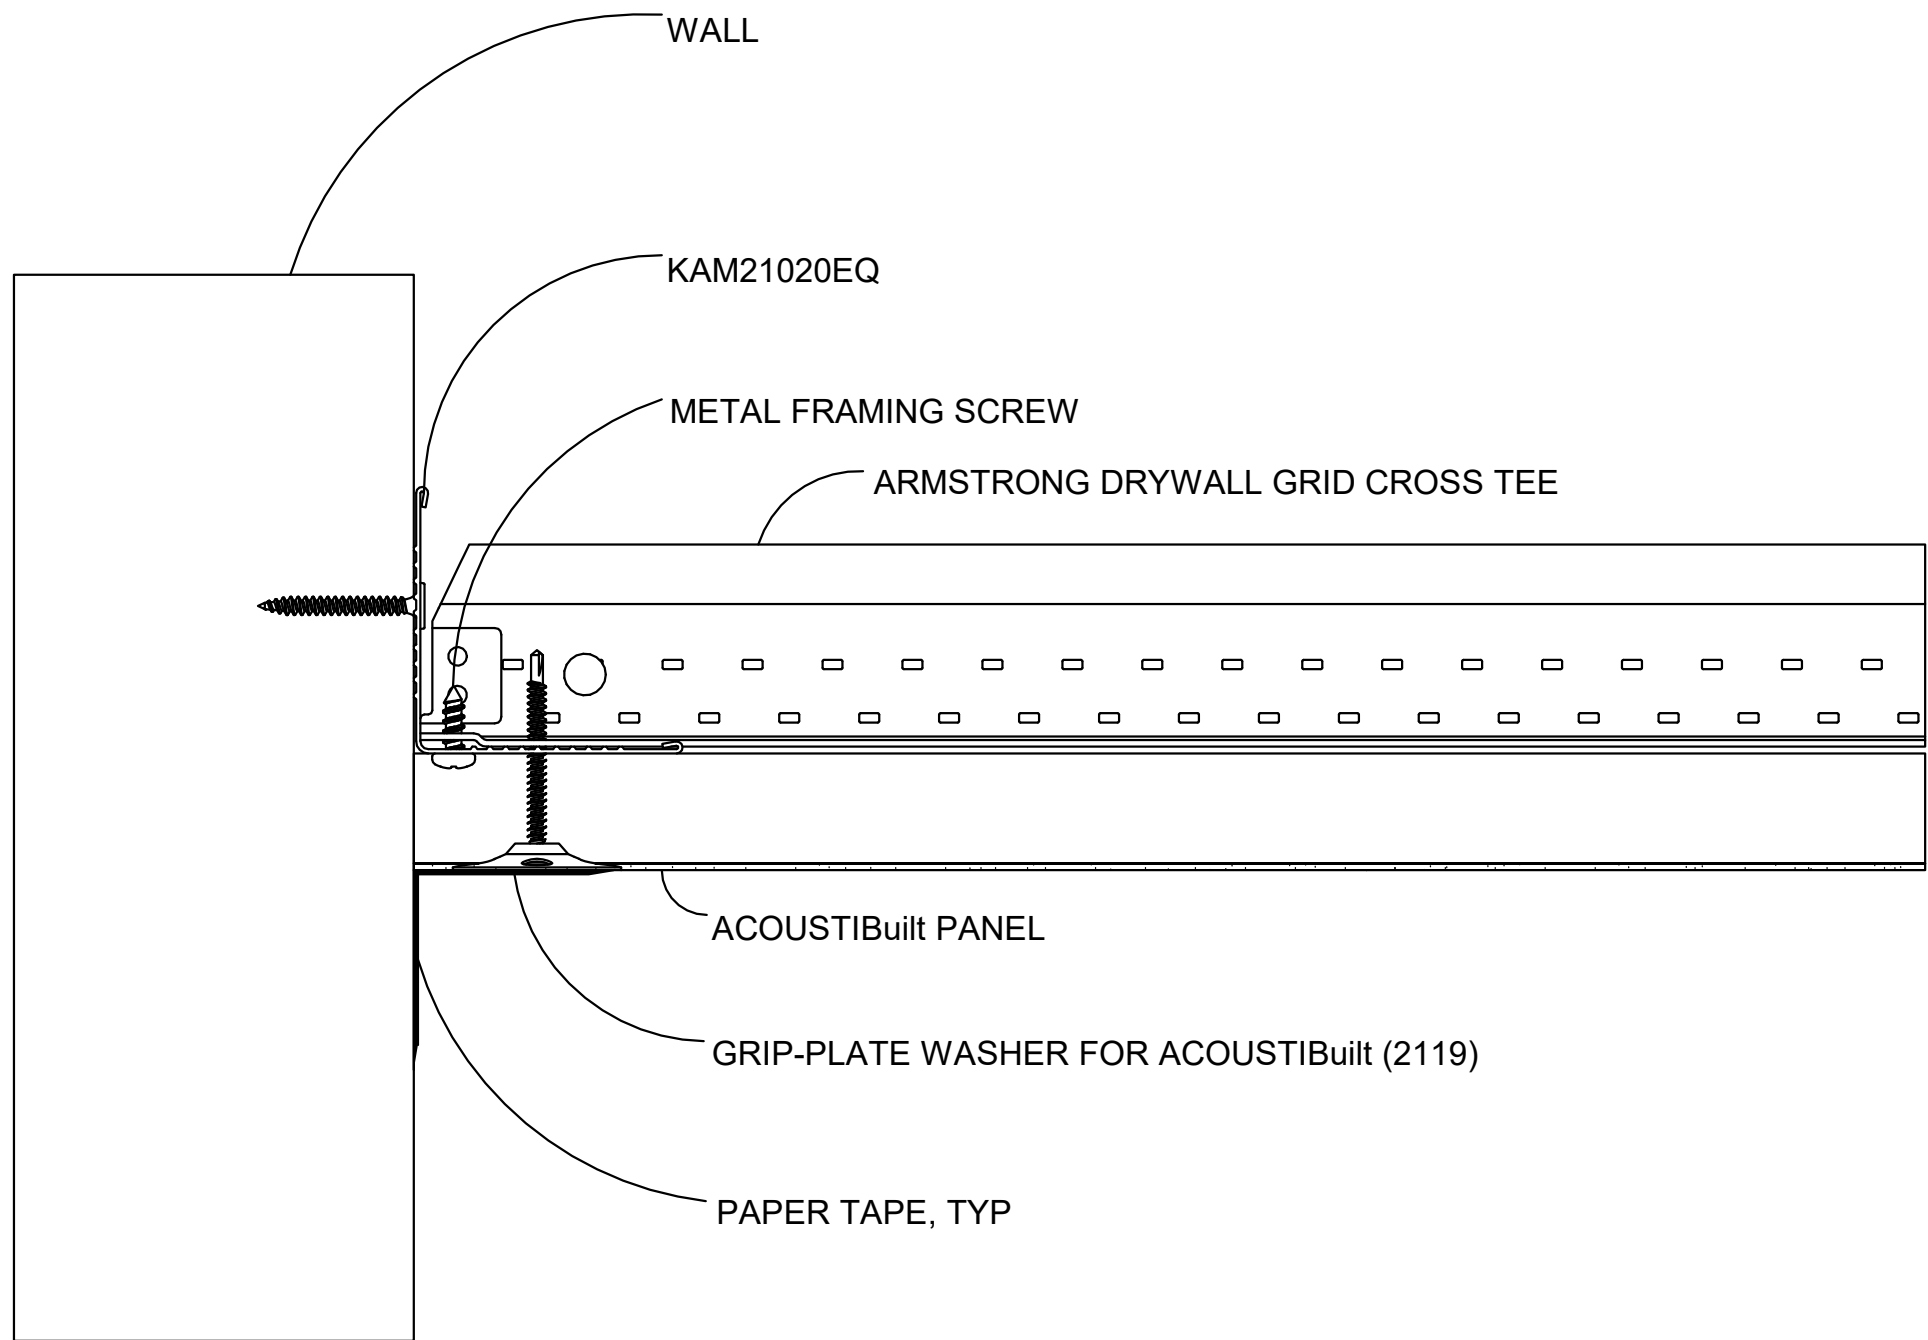


4 ACOUSTiBuilt Finished to Wall
1/2" = 1'-0"

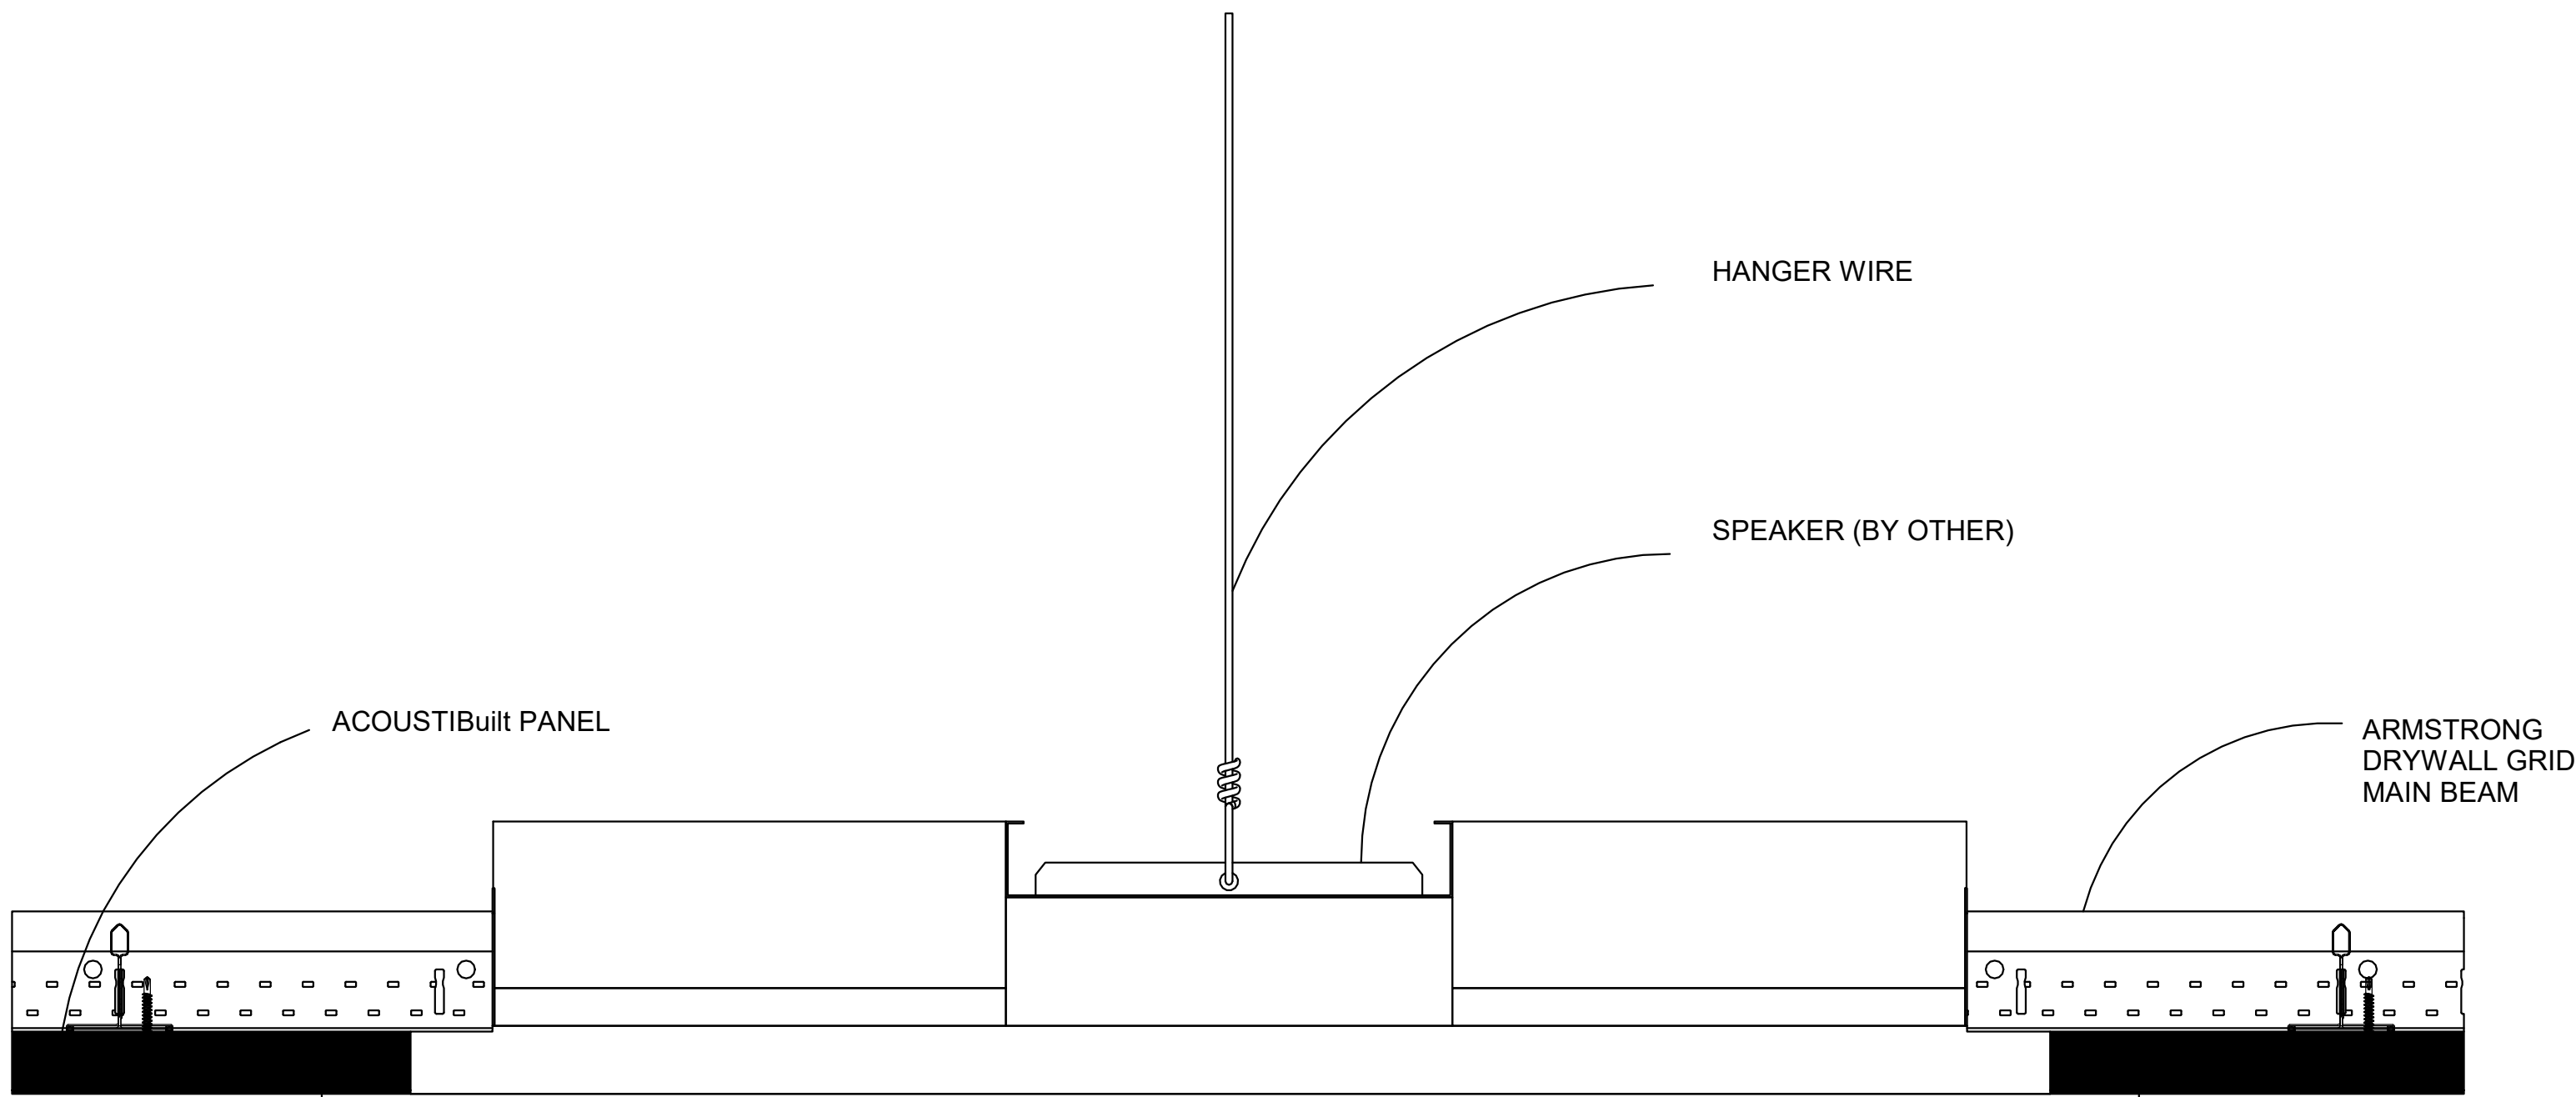

5 ACOUSTiBuilt Ceiling Speaker
12" = 1'-0"

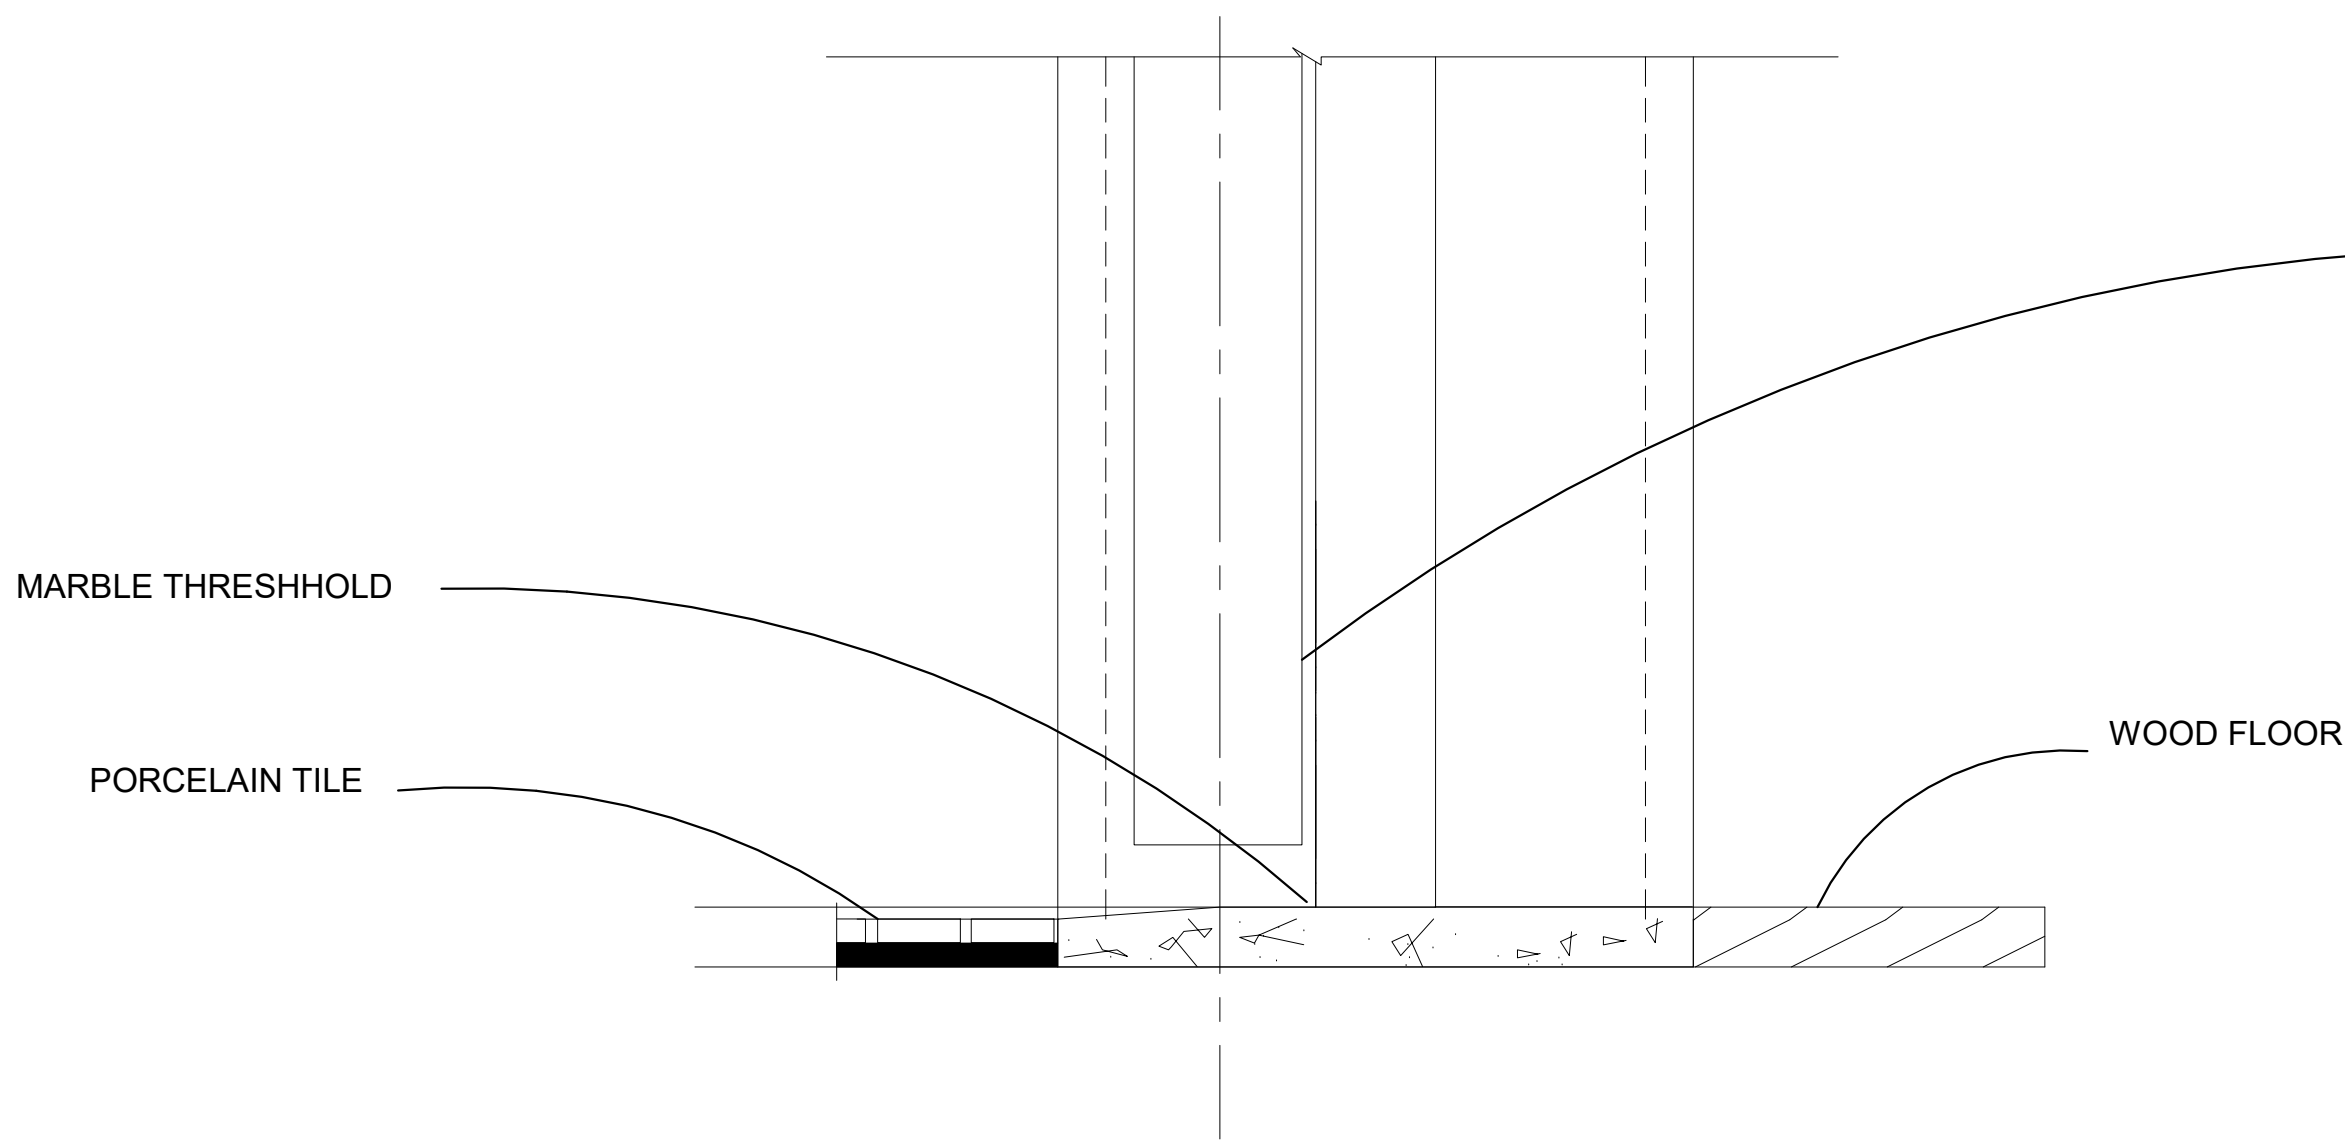

6 Floor Transitions
6" = 1'-0"

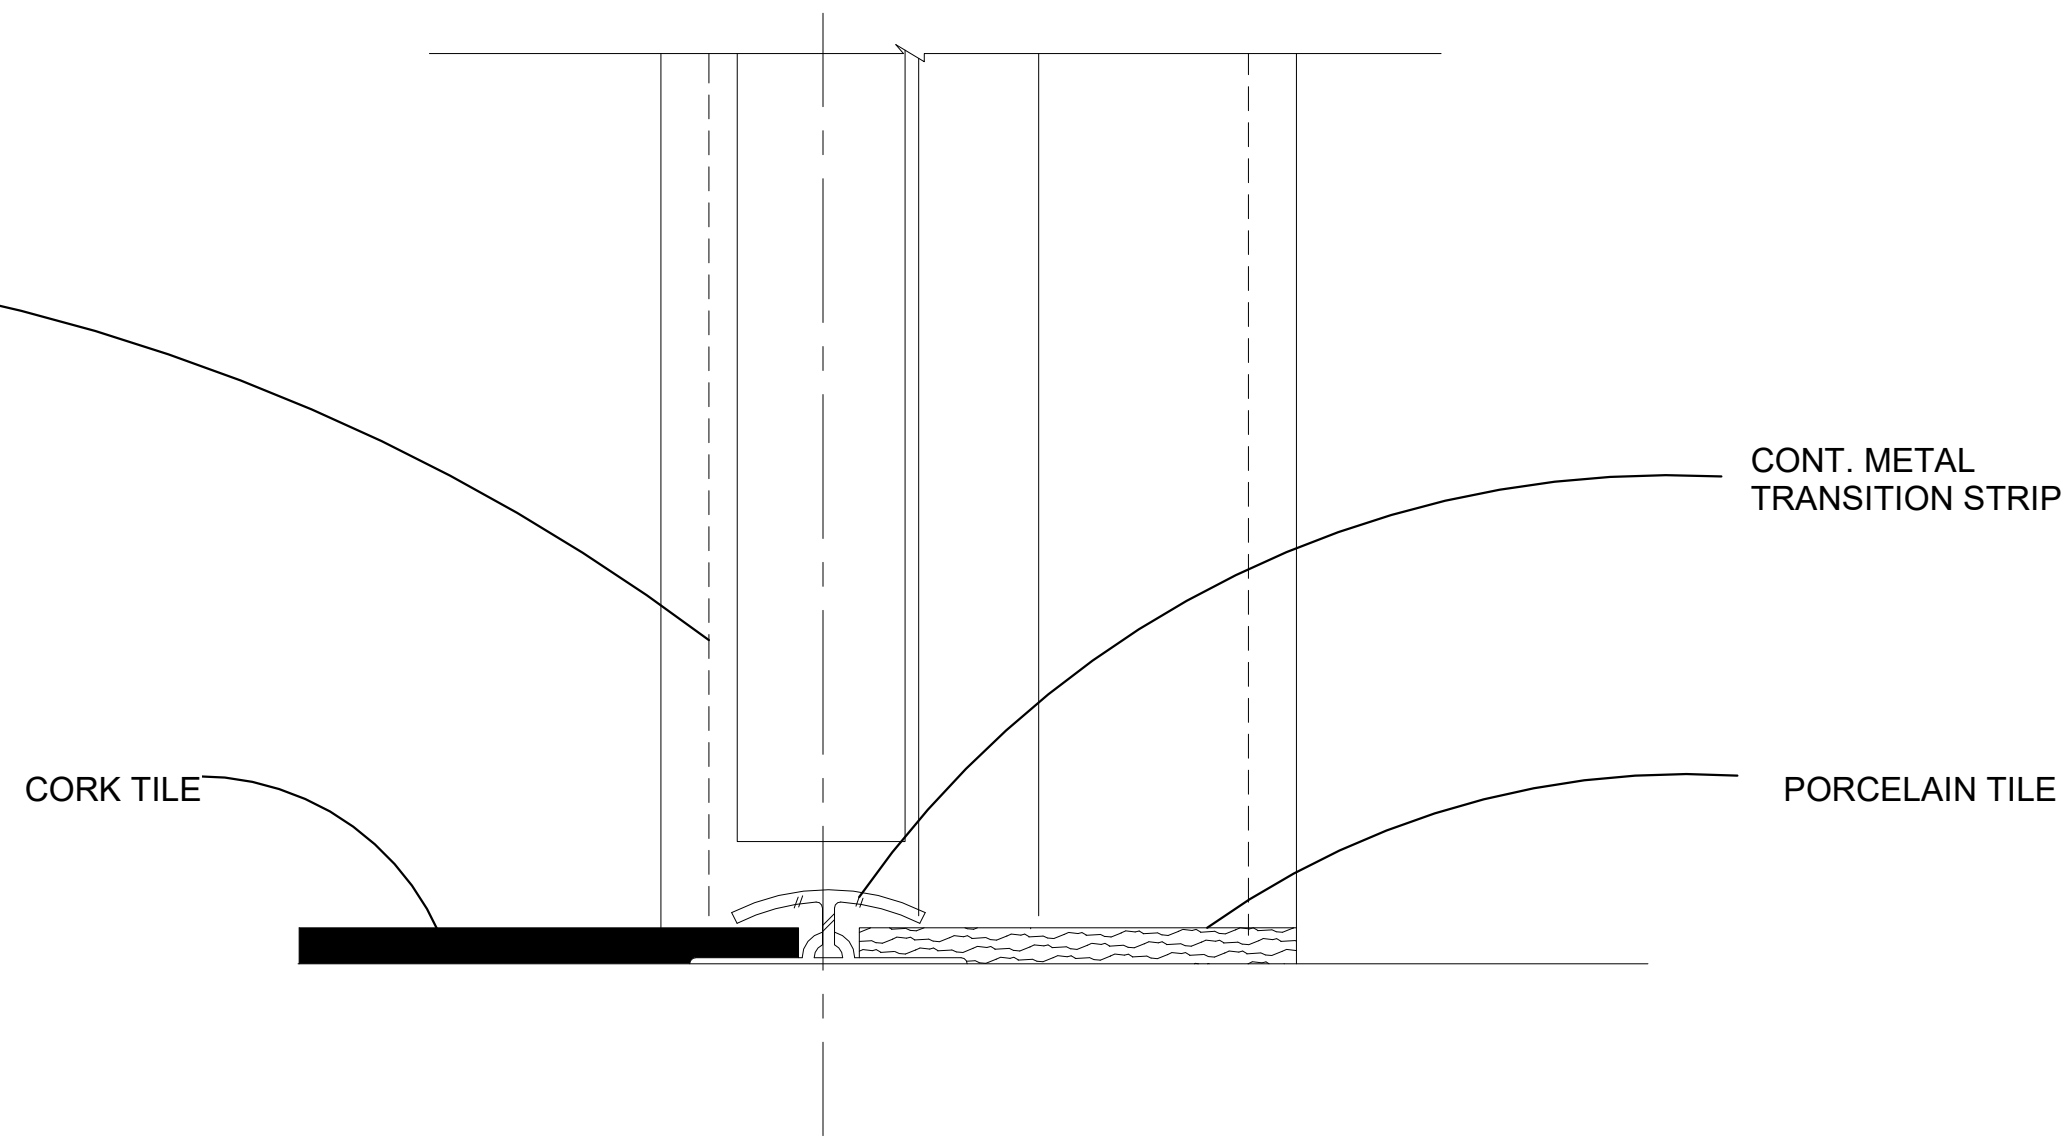

KSU
ID

Kylie Arett

Kylie Arett
ID 645
Spring Semester
kkarett@ksu.edu

The Origins Wellness Center
4TH & PIERRE ST. MANHATTAN,
KS. 66502

Description	Date

Material
Details

Date	Issue Date
Drawn by	
Checked by	
	ID-8.6
Scale	As indicated

4/28/2021 2:39:04 PM

Door Schedule								
Type Mark	Type	Count	Fire Rating	Finish	Frame Material	Height	Width	Hardware
C-3	With Lock	2				1' - 2"	0' - 3"	
CW	Door-Curtain-Wall-Double-Glass	2		Glass	Steel			TYPE D
EX-1	96" x 80"	1	2 HR	Oak	Steel	6' - 8"	8' - 0"	TYPE D
EX-2	84" x 84"	1	2 HR	Oak	Steel	7' - 0"	7' - 0"	TYPE D
BF	48" x 84"	1		Oak	Oak	7' - 0"	4' - 0"	TYPE B
C-1	42" x 84"	3	2 HR	Oak w/ part glass	Steel	7' - 0"	3' - 6"	TYPE D
C-2	42" x 84"	4	2 HR	Oak w/ full glass		7' - 0"	3' - 6"	TYPE D
PD	36" x 96"	8	1 HR	Oak	Oak	7' - 0"	3' - 0"	TYPE B
IN	36" x 84"	5	2 HR	Oak	Steel	7' - 0"	3' - 0"	TYPE A
BD	3 vision pannels	19	1 HR	Oak	Steel	7' - 0"	3' - 0" & 3' - 6"	TYPE C

HARDWARE SCHEDULE

STANDARD INTERIOR DOORS ONLY

DOORS: 3'-0" X 8'-0" X 1-3/4" SOLID CORE, PLAIN SLICE / BOOK MATCH, OAK WITH CUSTOM STAIN
MARSHFIELD (FORMERLY KNOWN AS WEYERHAUSER) - PREMIUM GRADE

STANDARD COMMON CORRIDORS

DOORS: 3'-0" X 8'-10" X 1-3/4" SOLID CORE, PLAIN SLICE / BOOK MATCH, OAK WITH CUSTOM STAIN
MARSHFIELD (FORMERLY KNOWN AS WEYERHAUSER) - PREMIUM GRADE

FRAMES: 2" WIDE KNOCK-DOWN FRAME / PAINT GRADE

HARDWARE:

ALL DOORS:	LEVERS: ANSI 629 (US32)
INTERIOR DOORS:	HINGES: ANSI 625 (US26)
COMMON CORRIDOR SIDE ONLY:	HINGES: ANSI 627 (US9)
INTERIOR DOORS:	ROSES, FACEPLATES, STRIKES, ETC.,...: ANSI 625 (US26)
COMMON CORRIDOR SIDE ONLY:	ROSES, FACEPLATES, STRIKES, ETC.,...: ANSI 627 (US9)

HARDWARE SETS

TYPE A: CUSTOM INTERIOR DOOR W/ PASSAGE SET AND CLOSER

(2) PAIR HINGES: STANLEY CB1900
(1) PASSAGE SET: SCHLAGE L9010-07
(1) FLOOR STOP: ROCKWOOD RW483
(1) SILENCERS: NATIONAL GUARD
(1) SURFACE CLOSERS: LCN 1461
(1) LEVER SET: ASSA/EMTEK AIREON

TYPE B: CUSTOM INTERIOR POCKET DOOR


(2) PAIR HINGES: STANLEY CB1900
(1) PASSAGE SET: JODIE 950691
(1) FLOOR STOP: ROCKWOOD RW483
(1) SILENCERS: NATIONAL GUARD
(1) SURFACE CLOSERS: N/A
(1) LEVER SET: N/A

TYPE C: CUSTOM INTERIOR BARN DOOR


(2) PAIR HINGES: STANLEY CB1900
(1) PASSAGE SET: ADLEIGH 950690
(1) FLOOR STOP: ROCKWOOD RW483
(1) SILENCERS: NATIONAL GUARD
(1) SURFACE CLOSERS: N/A
(1) LEVER SET: N/A

TYPE D: CUSTOM INTERIOR EXIT DOOR W/ PASSAGE SET


(2) PAIR HINGES: STANLEY CB1900
(1) PASSAGE SET: SCHLAGE L9010-07
(1) FLOOR STOP: ROCKWOOD RW483
(2) SILENCERS: NATIONAL GUARD
(1) LEVER SET: ASSA/EMTEK AIREON

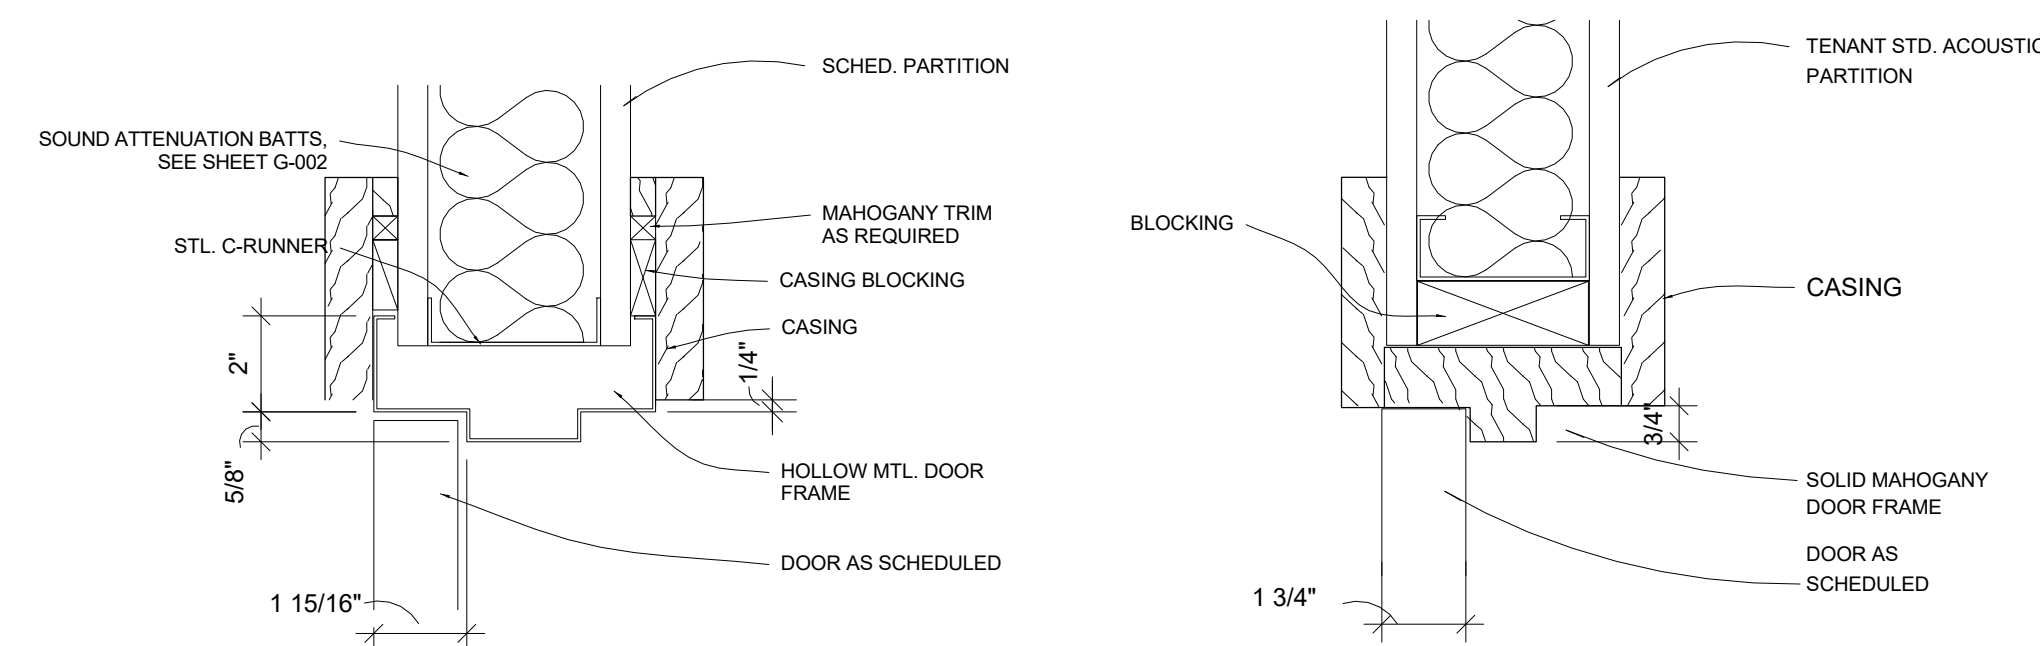


1 Head Details
3" = 1'-0"

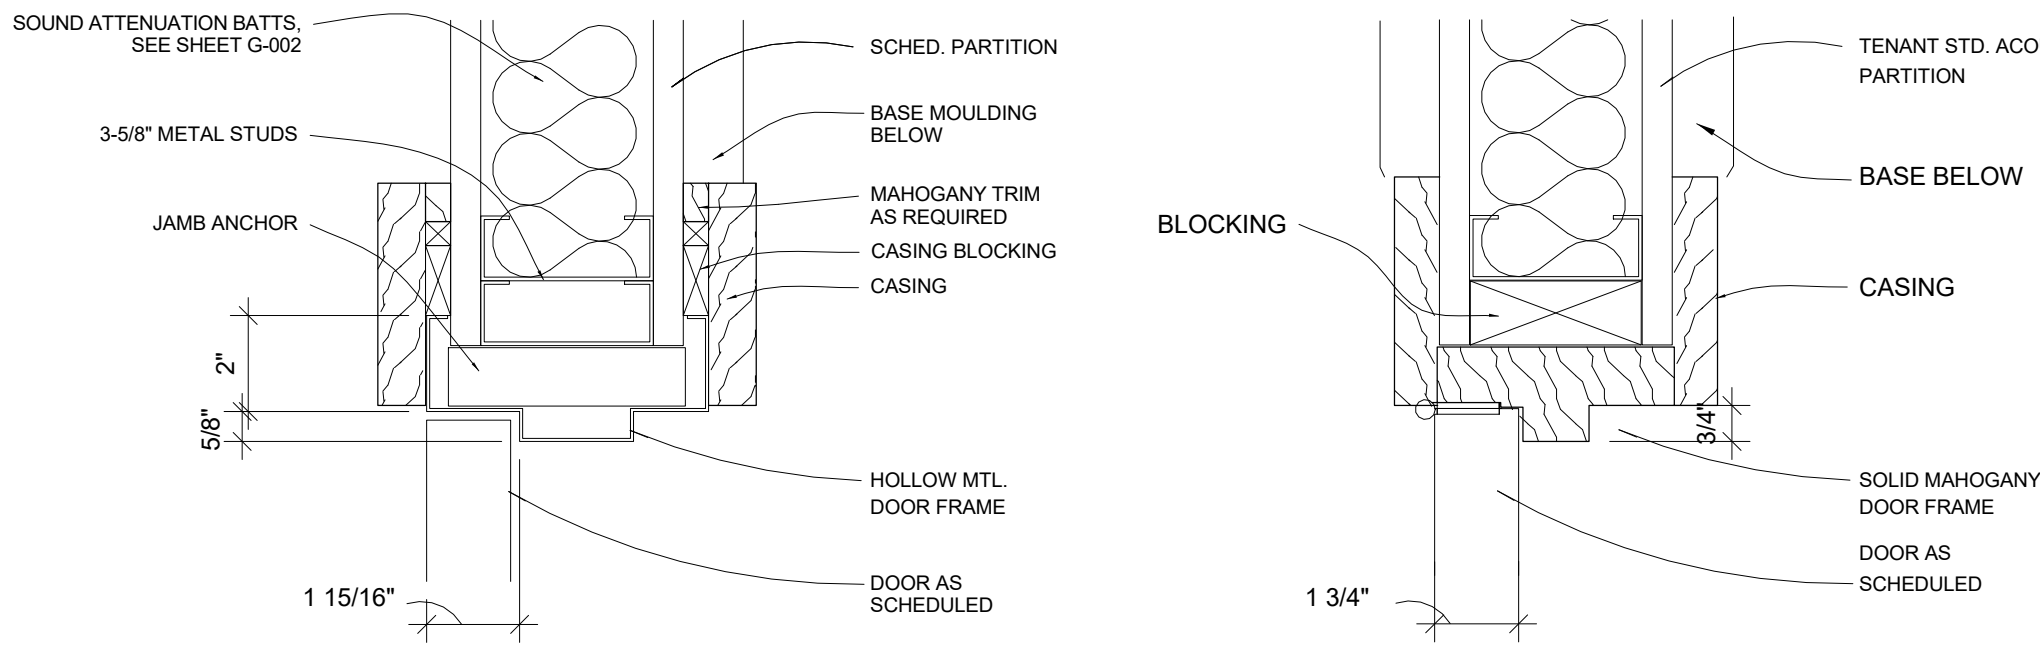


2 Jamb Details
3" = 1'-0"

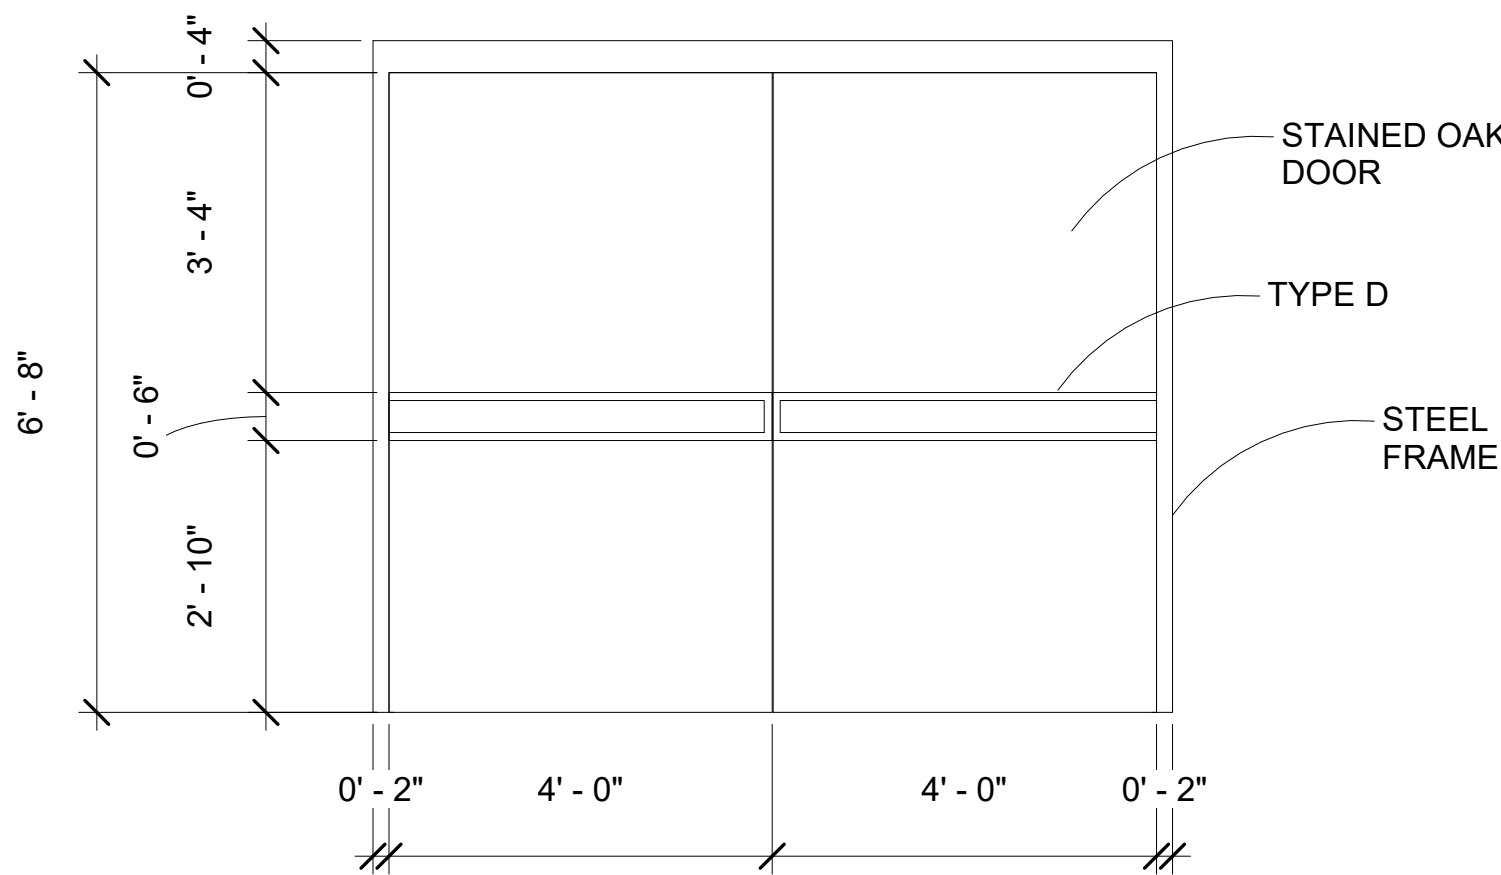


3 Type EX-1
1/2" = 1'-0"

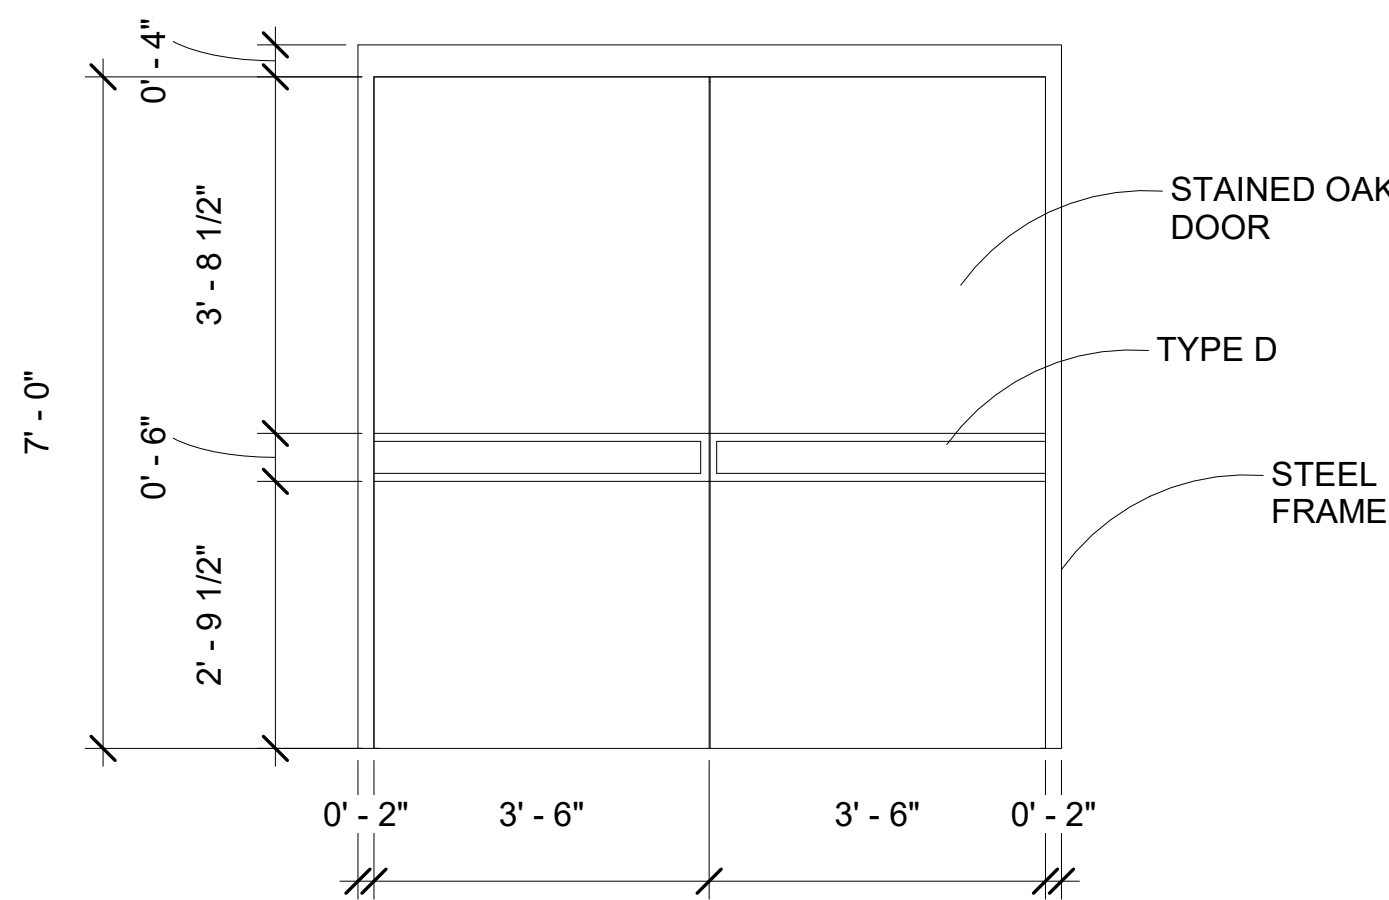


4 Type EX-2
1/2" = 1'-0"

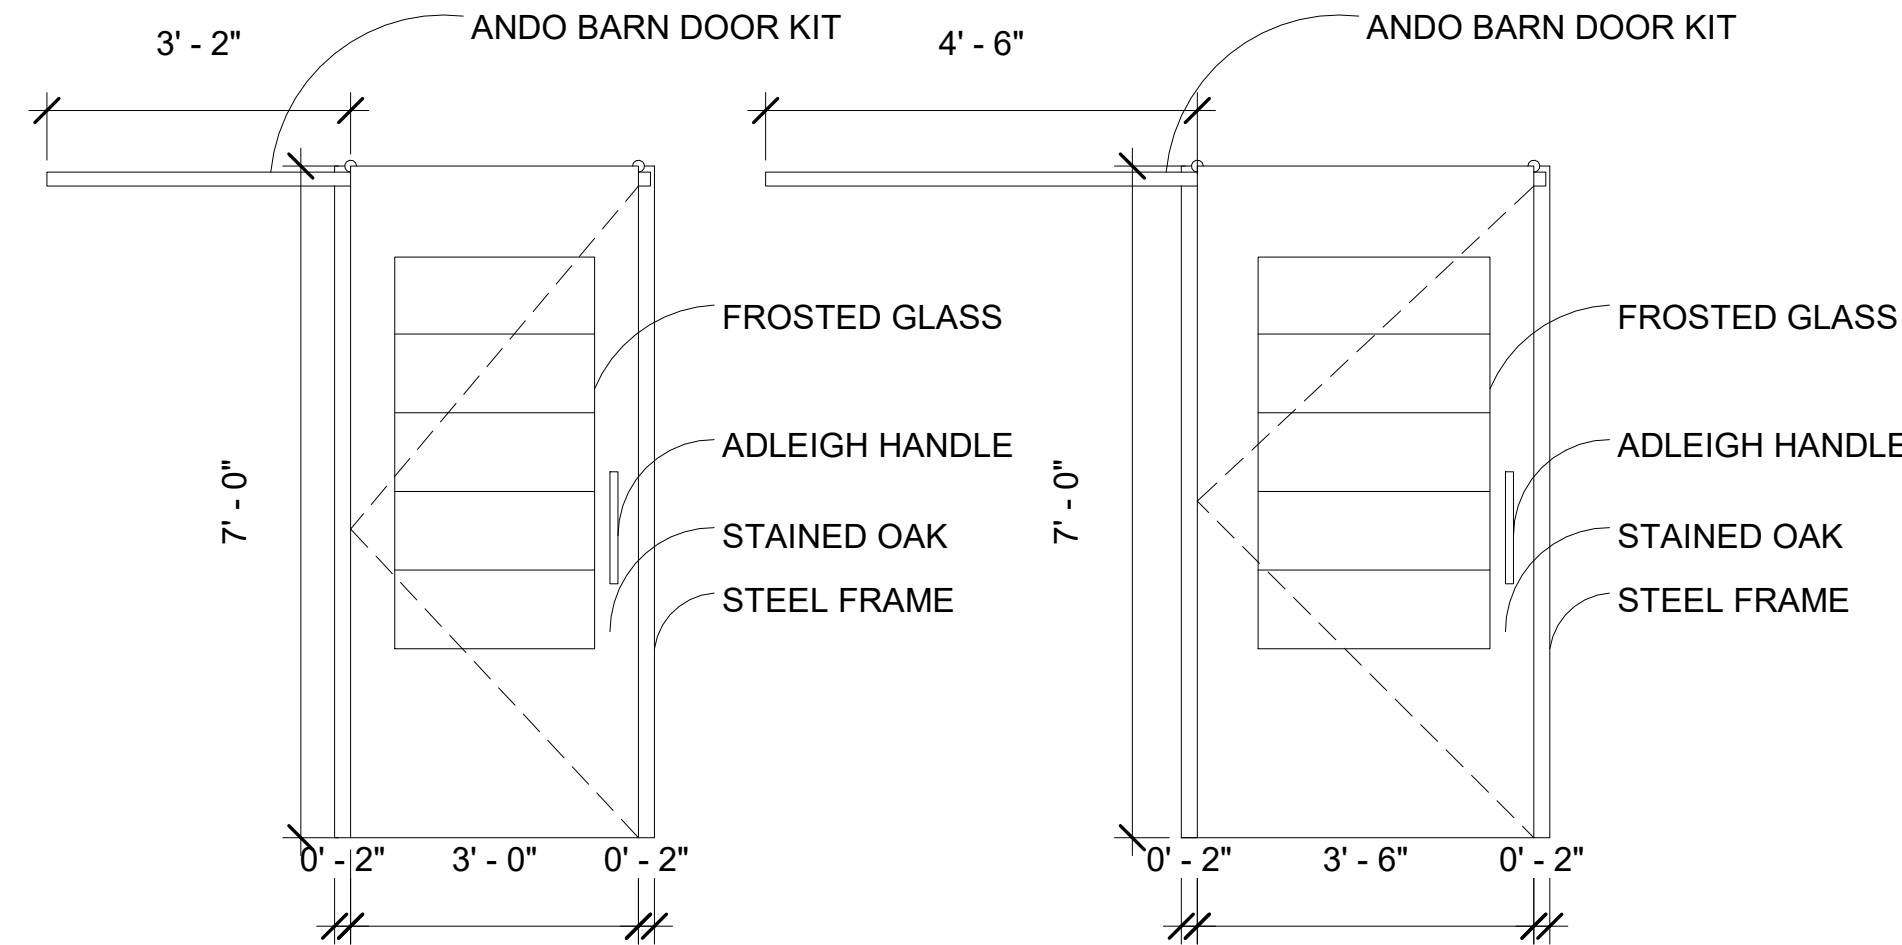


5 Type BD
1/2" = 1'-0"

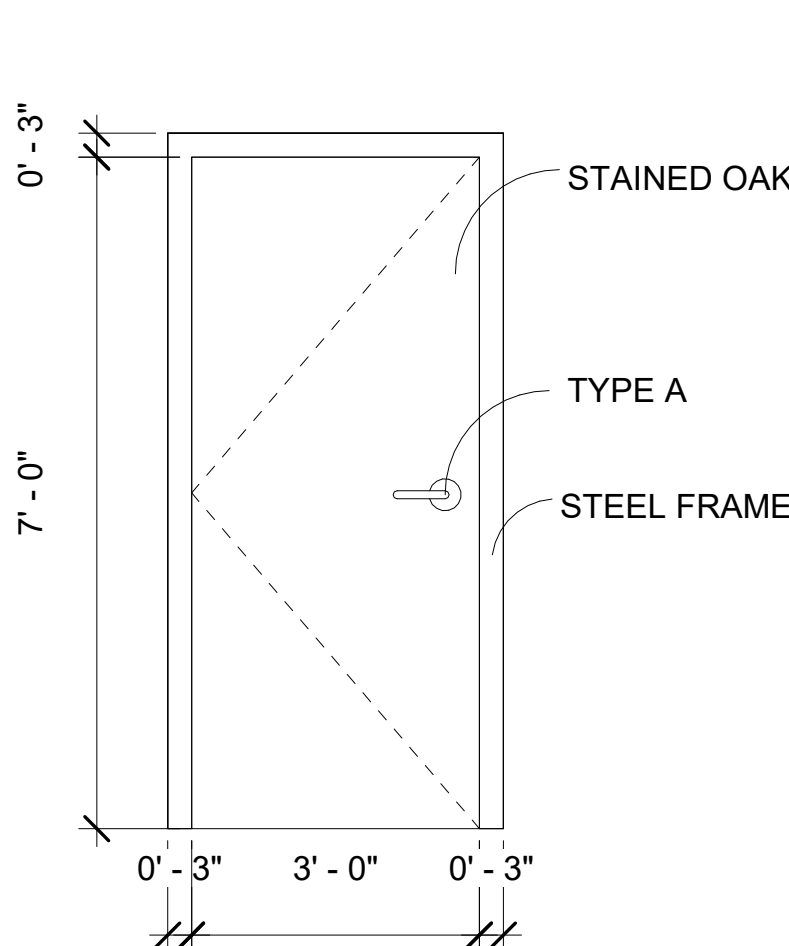


6 Type IN
1/2" = 1'-0"

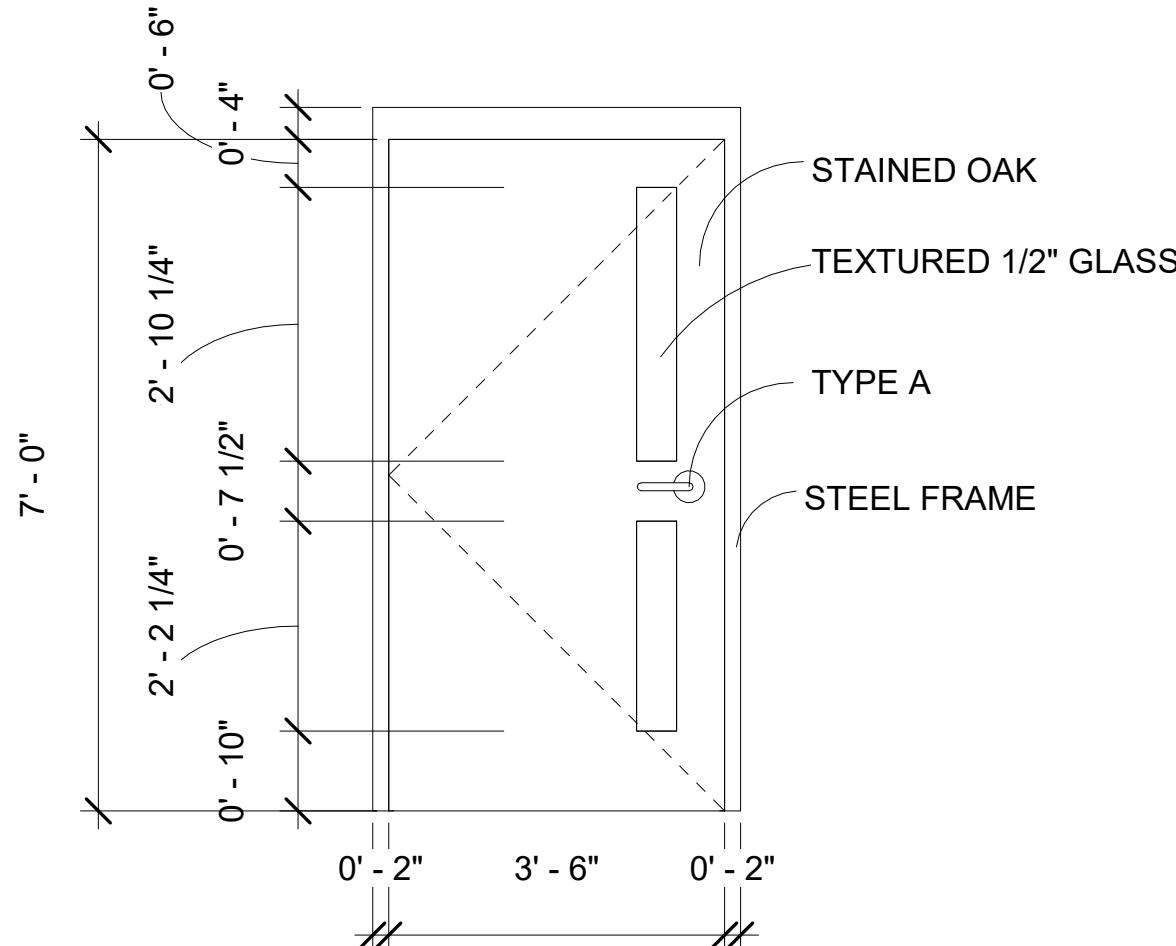


7 Type C-2
1/2" = 1'-0"

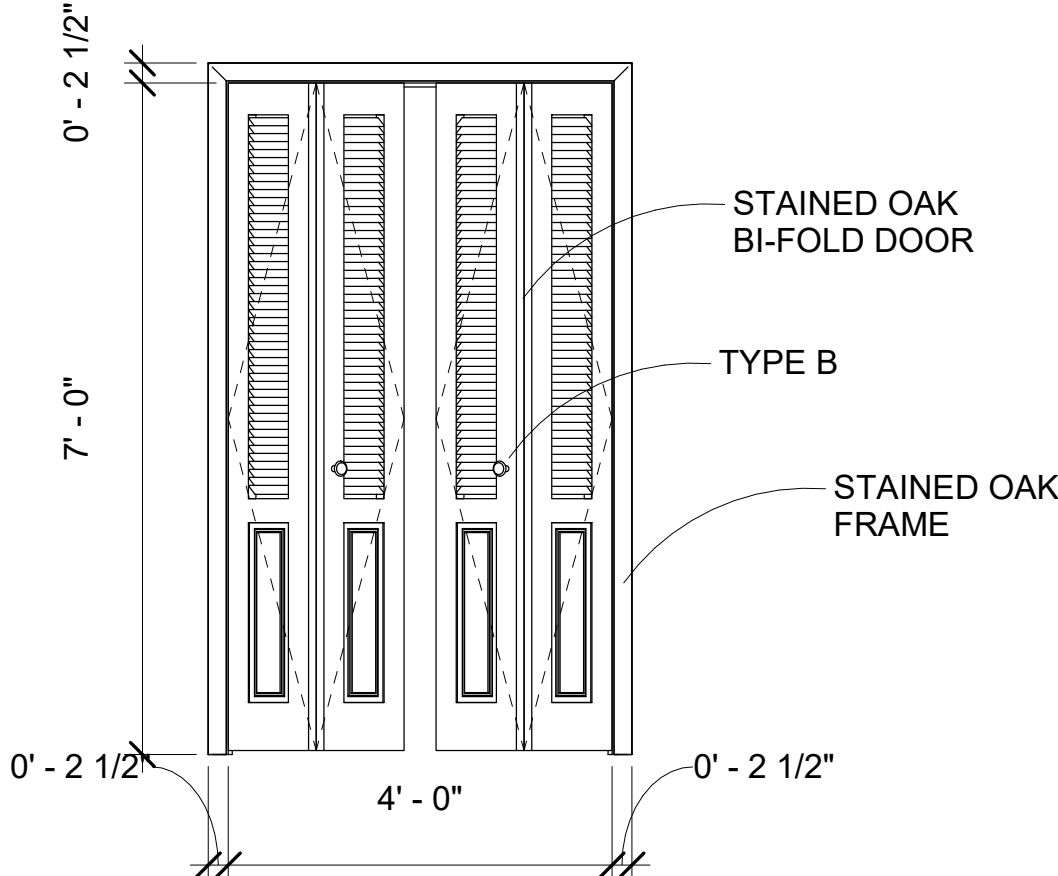

8 Type BF
1/2" = 1'-0"

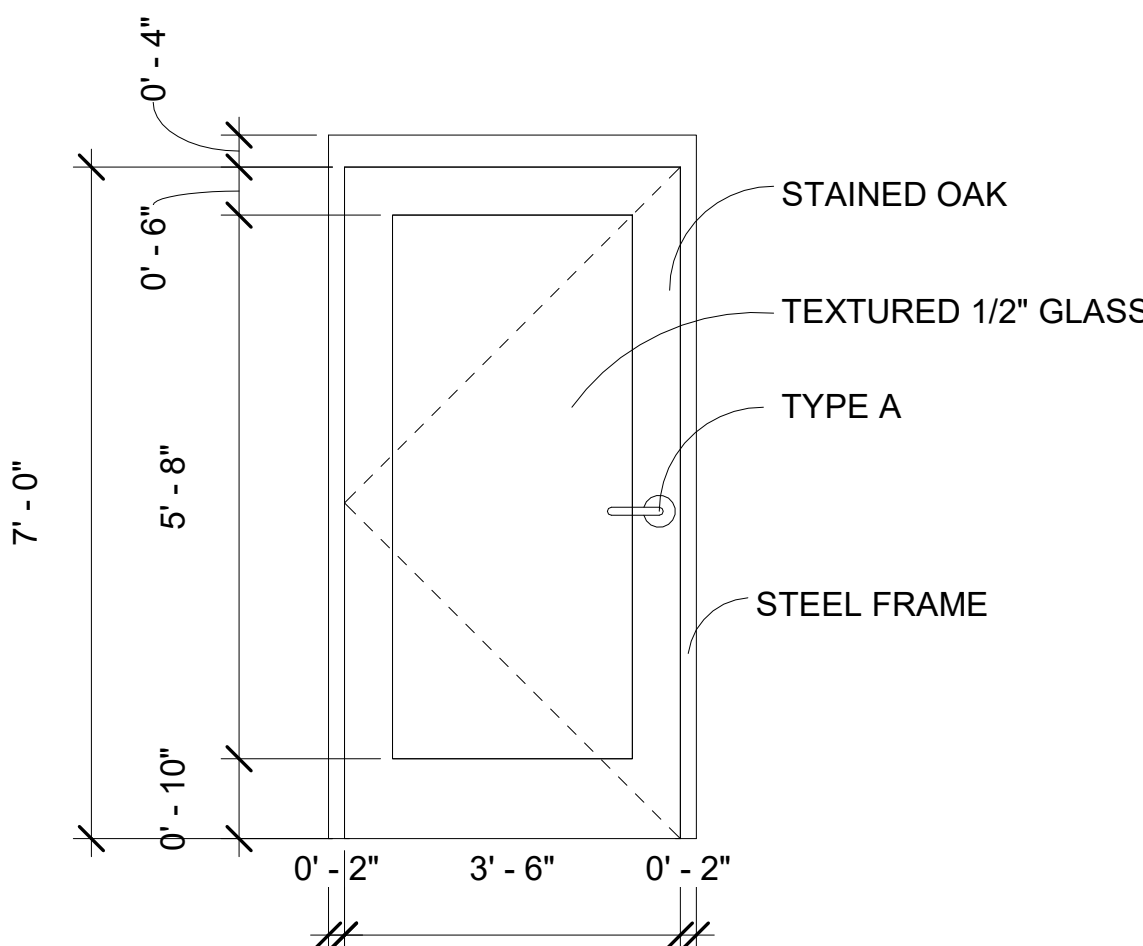

9 Type C-1
1/2" = 1'-0"

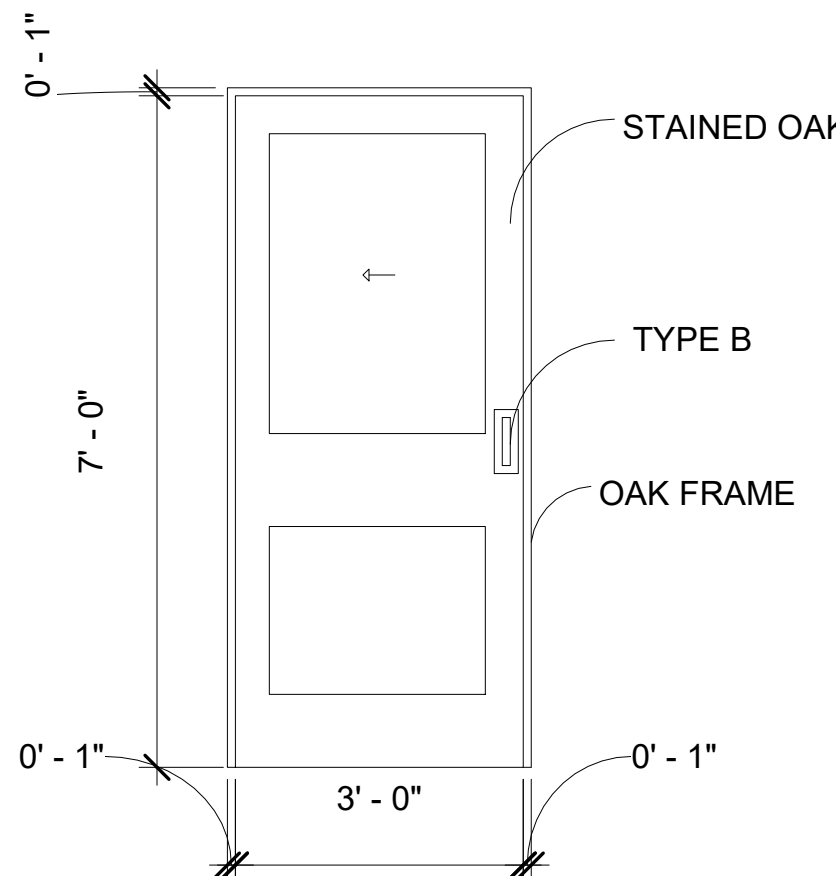

10 Type PD
1/2" = 1'-0"

KSU
ID

Kylie Arett

Kylie Arett
ID 845
Spring Semester
karet@ksu.edu

The Origins Wellness Center
4TH & PIERRE ST. MANHATTAN,
KS. 66502

Description	Date

Hardware
and Door
Schedule

Date	Issue Date
Drawn by	
Checked by	

ID-8.7

Scale	As indicated
-------	--------------